





SEATTLE SCHOOL DISTRICT

LONGFELLOW SCHOOL - ADD'N.

SURVEY & PLOT PLAN

DATE _____	NARRAMORE & RADY ENGINEERS	PREPARED BY _____
APPROVED _____	CENTRAL B.V. STS SEATTLE WASH.	
DRAWN BY _____	CHECKED BY _____	DESIGNED BY _____

RECEIVED

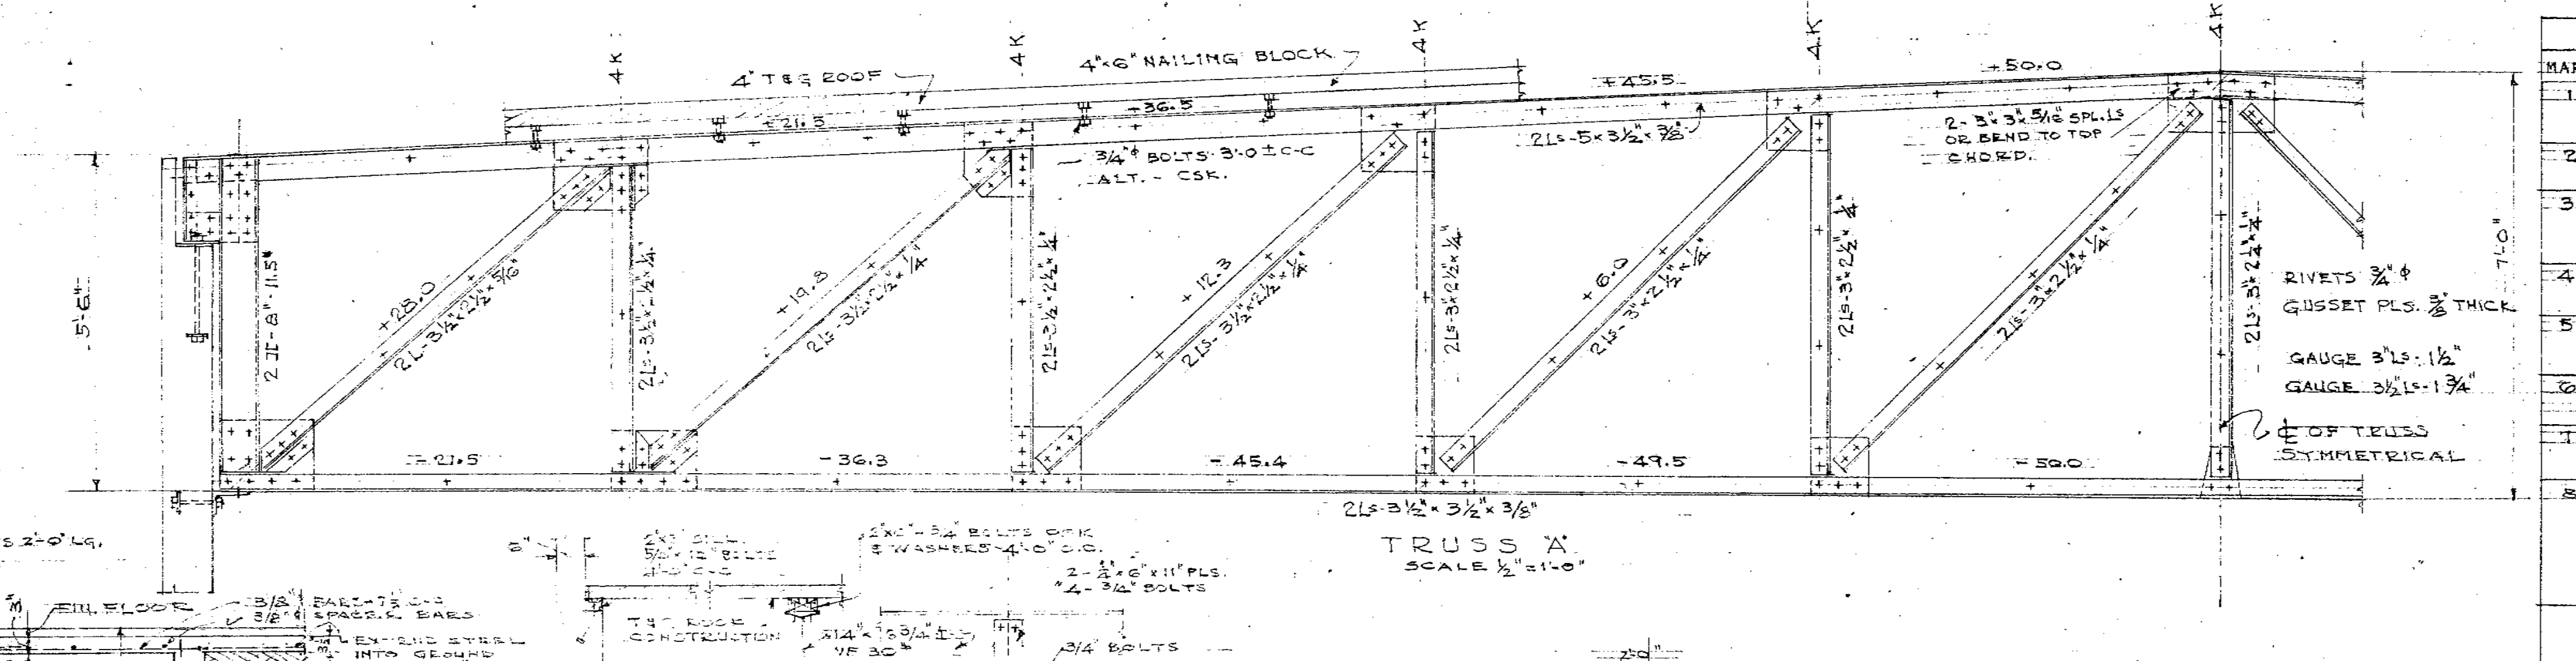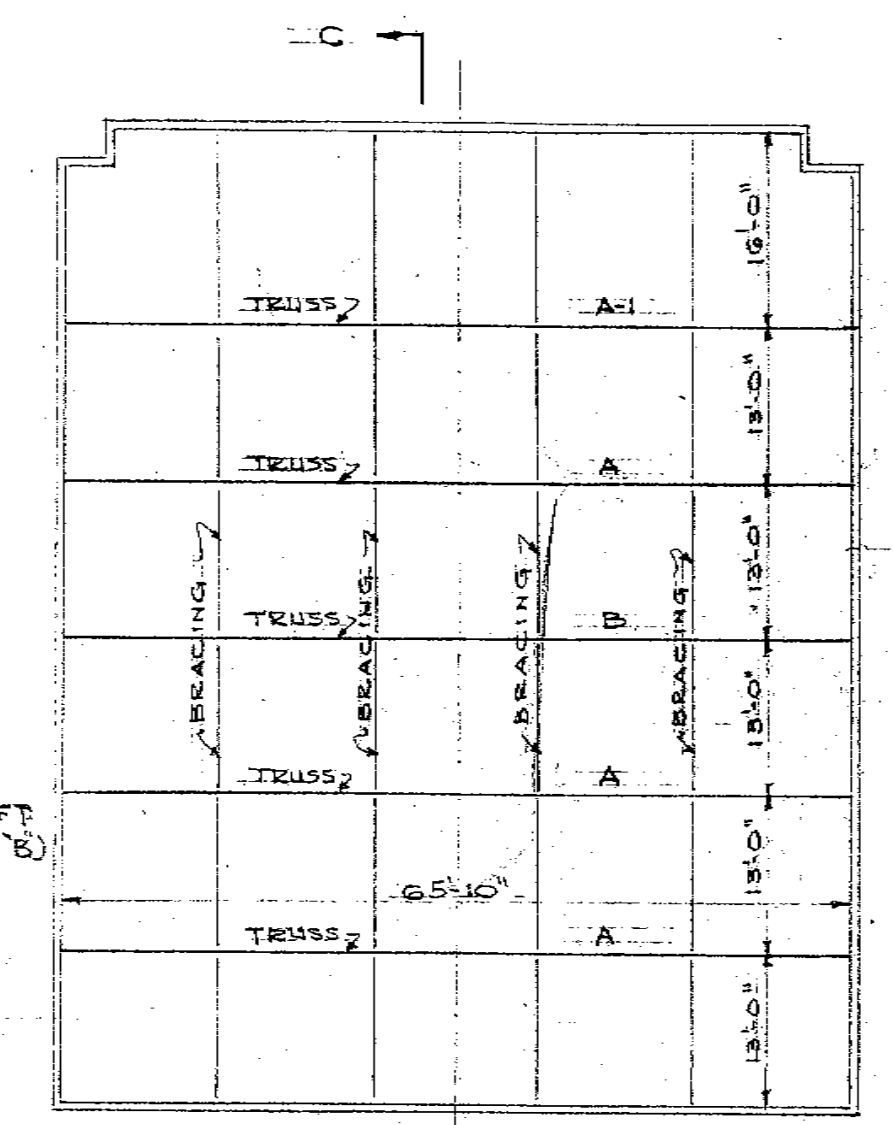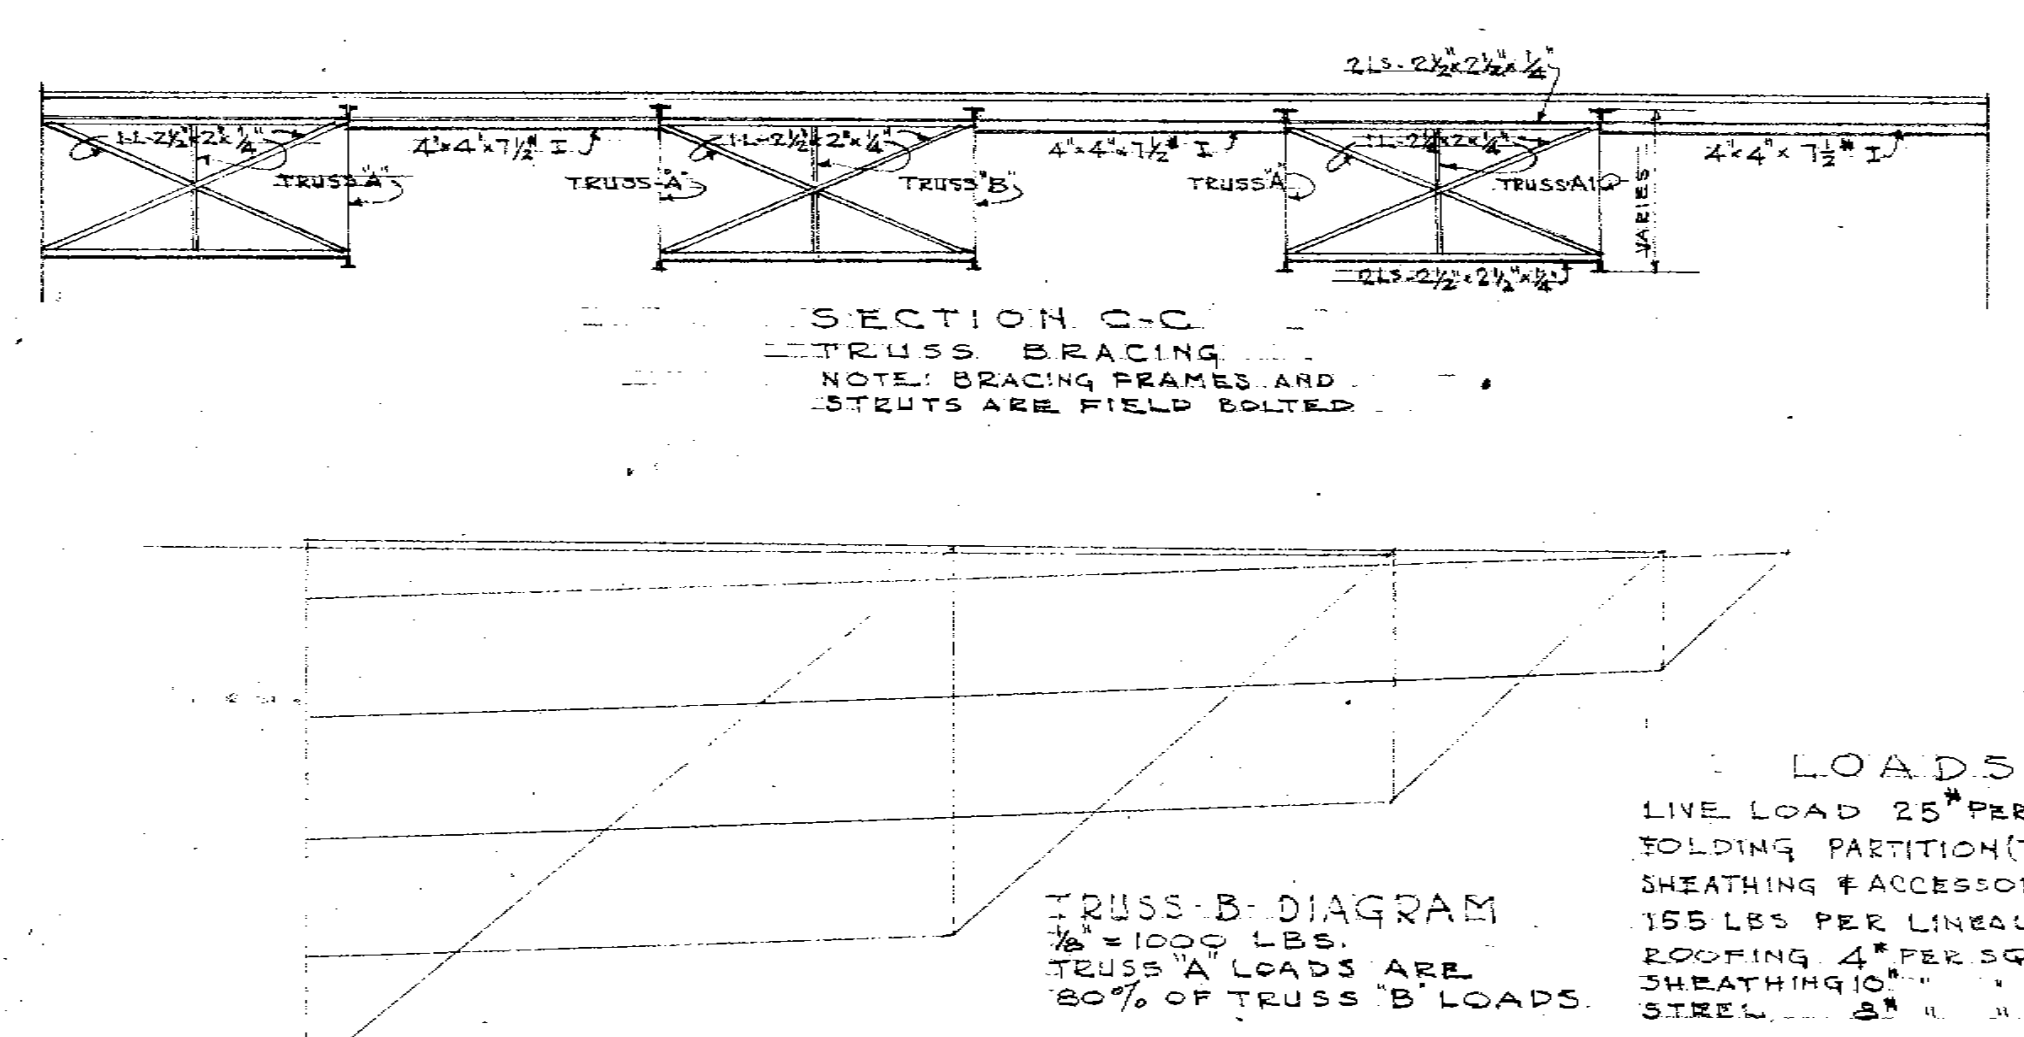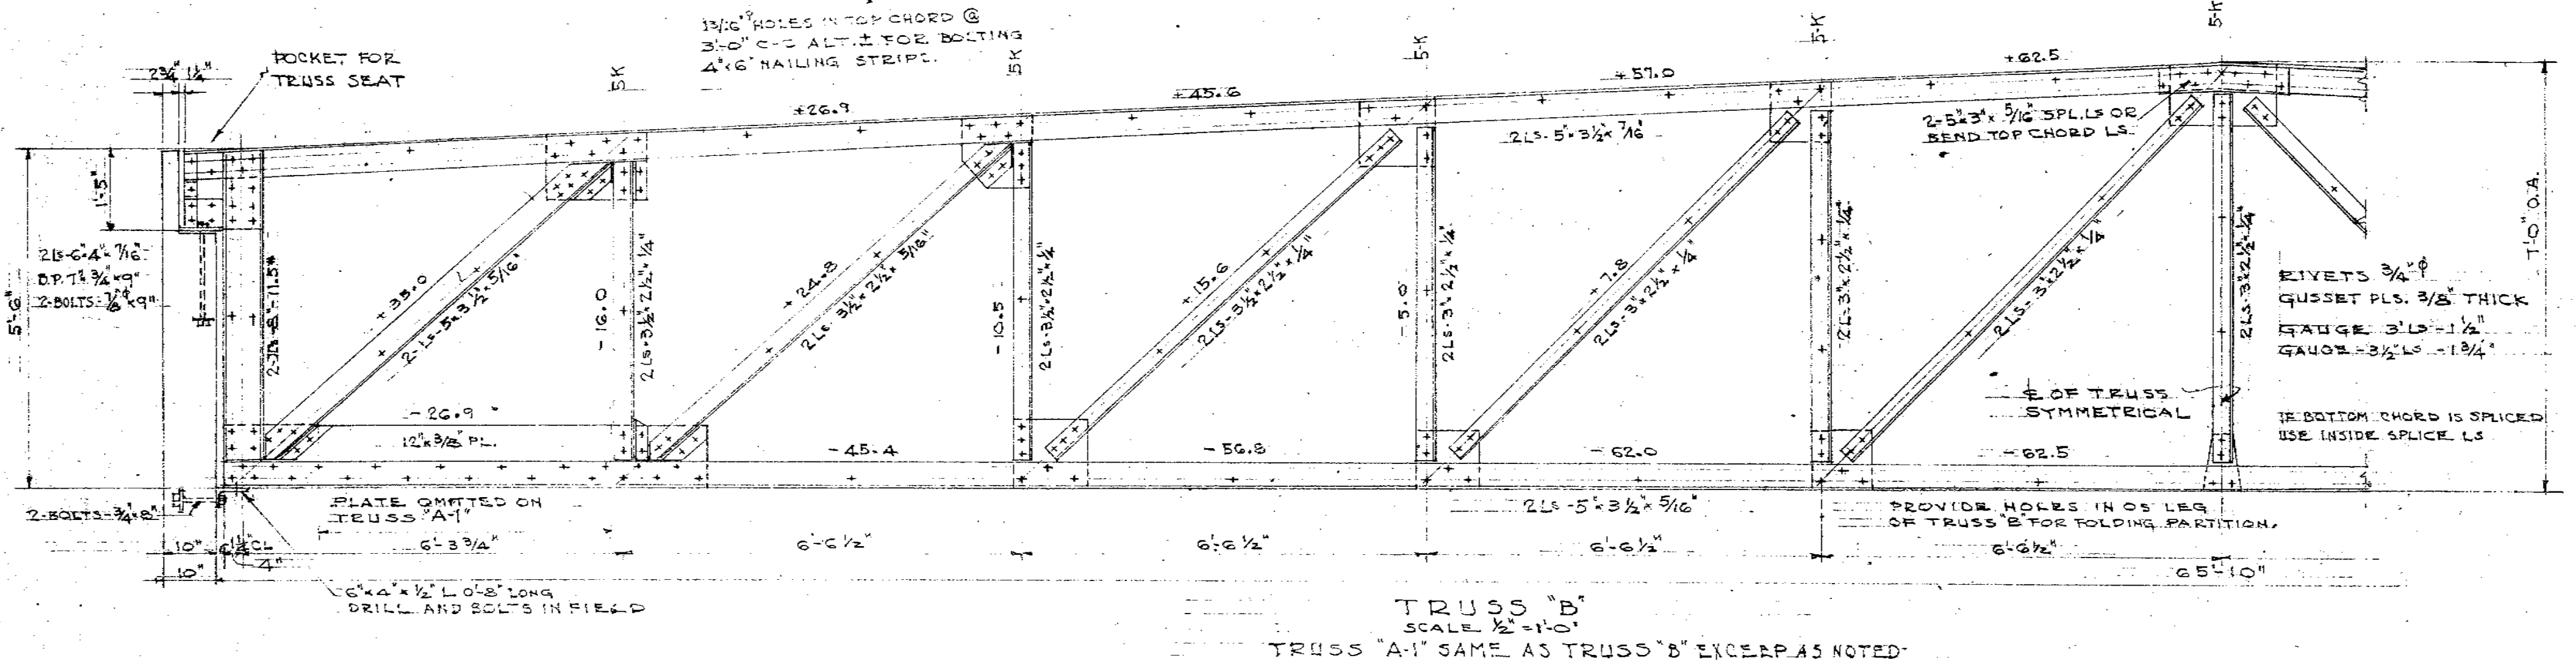

BEAM SCHEDULE

MARK	WIDTH	DEPTH	REIN. BARS	REIN. BARS	STIRRUPS (EACH END)
1	9 1/2	14	2	1 1/2	1/4
2	9 1/2	14	2	1 1/2	1/4
3	9 1/2	14	2	1 1/2	1/4
4	9 1/2	14	2	1 1/2	1/4
5	9 1/2	14	2	1 1/2	1/4
6	11 1/2	21	2	1 1/2	1/4
7	9 1/2	14	2	1 1/2	1/4
8	10	12	3	1	1/4

SLABS - GENERAL NOTES

THE FOLLOWING NOTES APPLY TO ALL REINFORCED SLABS THROUGHOUT THE ENTIRE BUILDING. ALL REINFORCED SLABS SHALL HAVE TEMPERATURE BARS AND ADEQUATE EASERS AND JIGS BACK TO HOLD THE PRINCIPAL REINFORCEMENT IN POSITION.

TEMPERATURE BARS SHALL BE AS FOLLOWS:


SLAB THICKNESS	SIZE OF TEMPERATURE BAR	SPACING ON TEMPERATURE
3" TO 3 1/2"	1/4"	18" C/C MAX.
3 1/2" TO 4"	3/8"	18" C/C MAX.
4" AND OVER	5/8"	18" C/C MAX.

RAISE BARS SHALL BE 1/2" FOR SLABS UP TO 5" THICK, SUPPORTED @ 3'-0" MAXIMUM. RAISE BARS SHALL BE 3/4" FOR SLABS 5" THICK & OVER @ 4'-0" MAXIMUM. EASERS SHALL BE SUPPORTED ON CONCRETE BLOCKS OR PROPER HEIGHT TO PROVIDE 1/2" OR CONCRETE OVER THE MAIN REINFORCEMENT. THE MAIN REINFORCEMENT SHALL BE KEPT 1/2" CLEAR OF THE BOTTOM OF THE SLAB FORMS BY MEANS OF CONCRETE BLOCKS, CHIPS OR OTHER CHAIRS. EASERS BARS AND SUPPORTS SHALL BE SURE RESIST IN SIZE AND NUMBER AT ALL POINTS TO PROVIDE SECURE SUPPORT FOR THE REINFORCEMENT. TEMPERATURE, EASER, AND SPACER BARS SHALL BE LAP-SPLICED AT LEAST 3'-0" WHERE THEY JOIN AND WHERE THEY MEET ADJACENT SLABS SHALL BE SURE RESIST IN SIZE AND NUMBER AT ALL POINTS TO PROVIDE SECURE SUPPORT FOR THE REINFORCEMENT. TEMPERATURE, EASER, AND SPACER BARS SHALL BE LAP-SPLICED AT LEAST 3'-0" INTO THAT SLAB. ALL SLAB BARS SHALL BE BENT AND SET TO SECURE THE FULL ADVANTAGE OF CONTINUOUS CONSTRUCTION AND LATERALS AND INTERFERE WITH THE CONDITIONS OF CONTINUITY AND RESTRAINT SURROUNDING THEREIN. SPECIFICALLY SHOWN OR NOT, WHERE BENT BARS ARE REQUIRED IN SLABS, THE SAME SHALL IN GENERAL BE BENT UP AT OR NEAR THE MIDDLE POINT OF THE CLEAR SPAN AND CARRIED IN THE TOP OF THE SLAB OVER THE SUPPORT TO THE QUARTER POINT OF THE ADJACENT SPAN, OR AS REQUIRED BY NOTES AND DETAILS. WHERE ADJACENT SPANS VARY CONSIDERABLY IN SPAN LENGTH, THE BEND POINTS SHALL BE AS DIRECTED BY THE ARCHITECT. IN GENERAL, 3/8" SLAB BARS SHALL BE PROVIDED ON THE WOOD, IN LONG LENGTHS AND CUT, BENT OR CHICKENED ON THE GROUND AS REQUIRED. WHERE SLOTS OR OPENINGS ARE REQUIRED IN SLABS, THE SLAB BARS SHALL BE SPREAD, NOT CUT OR DISCONTINUED AND ADDITIONAL BARS SHALL BE PLACED ABOUT THE OPENING AS DIRECTED. WHERE NO PLAN IS PROVIDED UNDER THE EDGE OF A SLAB SUPPORTING WALL, THE BARS SHALL BE BENT UP INTO THE WALL AT LEAST 1'-0" TO SECURE NECESSARY SLAB REINFORCEMENT. SLAB ADJUNCTION SLABS ON GROUND, SLAB BARS SHALL BE EXTENDED AT LEAST 3'-0" INTO GROUND SLAB AND NOT FURTHER APART THAN 1'-0".

GROUND SLABS ADJACENT TO WALLS SHALL BE REINFORCED BY 3/8" SET AND INTERSECT IN THE WALL AND EXTENDED AT LEAST 3'-0" INTO THE GROUND SLAB. THE SPACING OF SUCH BARS SHALL NOT EXCEED 1'-0". SUCH REINFORCEMENT SHALL NOT BE PROVIDED FOR THE FLOORS OF TUNNELS.

WHERE ADJACENT SLABS ARE REINFORCED AT RIGHT ANGLES TO EACH OTHER THE CONTINUITY OF THE STEEL IN HEADS SHALL BE FULLY MAINTAINED BY PROVIDING AND PLACING TOP STEEL OVER THE SUPPORT EQUAL TO THAT WHICH WOULD BE REQUIRED IF THE SLABS WERE BUILT AS ONE SLAB. THE EDGE OF THE SUPPORTING MEMBER INTO THE ADJOINING SLAB.

DATUM OF FIN. GROUND FLOOR IS ASSUMED TO BE 2'-0" THIS IS ELEV. 355.00

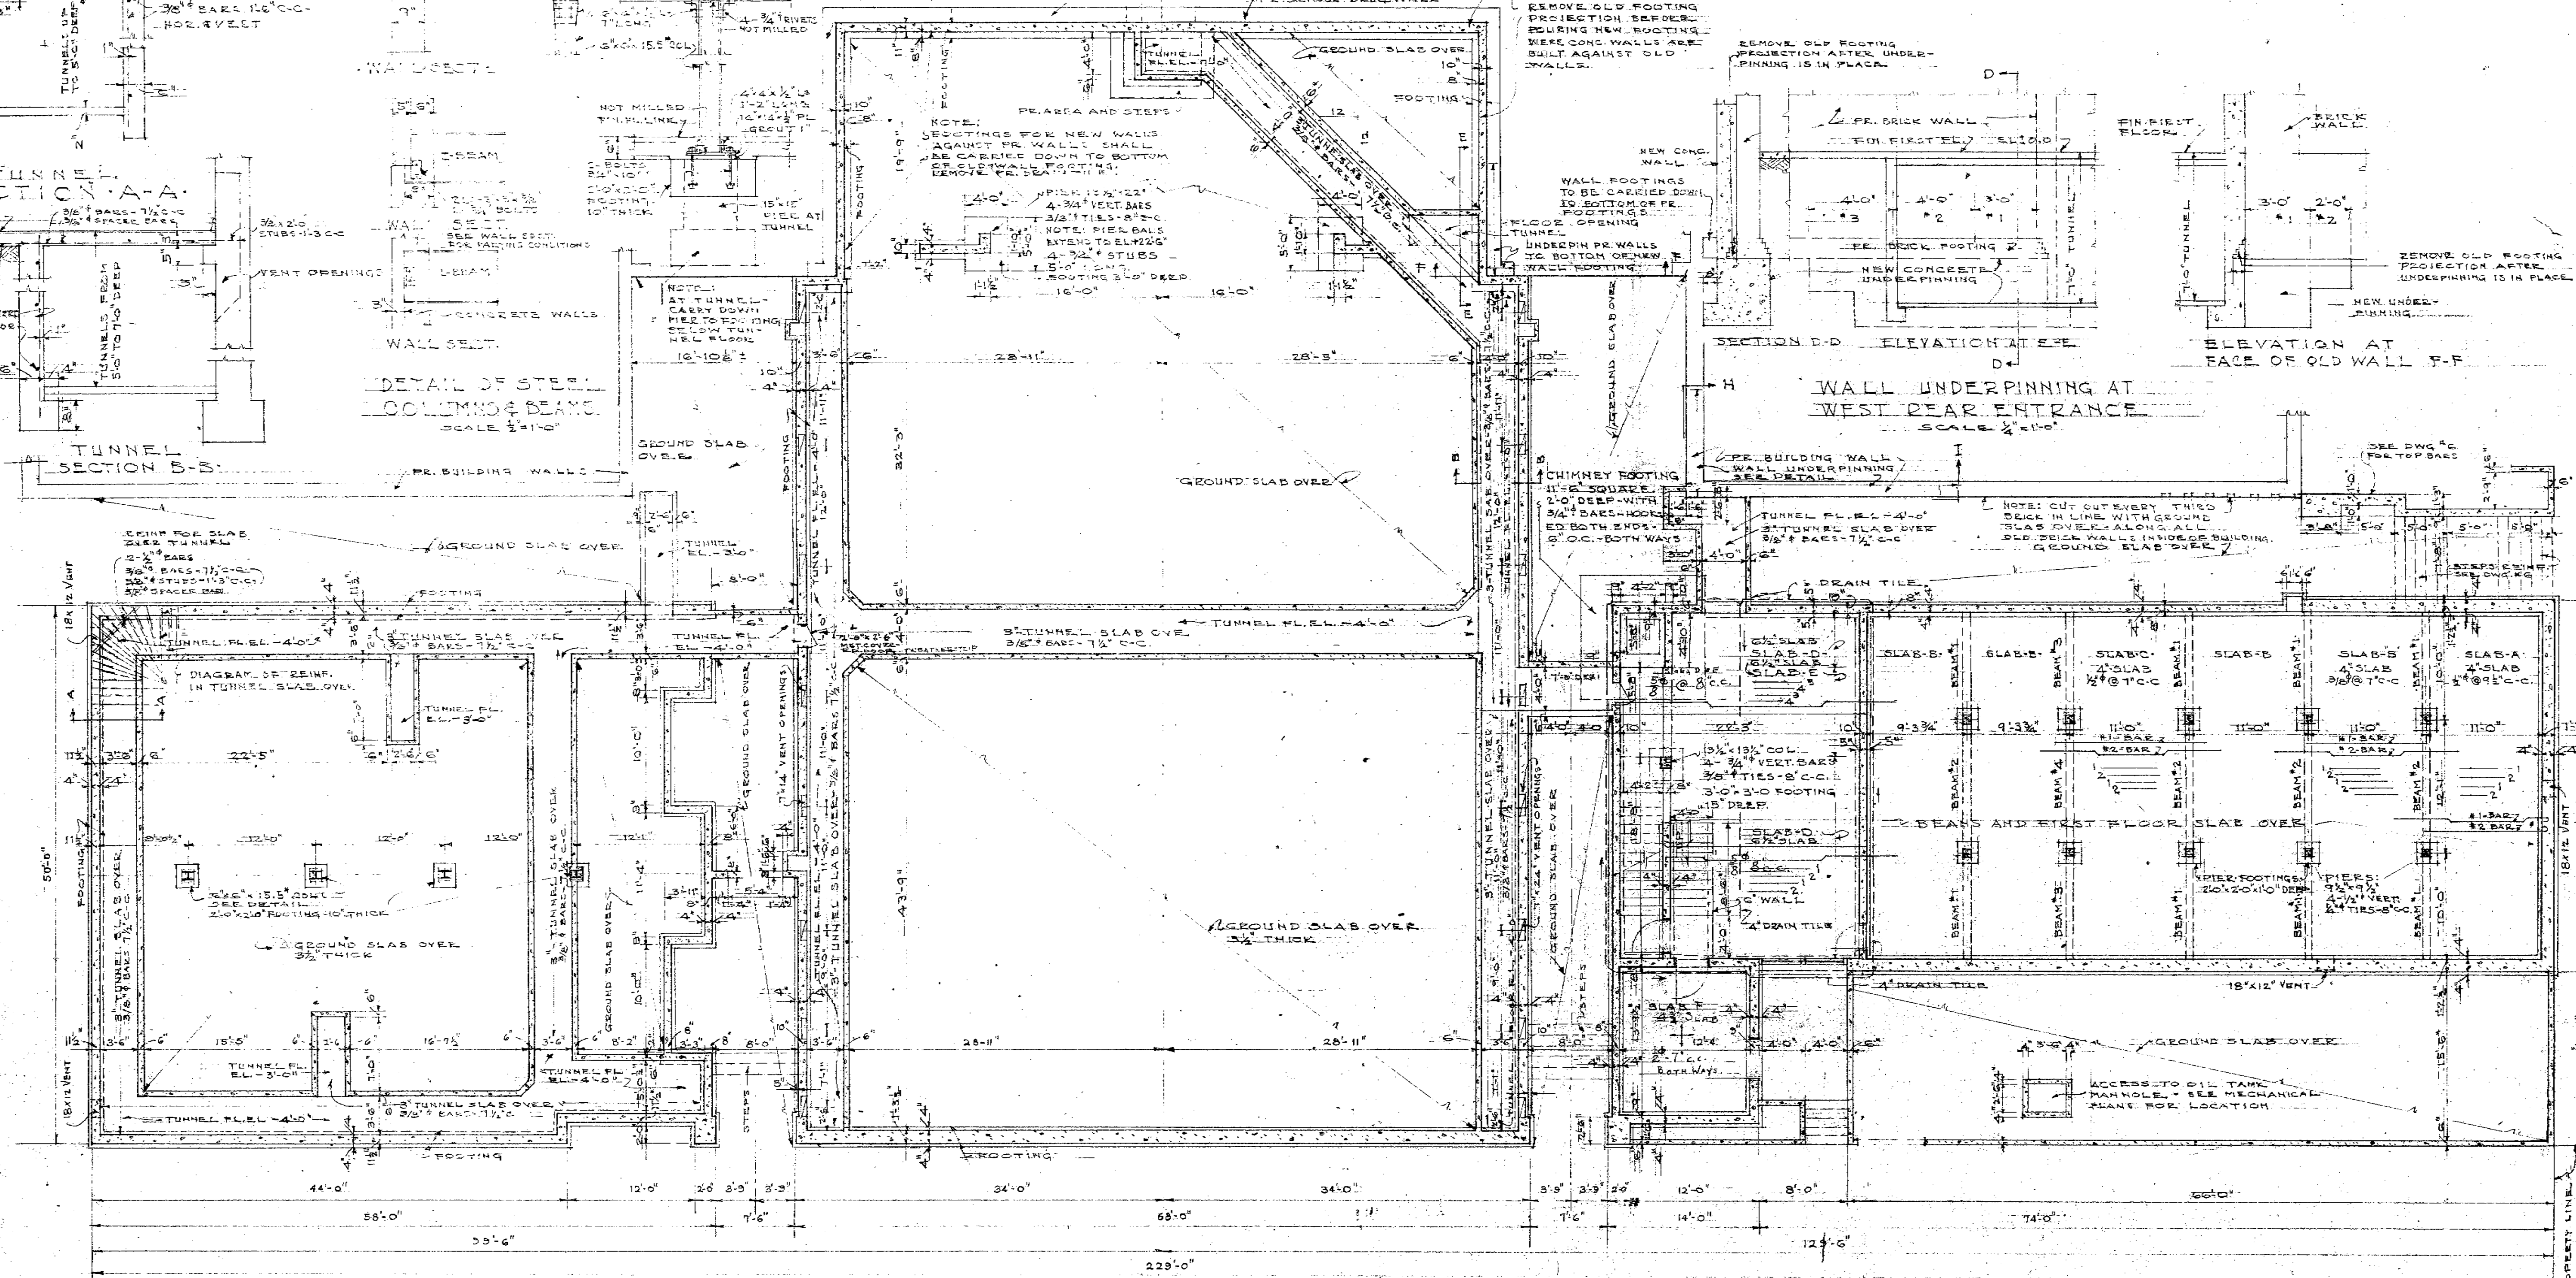

WALL NOTES

ALL CONCRETE WALLS SHALL BE REINFORCED WITH 2" REINFORCING BARS. REINFORCING BARS SHALL BE REINFORCED WITH 2" REINFORCING BARS. REINFORCING BARS SHALL BE REINFORCED WITH 2" REINFORCING BARS.

DESIGN NOTES

FOOTINGS DESIGNED FOR MAX. 4000' PER SQ. FT. ON DEAD LOAD ALONE.


CONCRETE IS A CONSTRUCTION MIX: 1 1/2:2 1/4:3 1/4 @ 1 1/2 SLUMP MINIMUM STRENGTH @ 28 DAYS 2000' PSI IN 6" x 12" CYLINDER

LOADS: 25' PER SQ. FT. FLOORS 50' PER SQ. FT. ROOF 15' PER SQ. FT. TUNNEL ROOF 100' PER SQ. FT.

NOTE: 4TH FLOOR IS ON GROUND, TUNNEL ROOF GOOD FOR 100'.

WALL UNDERPINNING NOTES

CONTRACTOR SHALL ADEQUATELY SUPPORT ALL WALLS, ETC., DURING UNDERPINNING OPERATIONS AND BE RESPONSIBLE FOR ANY DAMAGE DONE TO EXISTING WALLS, FLOORS, ETC., DISTURBED IN PERFORMING WORK. WALL UNDERPINNING SHALL BE DONE BEFORE EXCAVATION WORK AFFECTING UNDERPINNED WALLS IS STARTED. UNDERPINNING SHALL BE DONE IN SECTIONS STARTING WITH NO. 1, 2, 3 AND 4. NO. 1 SECTIONS SHALL BE COMPLETE BEFORE NO. 2 SECTIONS ARE STARTED AND SO ON UNTIL ALL SECTIONS ARE COMPLETED. CONCRETE SHALL BE 1-2-4 MIX WITH QUICK SET CEMENT AS SPECIFIED.

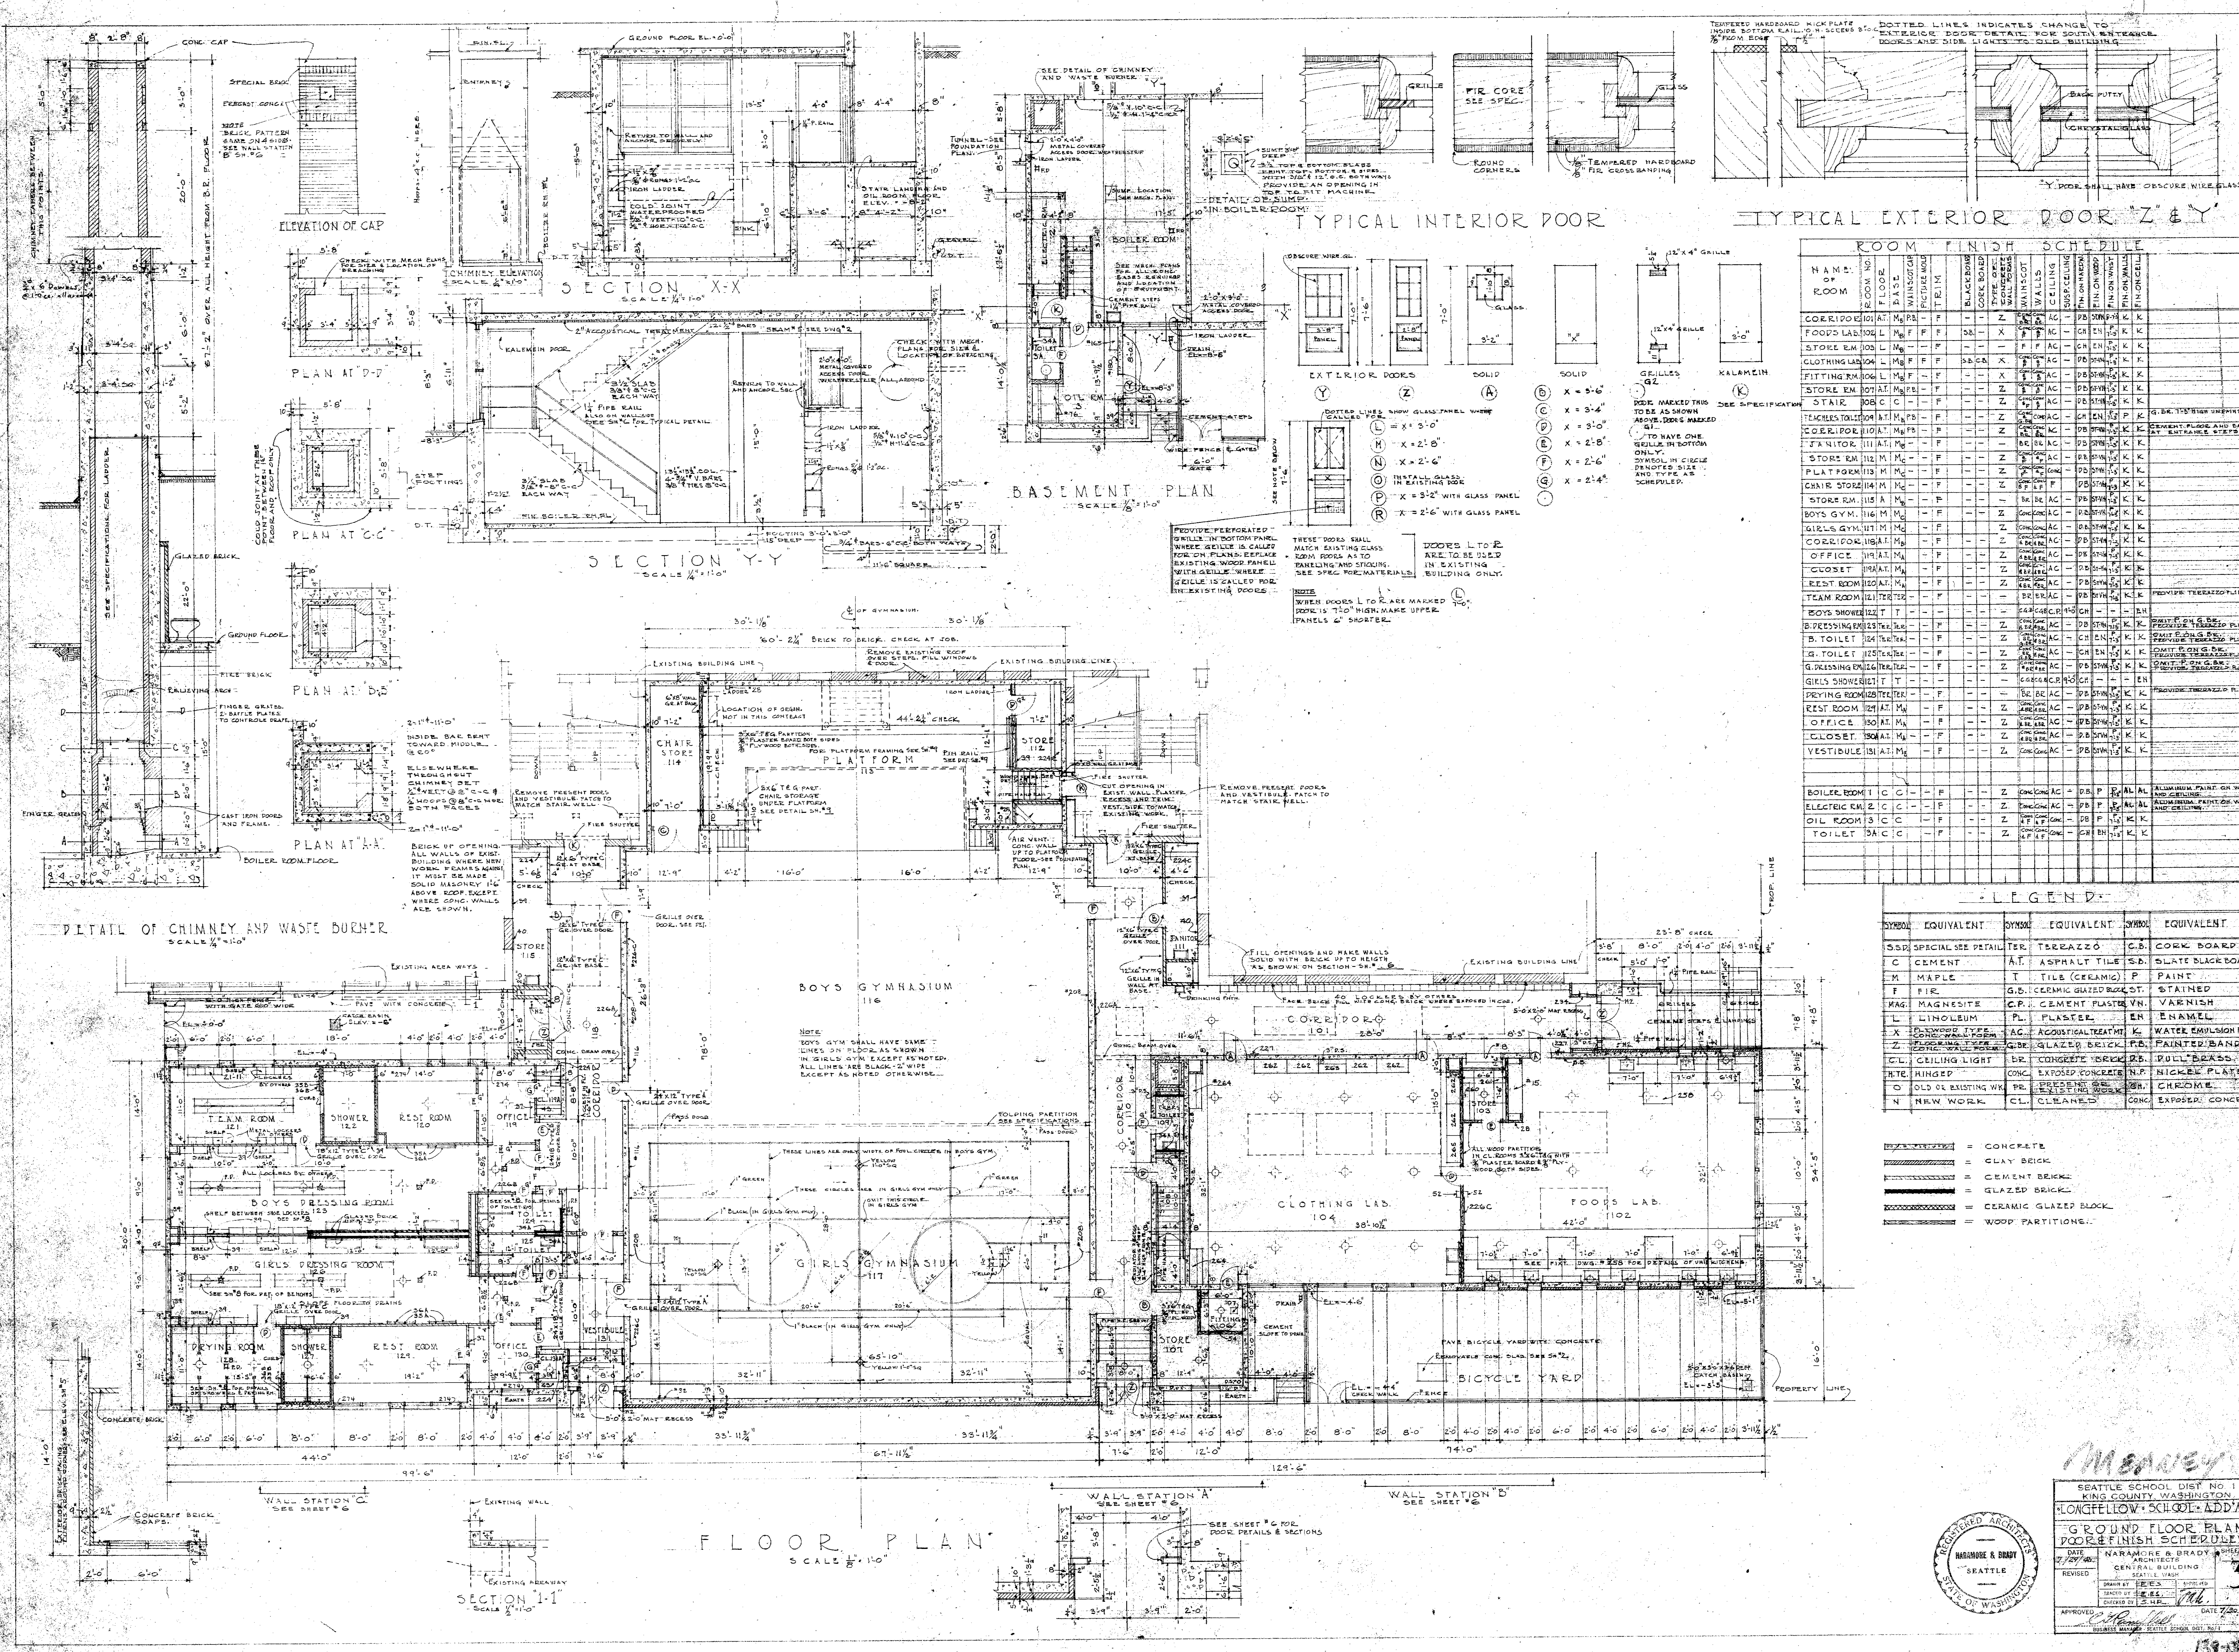

ROOM FINISH SCHEDULE									
NAME OF ROOM	NO.	FLOOR	WALLS	CEILING	DOORS	WINDOWS	FINISH	FINISH	FINISH
CORRIDOR 101	101	M	F	-	-	-	-	-	-
FOODS LAB 102	102	L	M	F	-	-	-	-	-
STOIL RM 103	103	L	M	-	-	-	-	-	-
CLOTHING LAB 104	104	L	M	F	-	-	-	-	-
FITTING RM 105	105	L	M	F	-	-	-	-	-
STOIL RM 106	106	L	M	-	-	-	-	-	-
STAIR	107	C	-	-	-	-	-	-	-
TEACHERS' ROOM 108	108	M	F	-	-	-	-	-	-
CORRIDOR 109	109	M	F	-	-	-	-	-	-
STAIR 110	110	M	-	-	-	-	-	-	-
STOIL RM 111	111	M	-	-	-	-	-	-	-
STOIL RM 112	112	M	-	-	-	-	-	-	-
STOIL RM 113	113	M	-	-	-	-	-	-	-
STOIL RM 200	200	M	-	-	-	-	-	-	-

SYMBOL	EQUIVALENT	SYMBOL	EQUIVALENT	SYMBOL	EQUIVALENT
SSR	SPECIAL SEE DETAIL	TER	TERAZZO	CB	CORK BOARD
C	CEMENT	AT	ASPHALT	SB	SLATE BLACK BOARD
M	MAPLE	T	TILE (CERAMIC)	P	PAINT
F	FIR	G.S.	CERAMIC GLAZED BLOCK	ST	STAINED
MAG	MAGNESITE	C.P.	CEMENT PLASTER	VN	VARNISH
L	LINOLEUM	PL	PLASTER	EN	ENAMEL
X	PLYWOOD TYPE	AC	ACROUSTICAL TREATMENT	K	WATER EMULSION PAINT
Z	FLOORING TYPE	G.B.	GLAZED BRICK	FB	PAINTER'S BAND
CL	CILING LIGHT	BR	CONCRETE BRICK	DB	PULL BRASS
HTB	HINGED	CONC	EXPOSED CONCRETE	N.P.	NICKEL PLATED
O	OLD OR EXISTING WK	PE	PRESERVE OR RESTORE	CH	CHROME
N	NEW WORK	CL	CLEANED	CONC	EXPOSED CONCRETE

CONCRETE
CLAY BRICK
CEMENT BRICK
GLAZED BRICK
CERAMIC GLAZED BLOCK
WOOD PARTITIONS

MEADLEY

SEATTLE SCHOOL DIST NO 1
KING COUNTY, WASHINGTON
LONGFELLOW SCHOOL ADDN










GROUND FLOOR PLAN
DOOR FINISH SCHEDULE

DATE 7/27/20
REVISED
DRAWN BY J. E. L. LUTHERY
CHECKED BY J. E. L. LUTHERY

APPROVED [Signature]
BUSINESS MANAGER, SEATTLE SCHOOL DIST NO 1

3

151-071

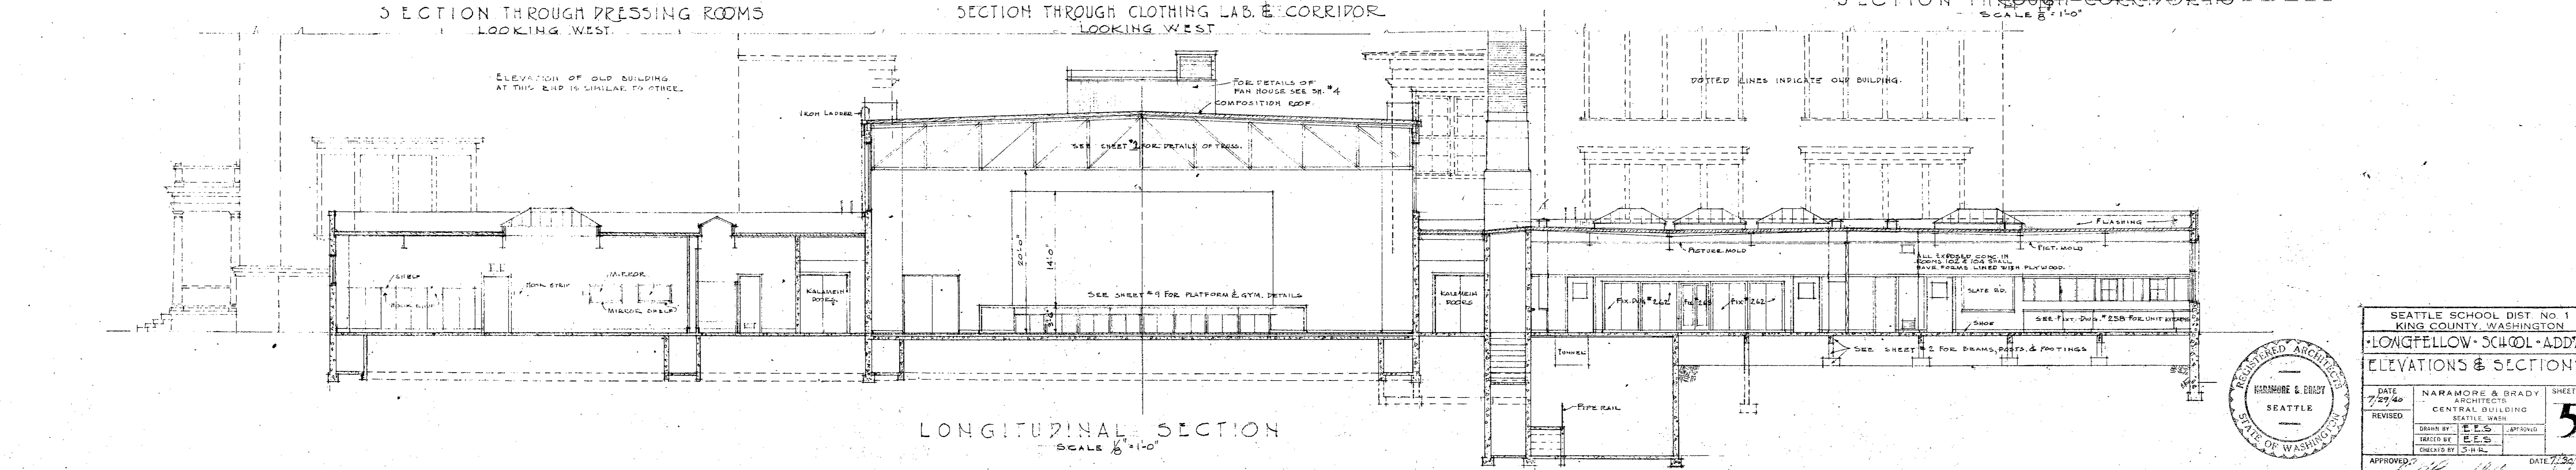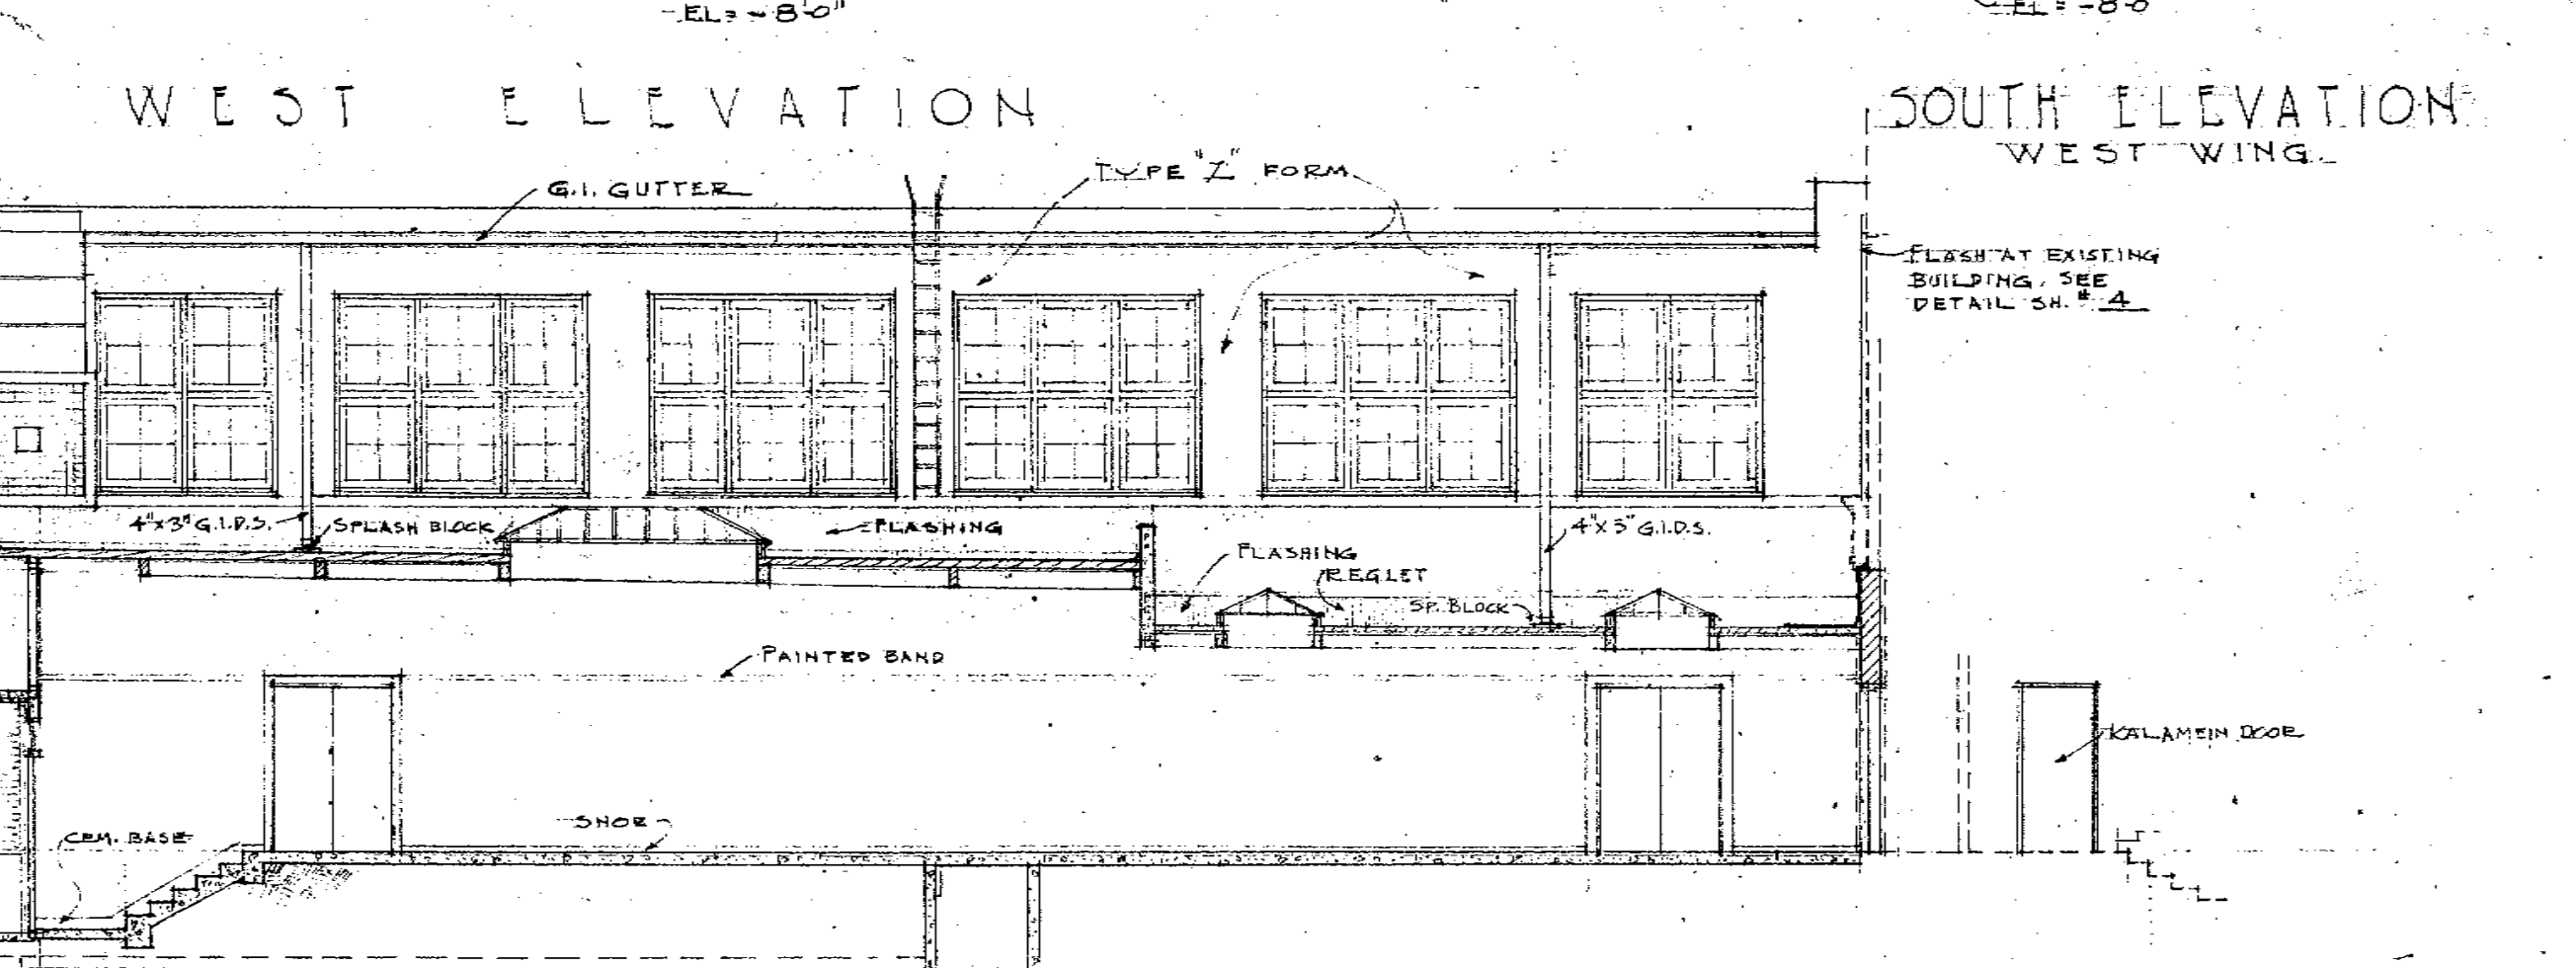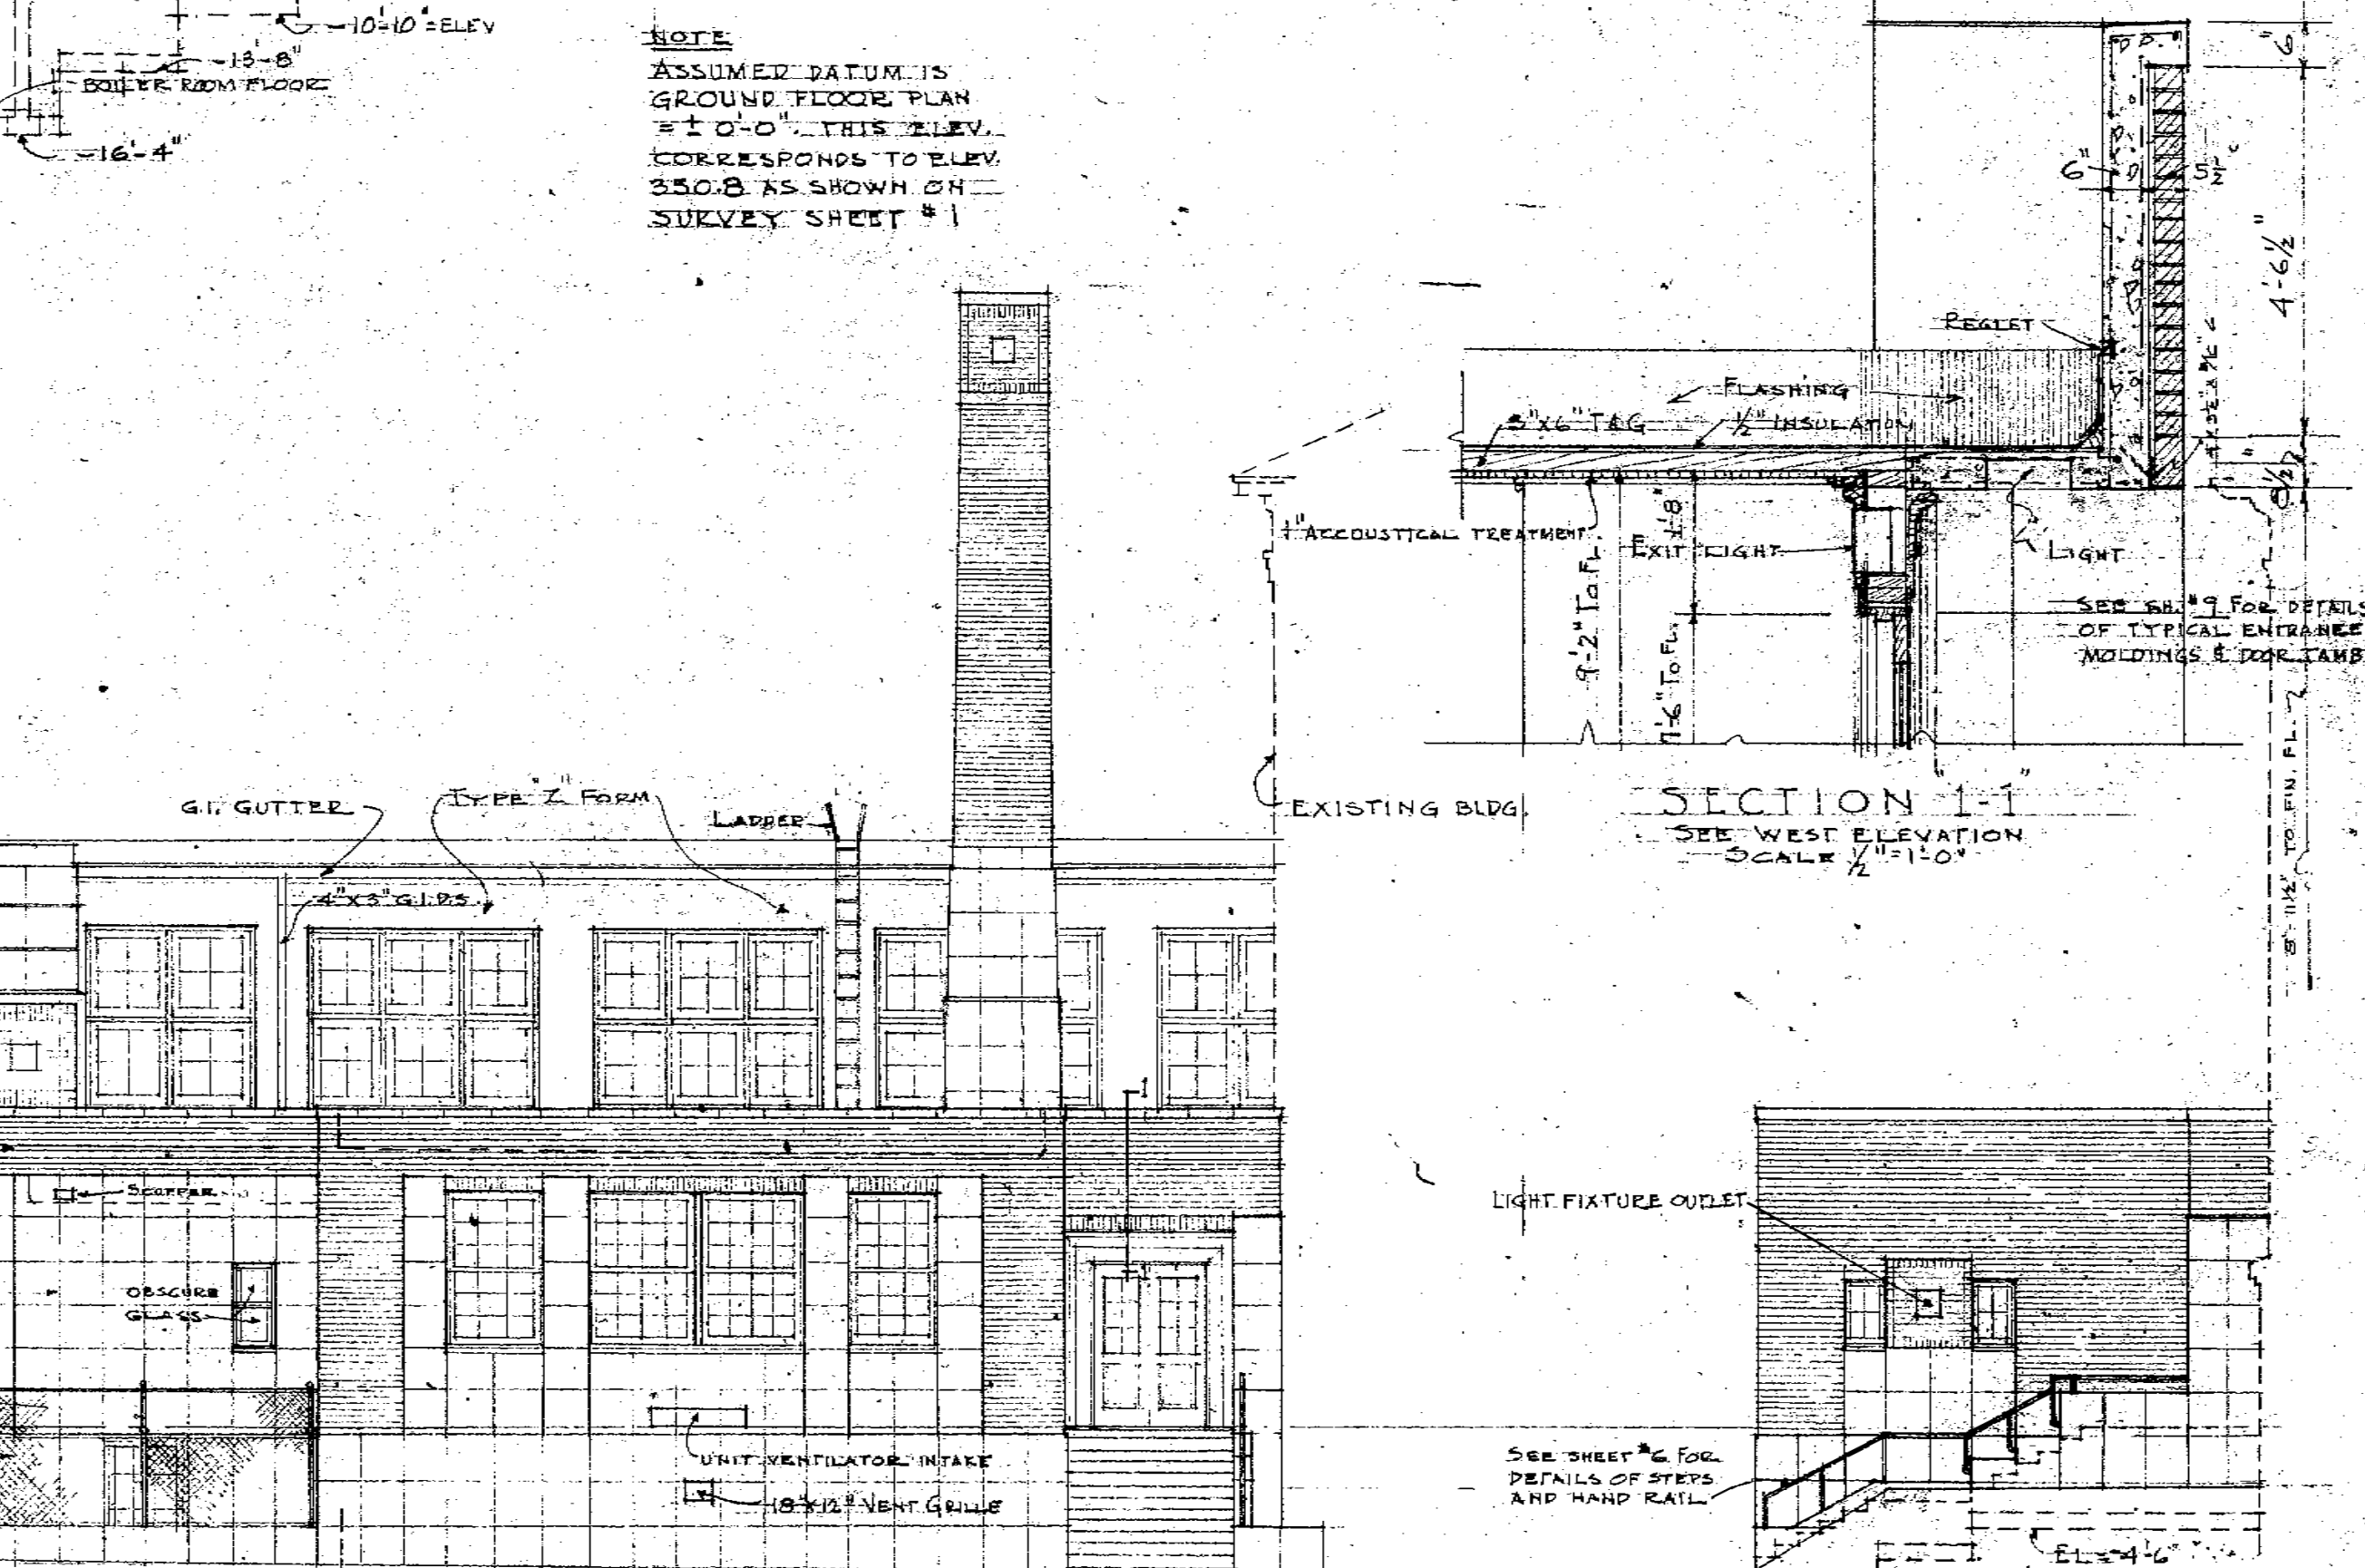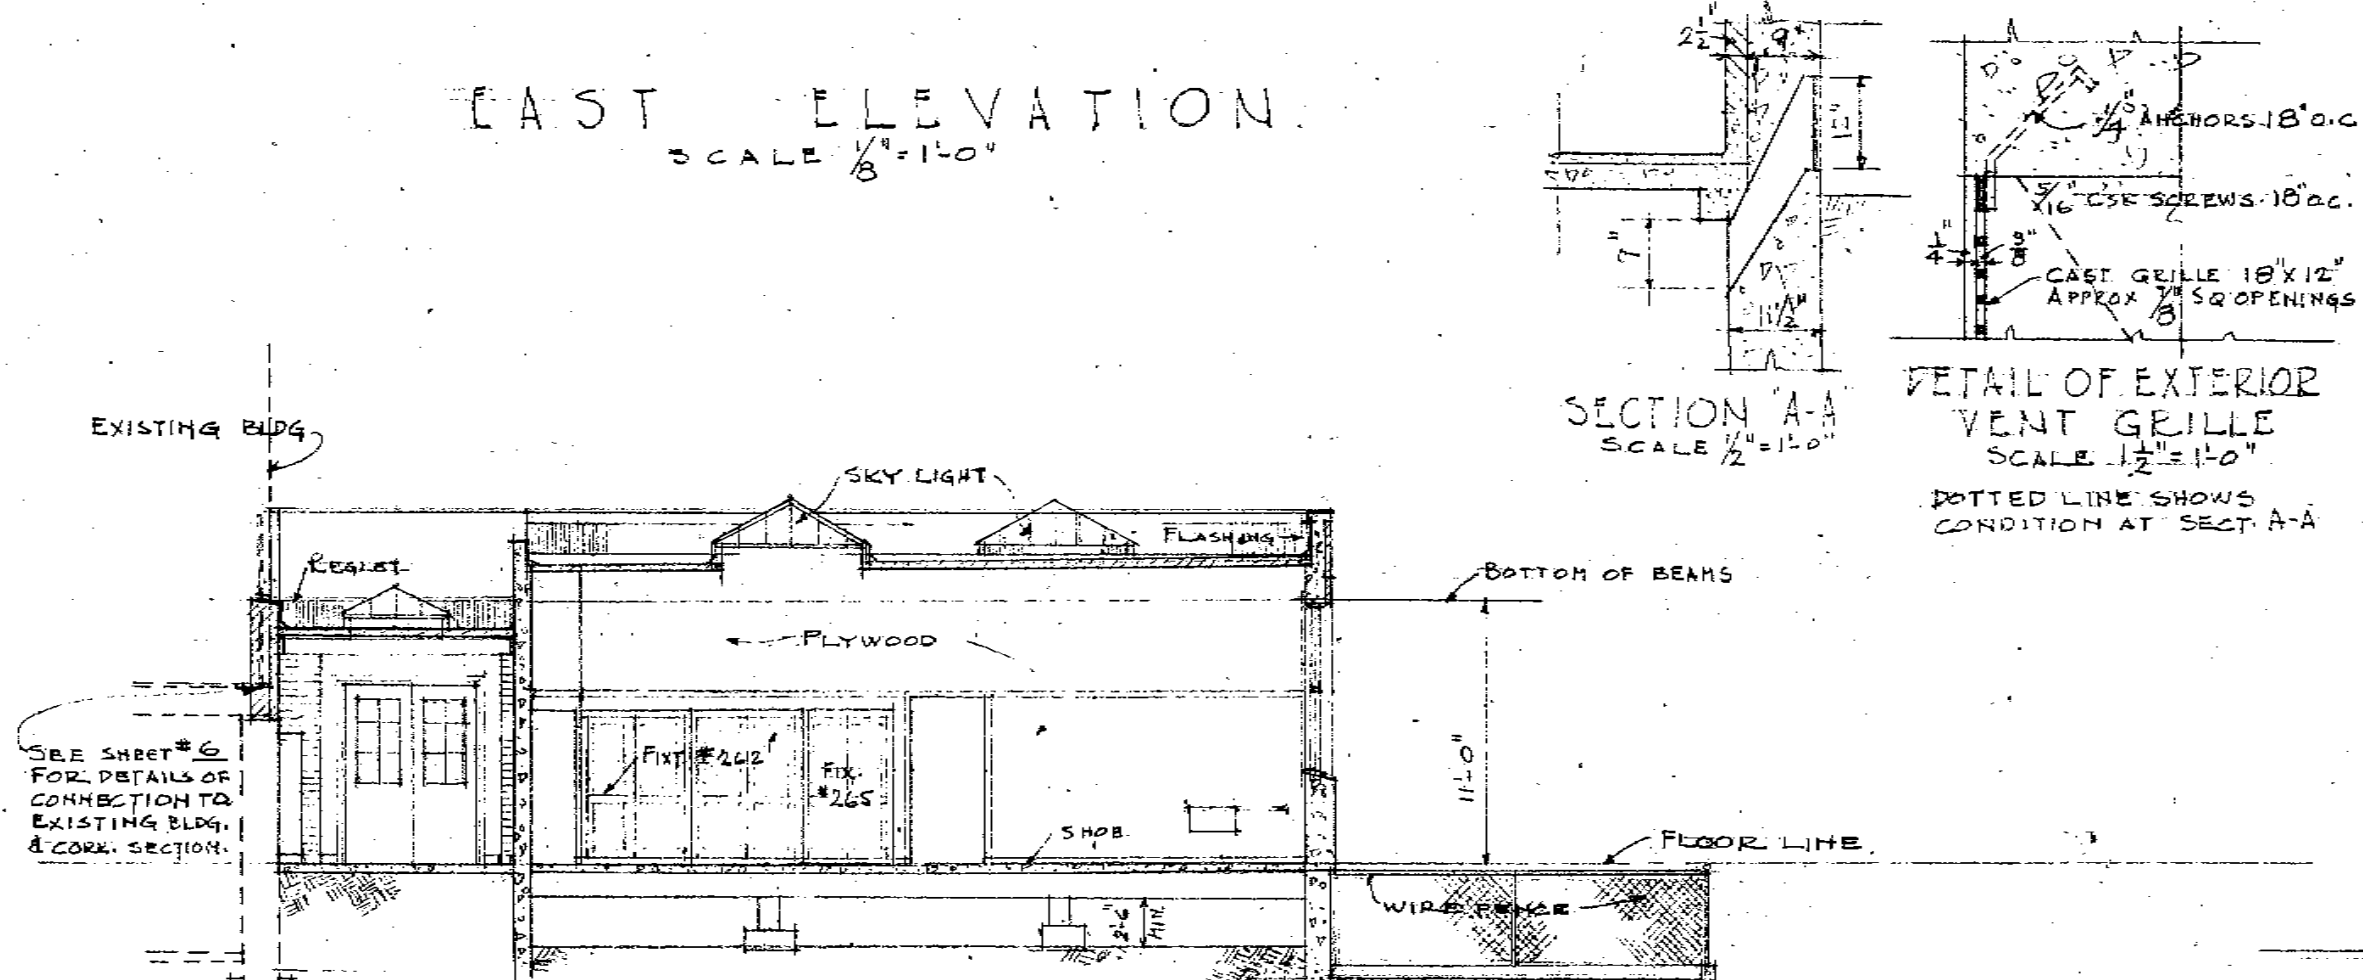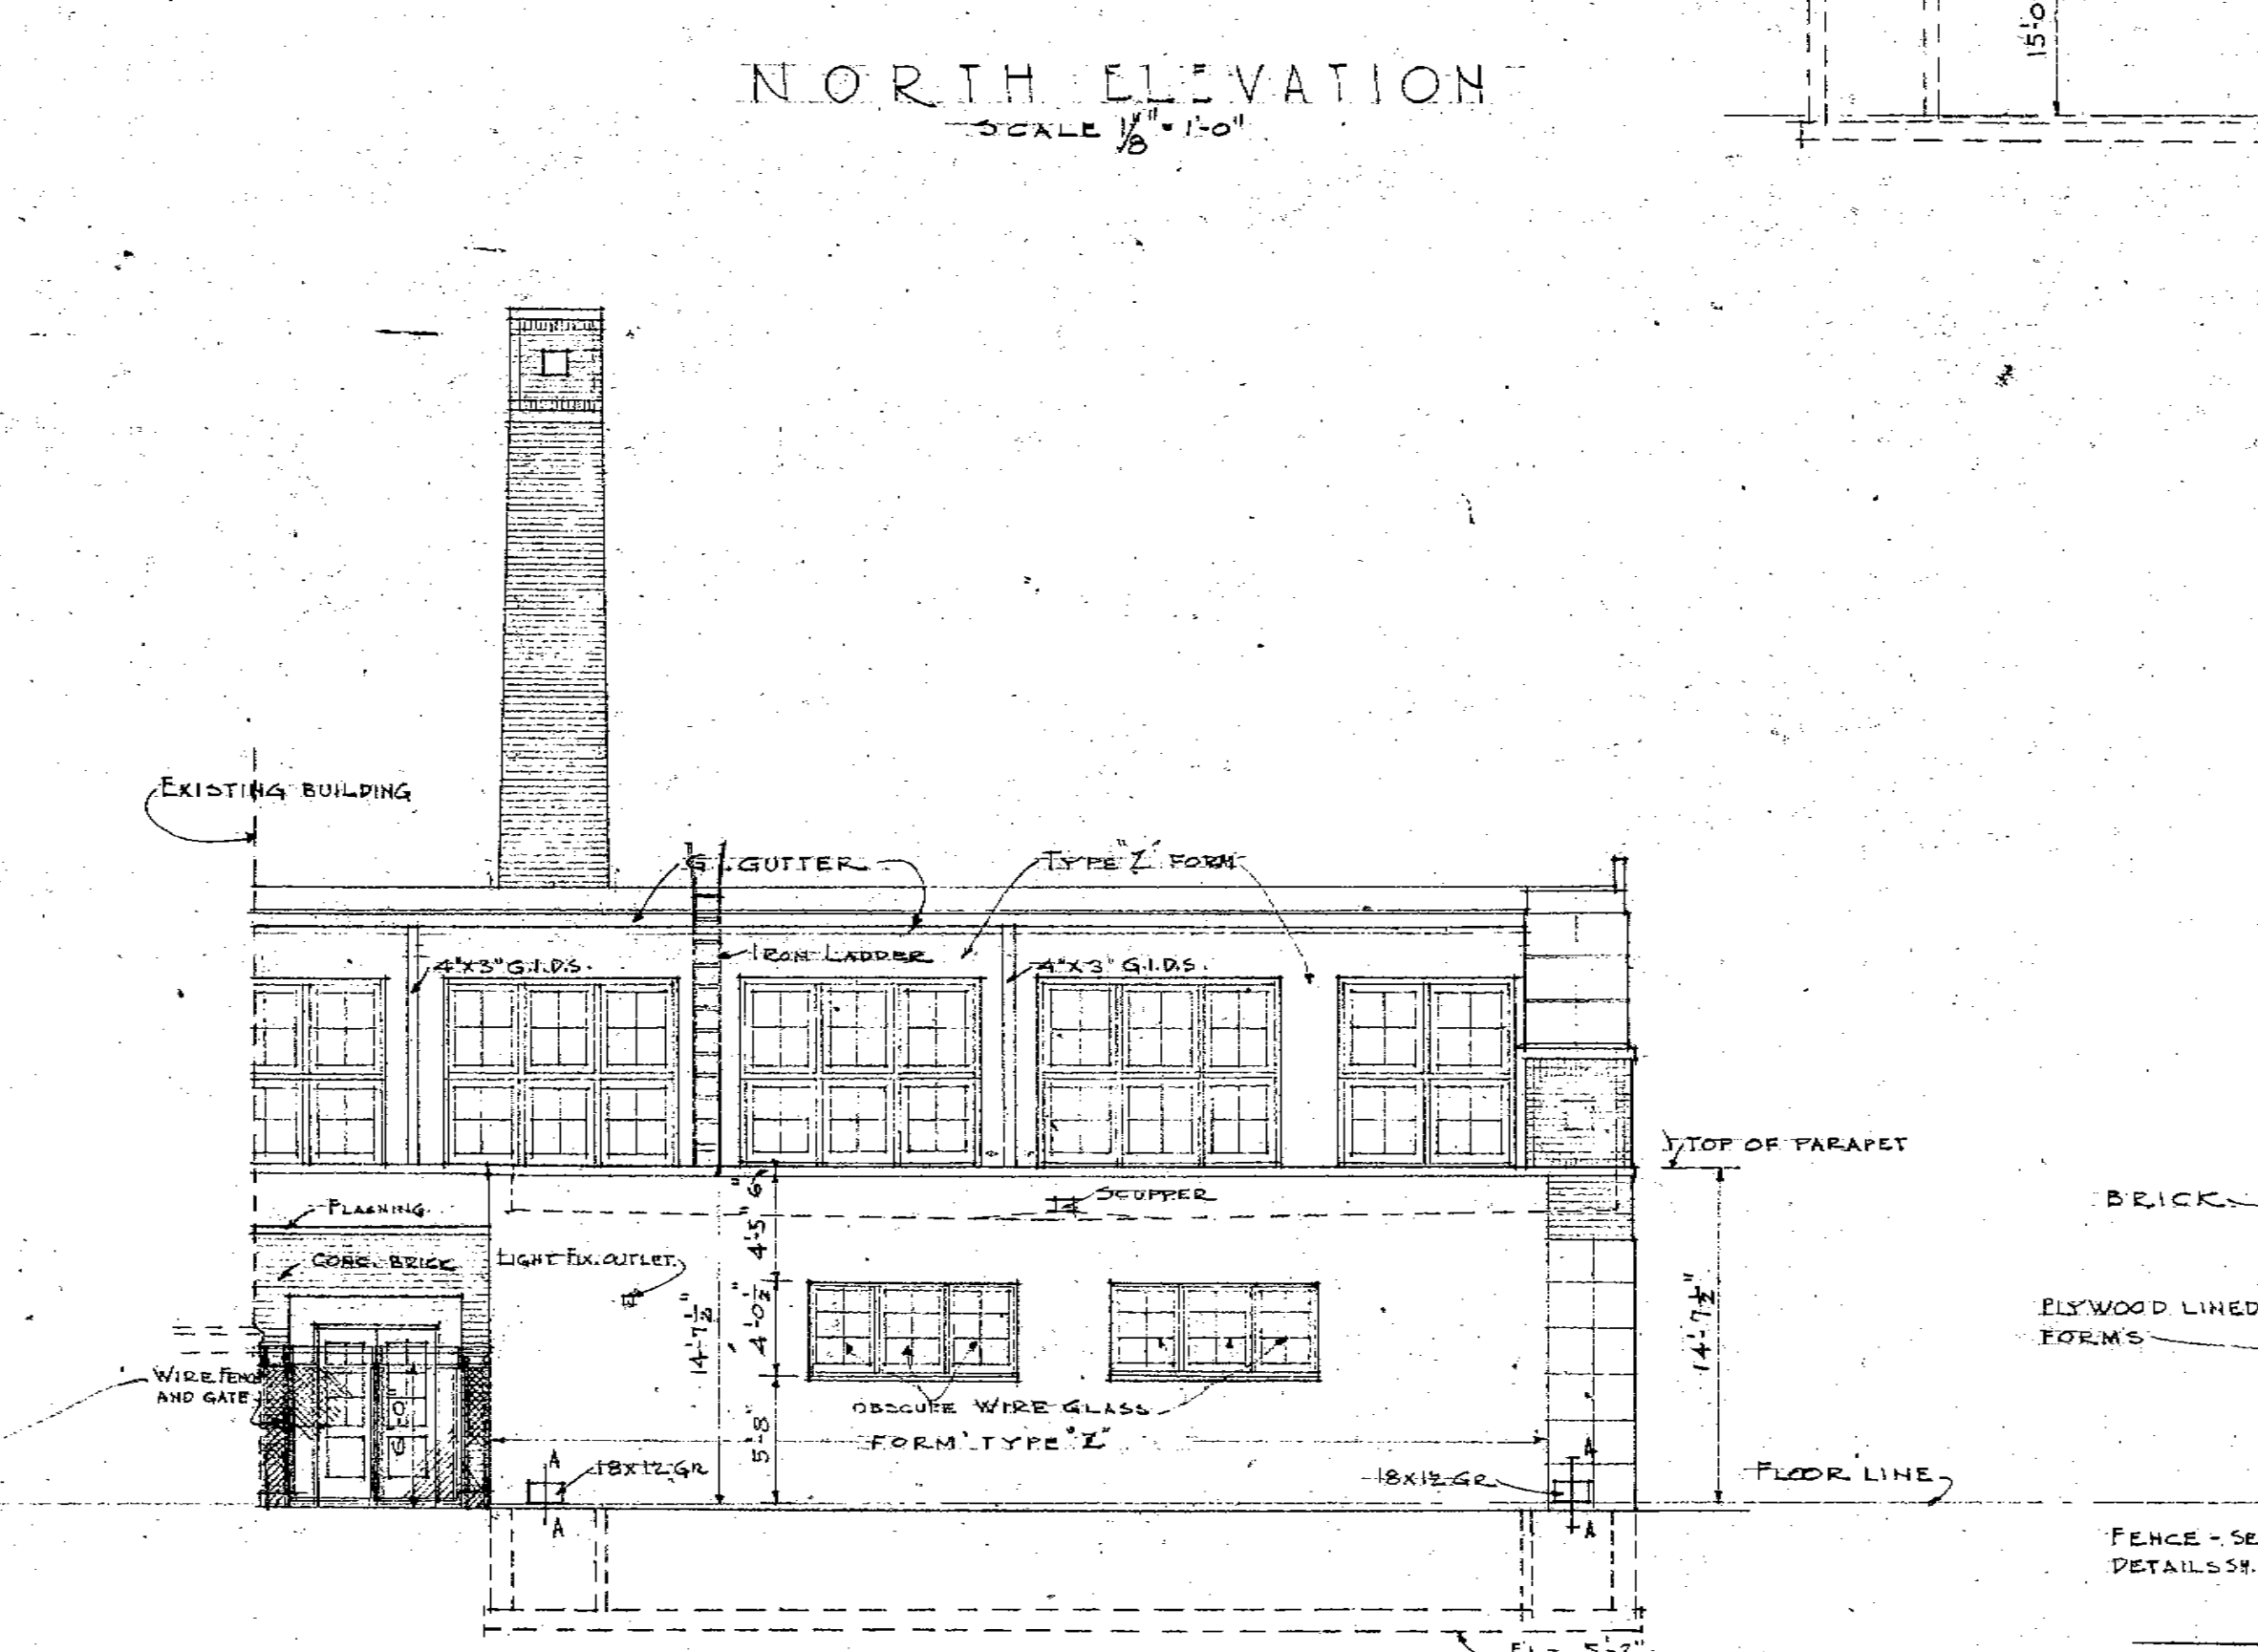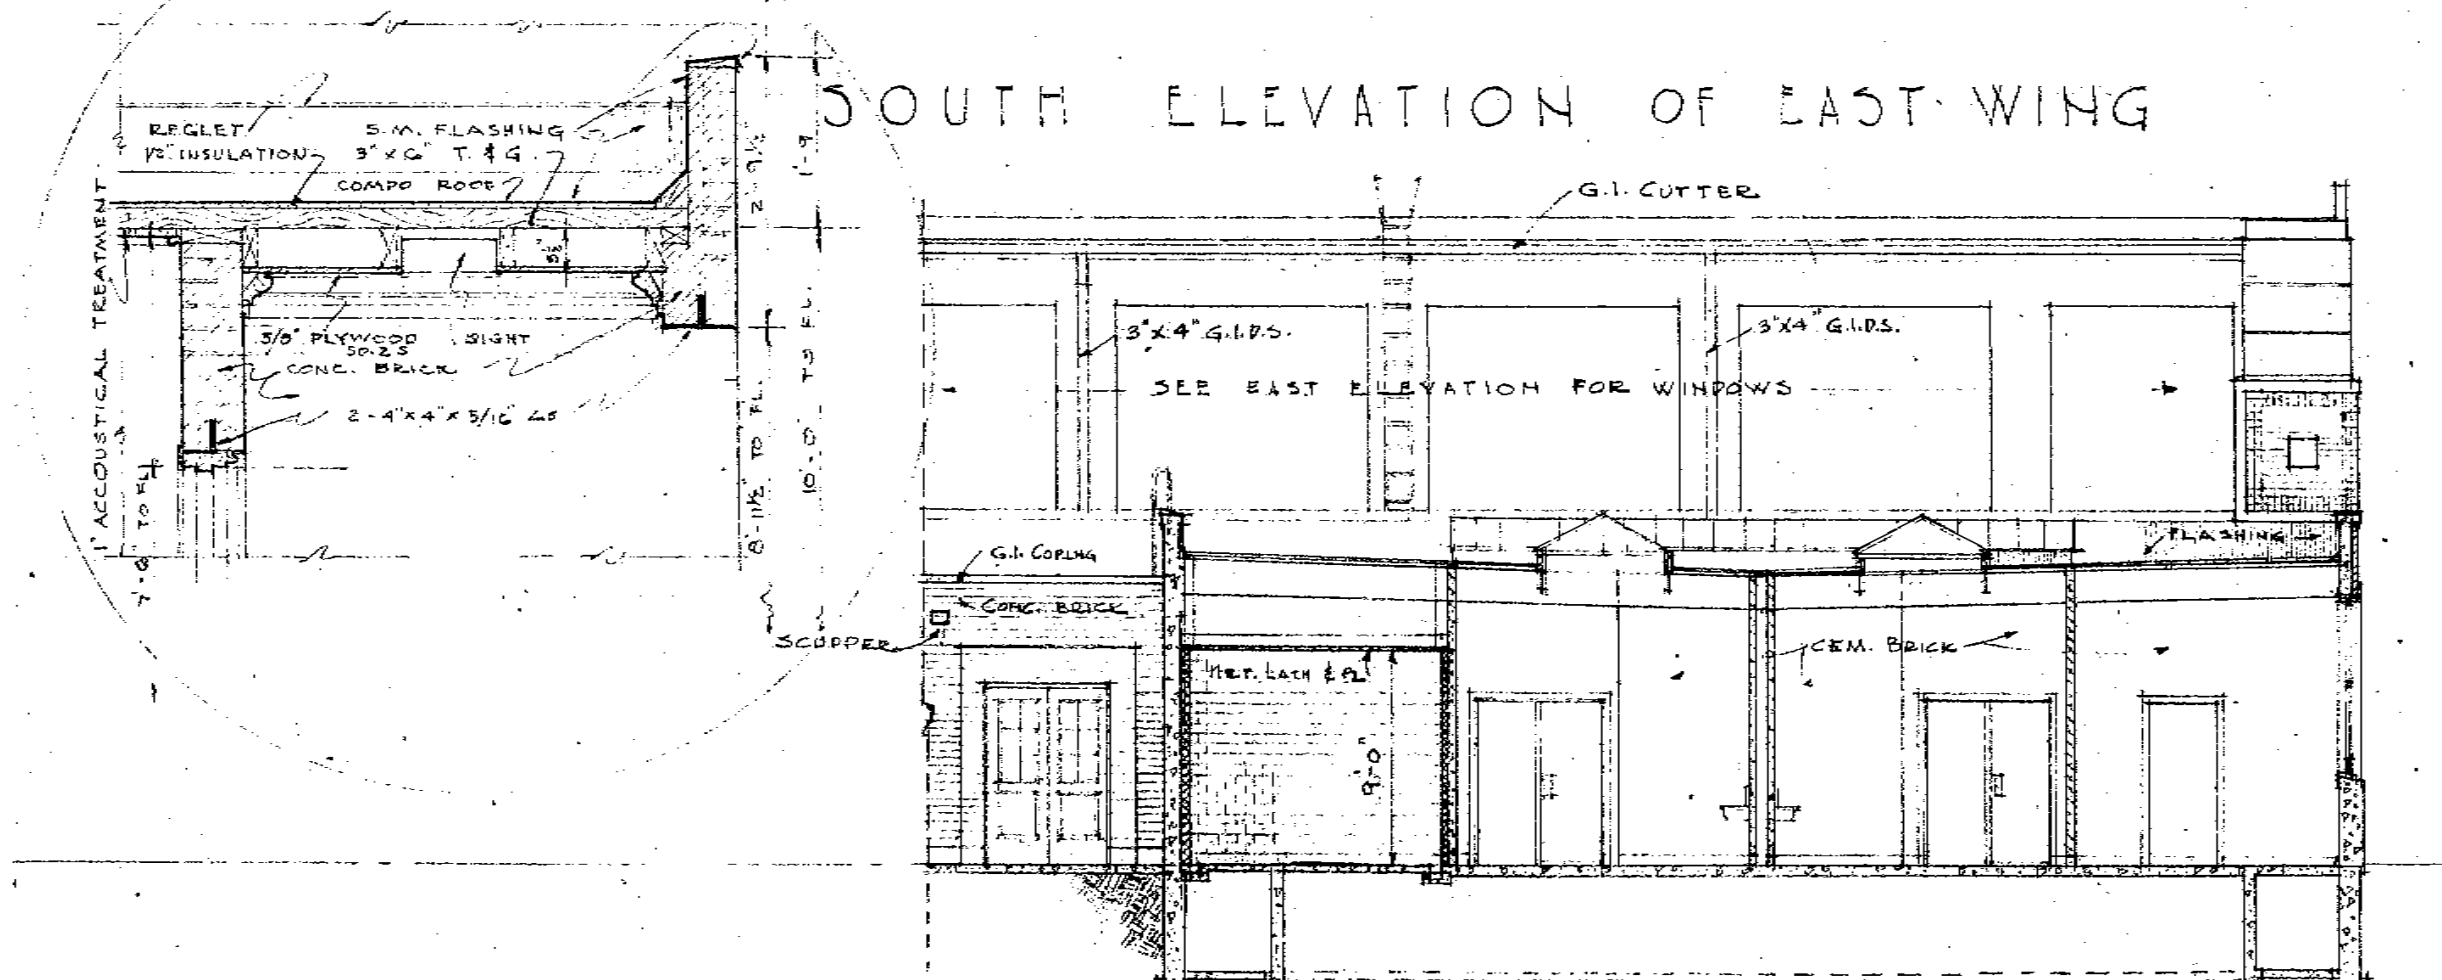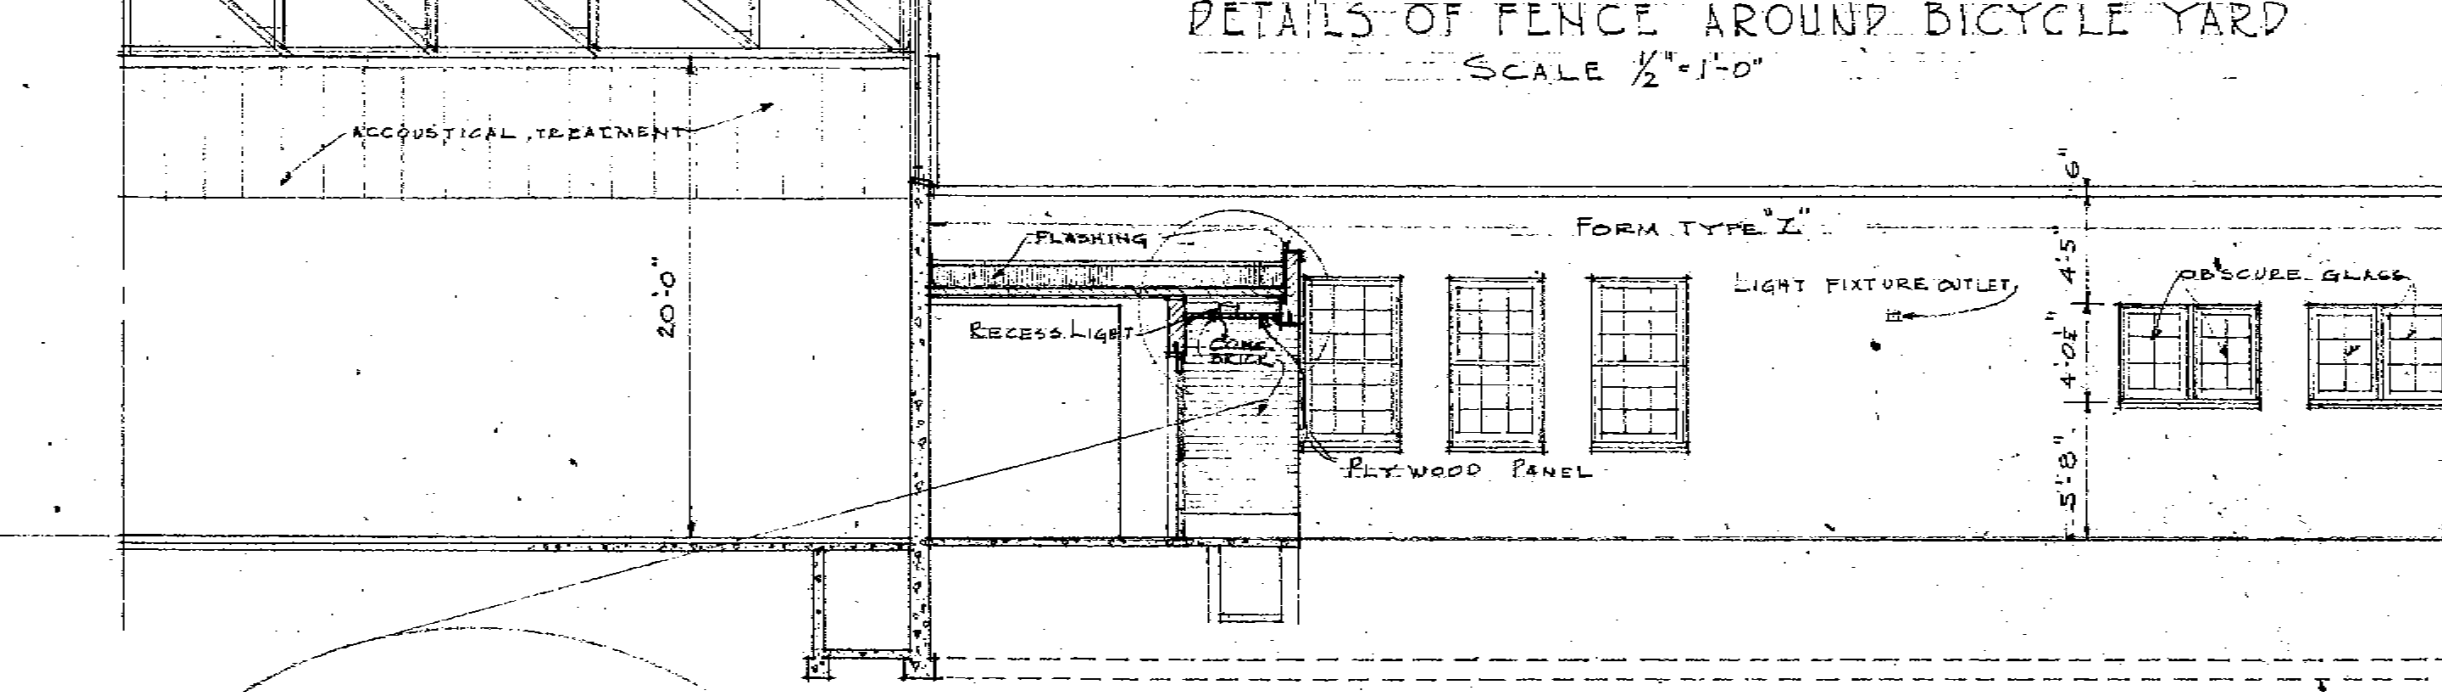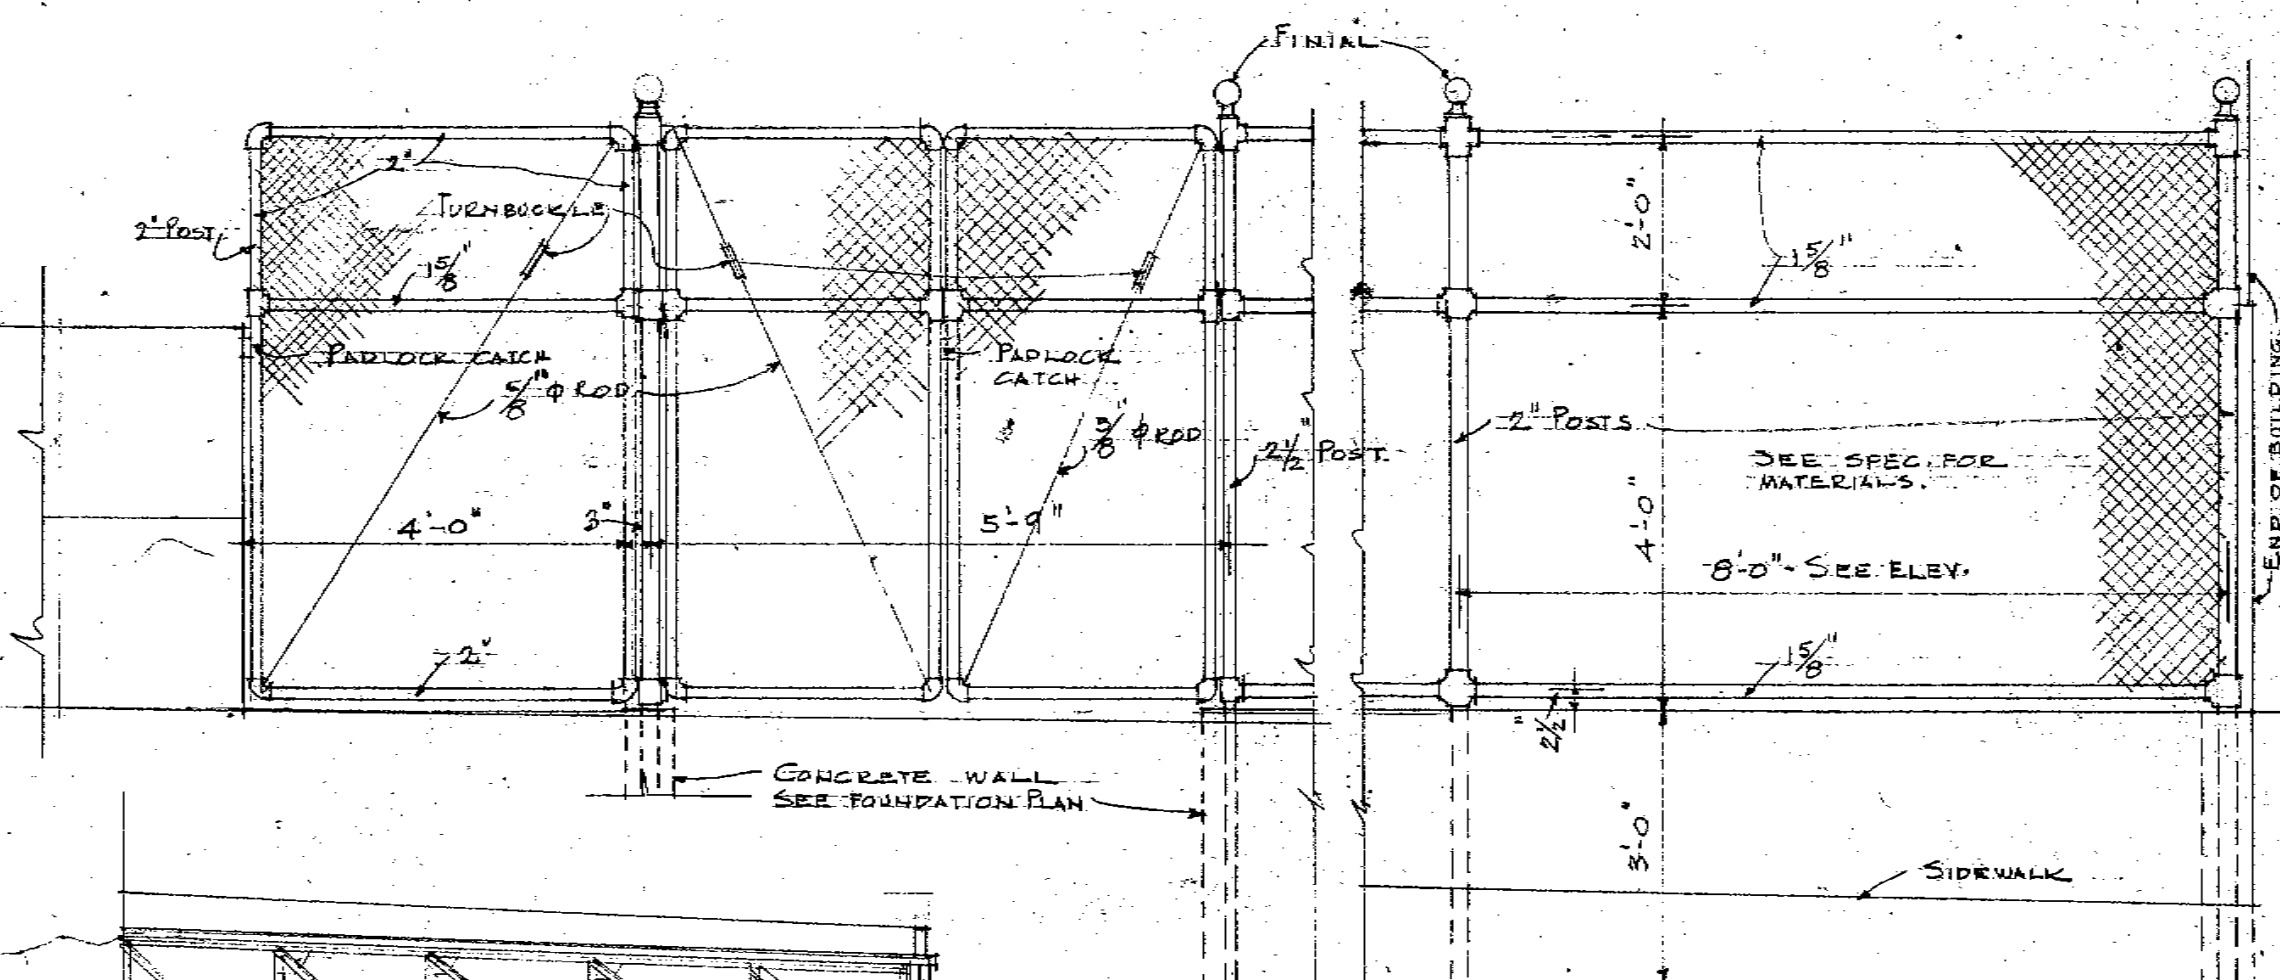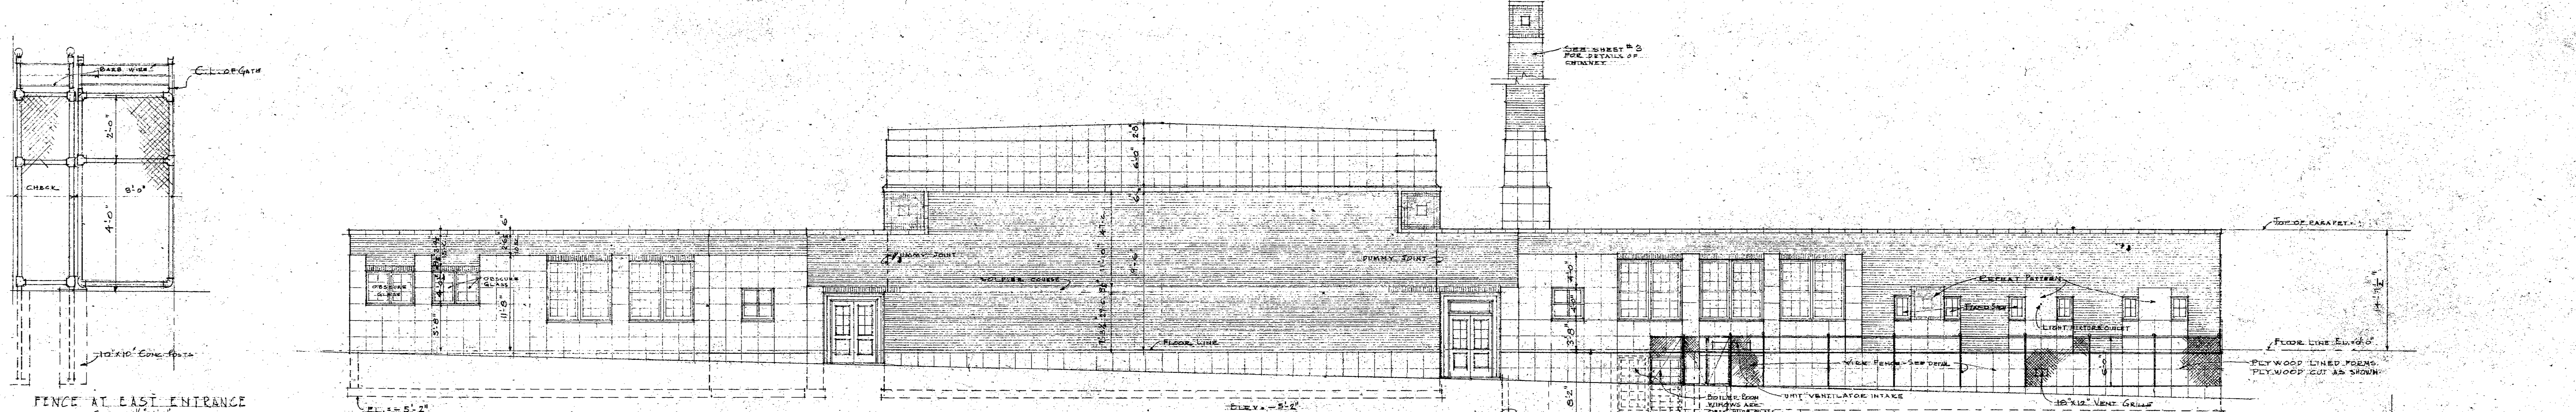











SEATTLE SCHOOL DIST. NO. 1
KING COUNTY, WASHINGTON
LONGFELLOW SCHOOL - ADDN.
ELEVATIONS & SECTIONS









DATE 7/27/40
REVISED
DRAWN BY E.E.S.
CHECKED BY S.H.H.

NARAMORE & BRADY
ARCHITECTS
CENTRAL BUILDING
SEATTLE, WASH.
E.E.S. APPROVED
S.H.H. CHECKED


SHEET NO. 5
DATE 7/26/40
SUGGESTED MANAGER: SEATTLE SCHOOL DIST. NO. 1

REGISTERED ARCHITECT
HARRISON & GRADY
SEATTLE
STATE OF WASHINGTON

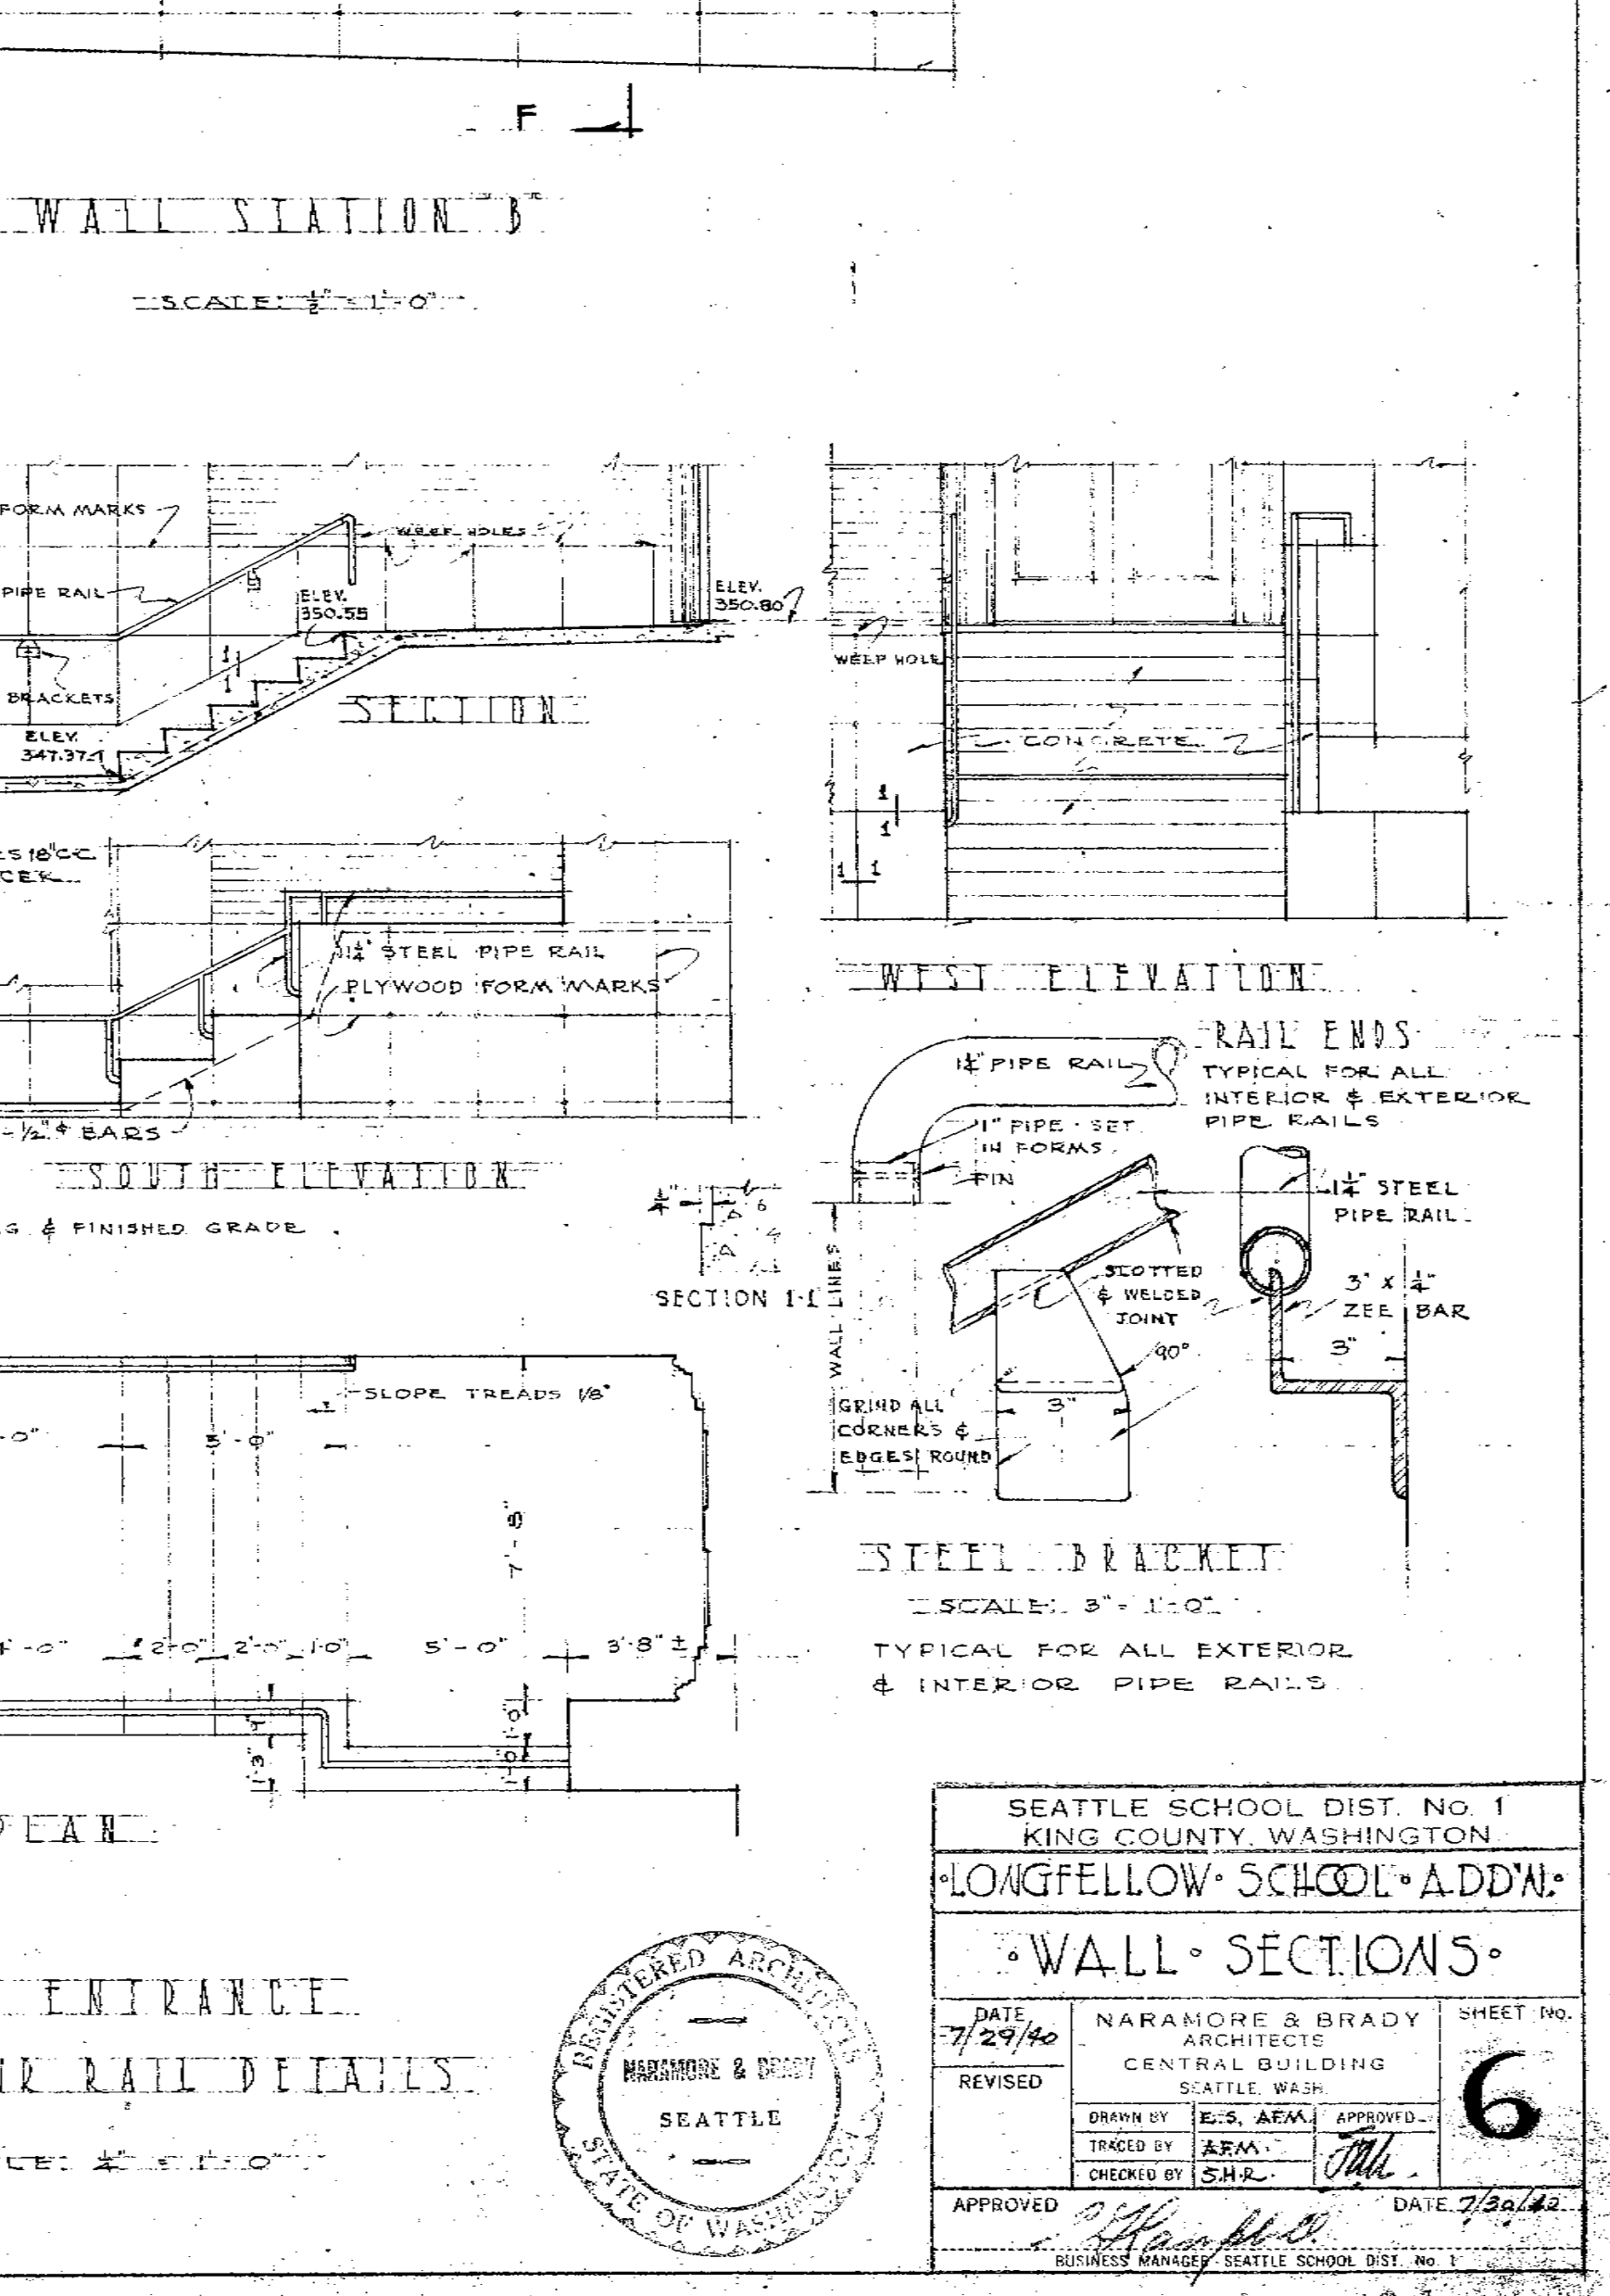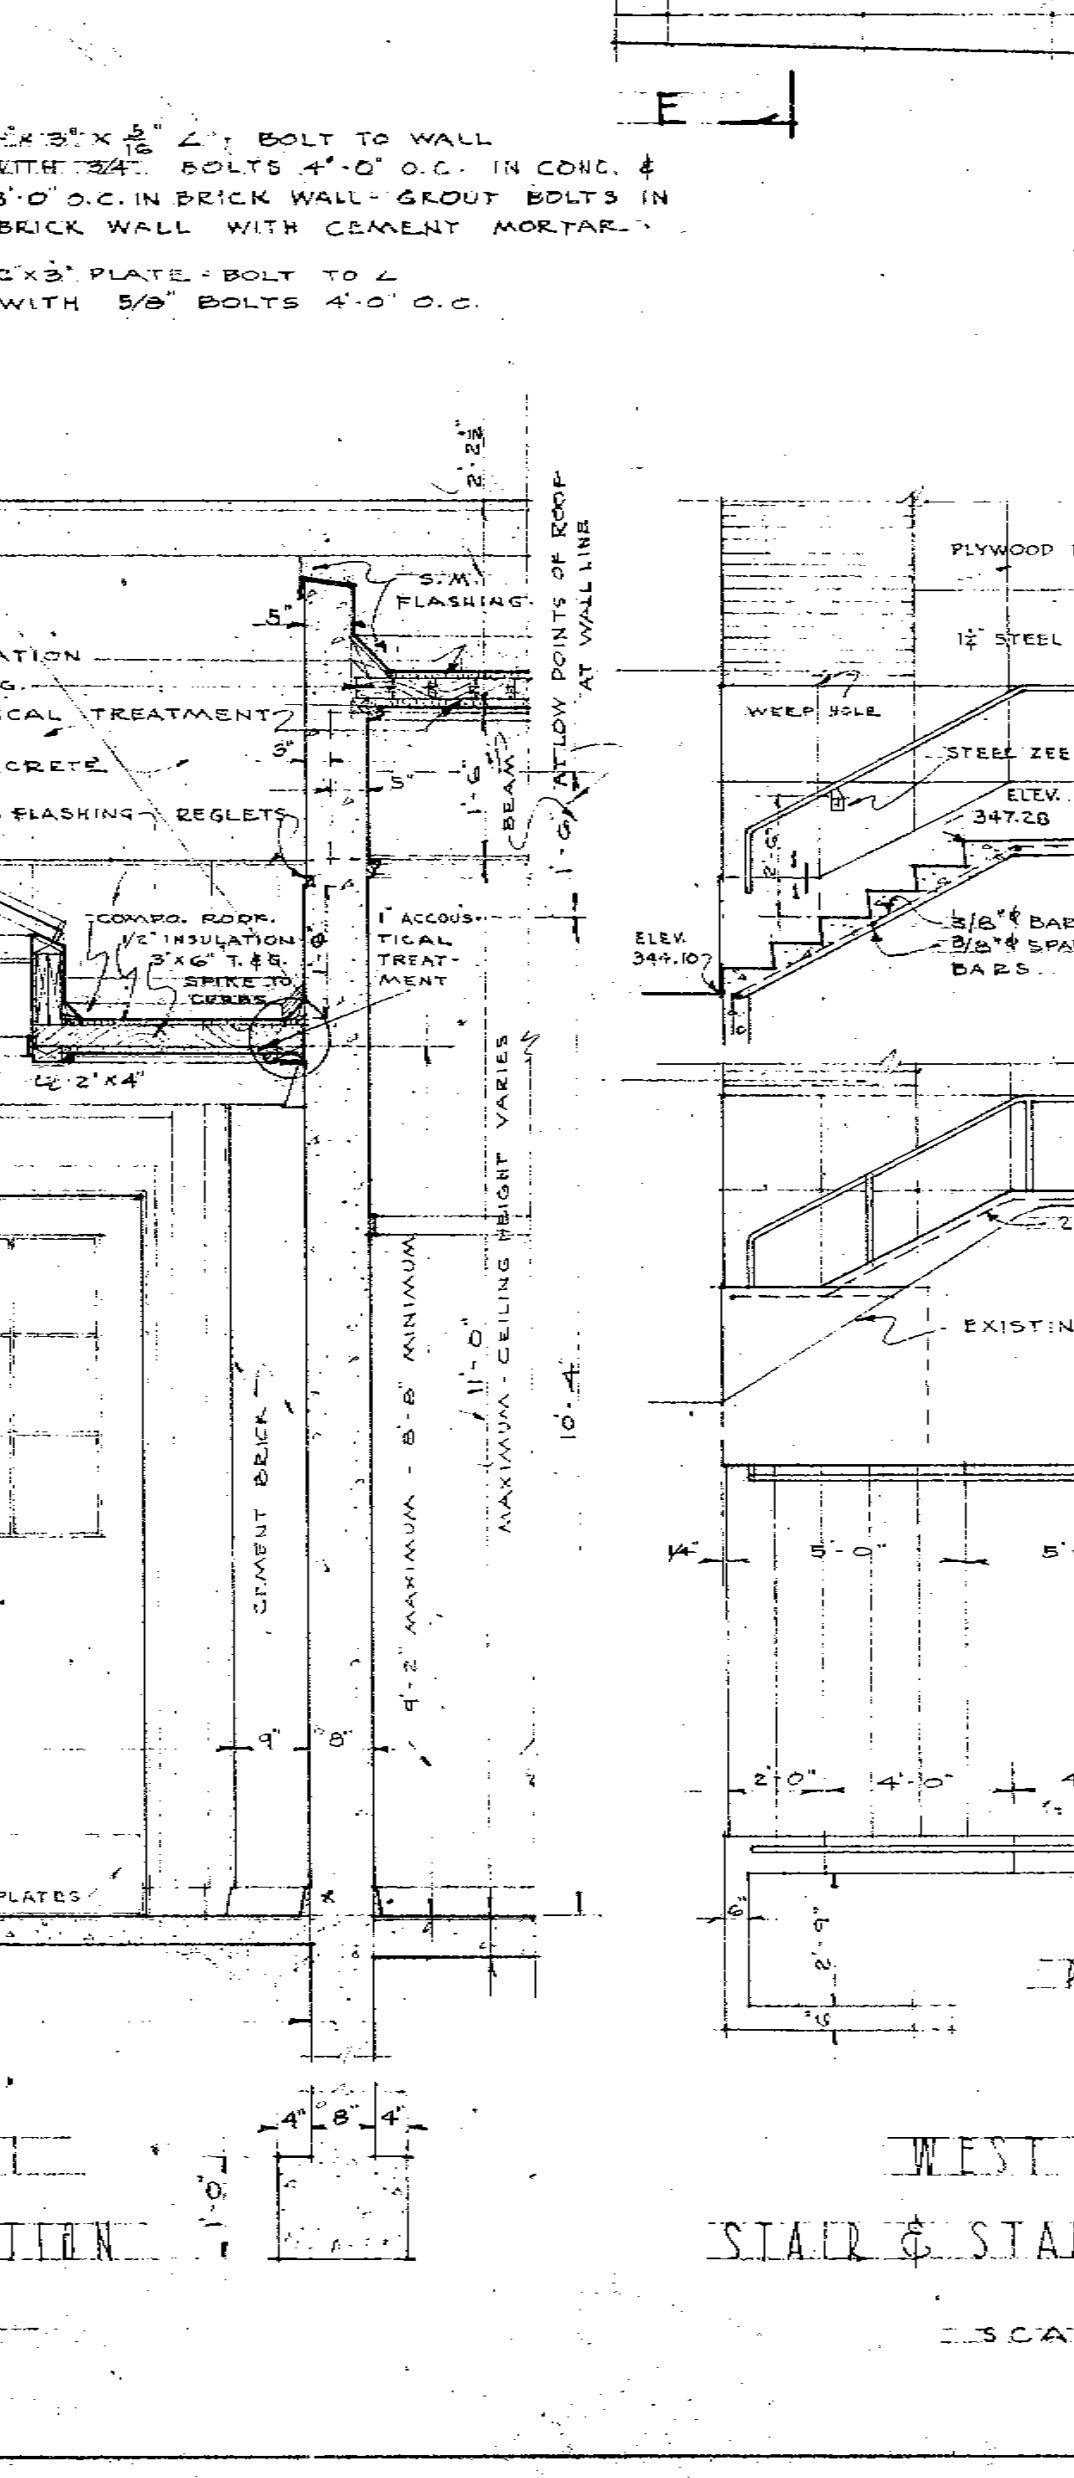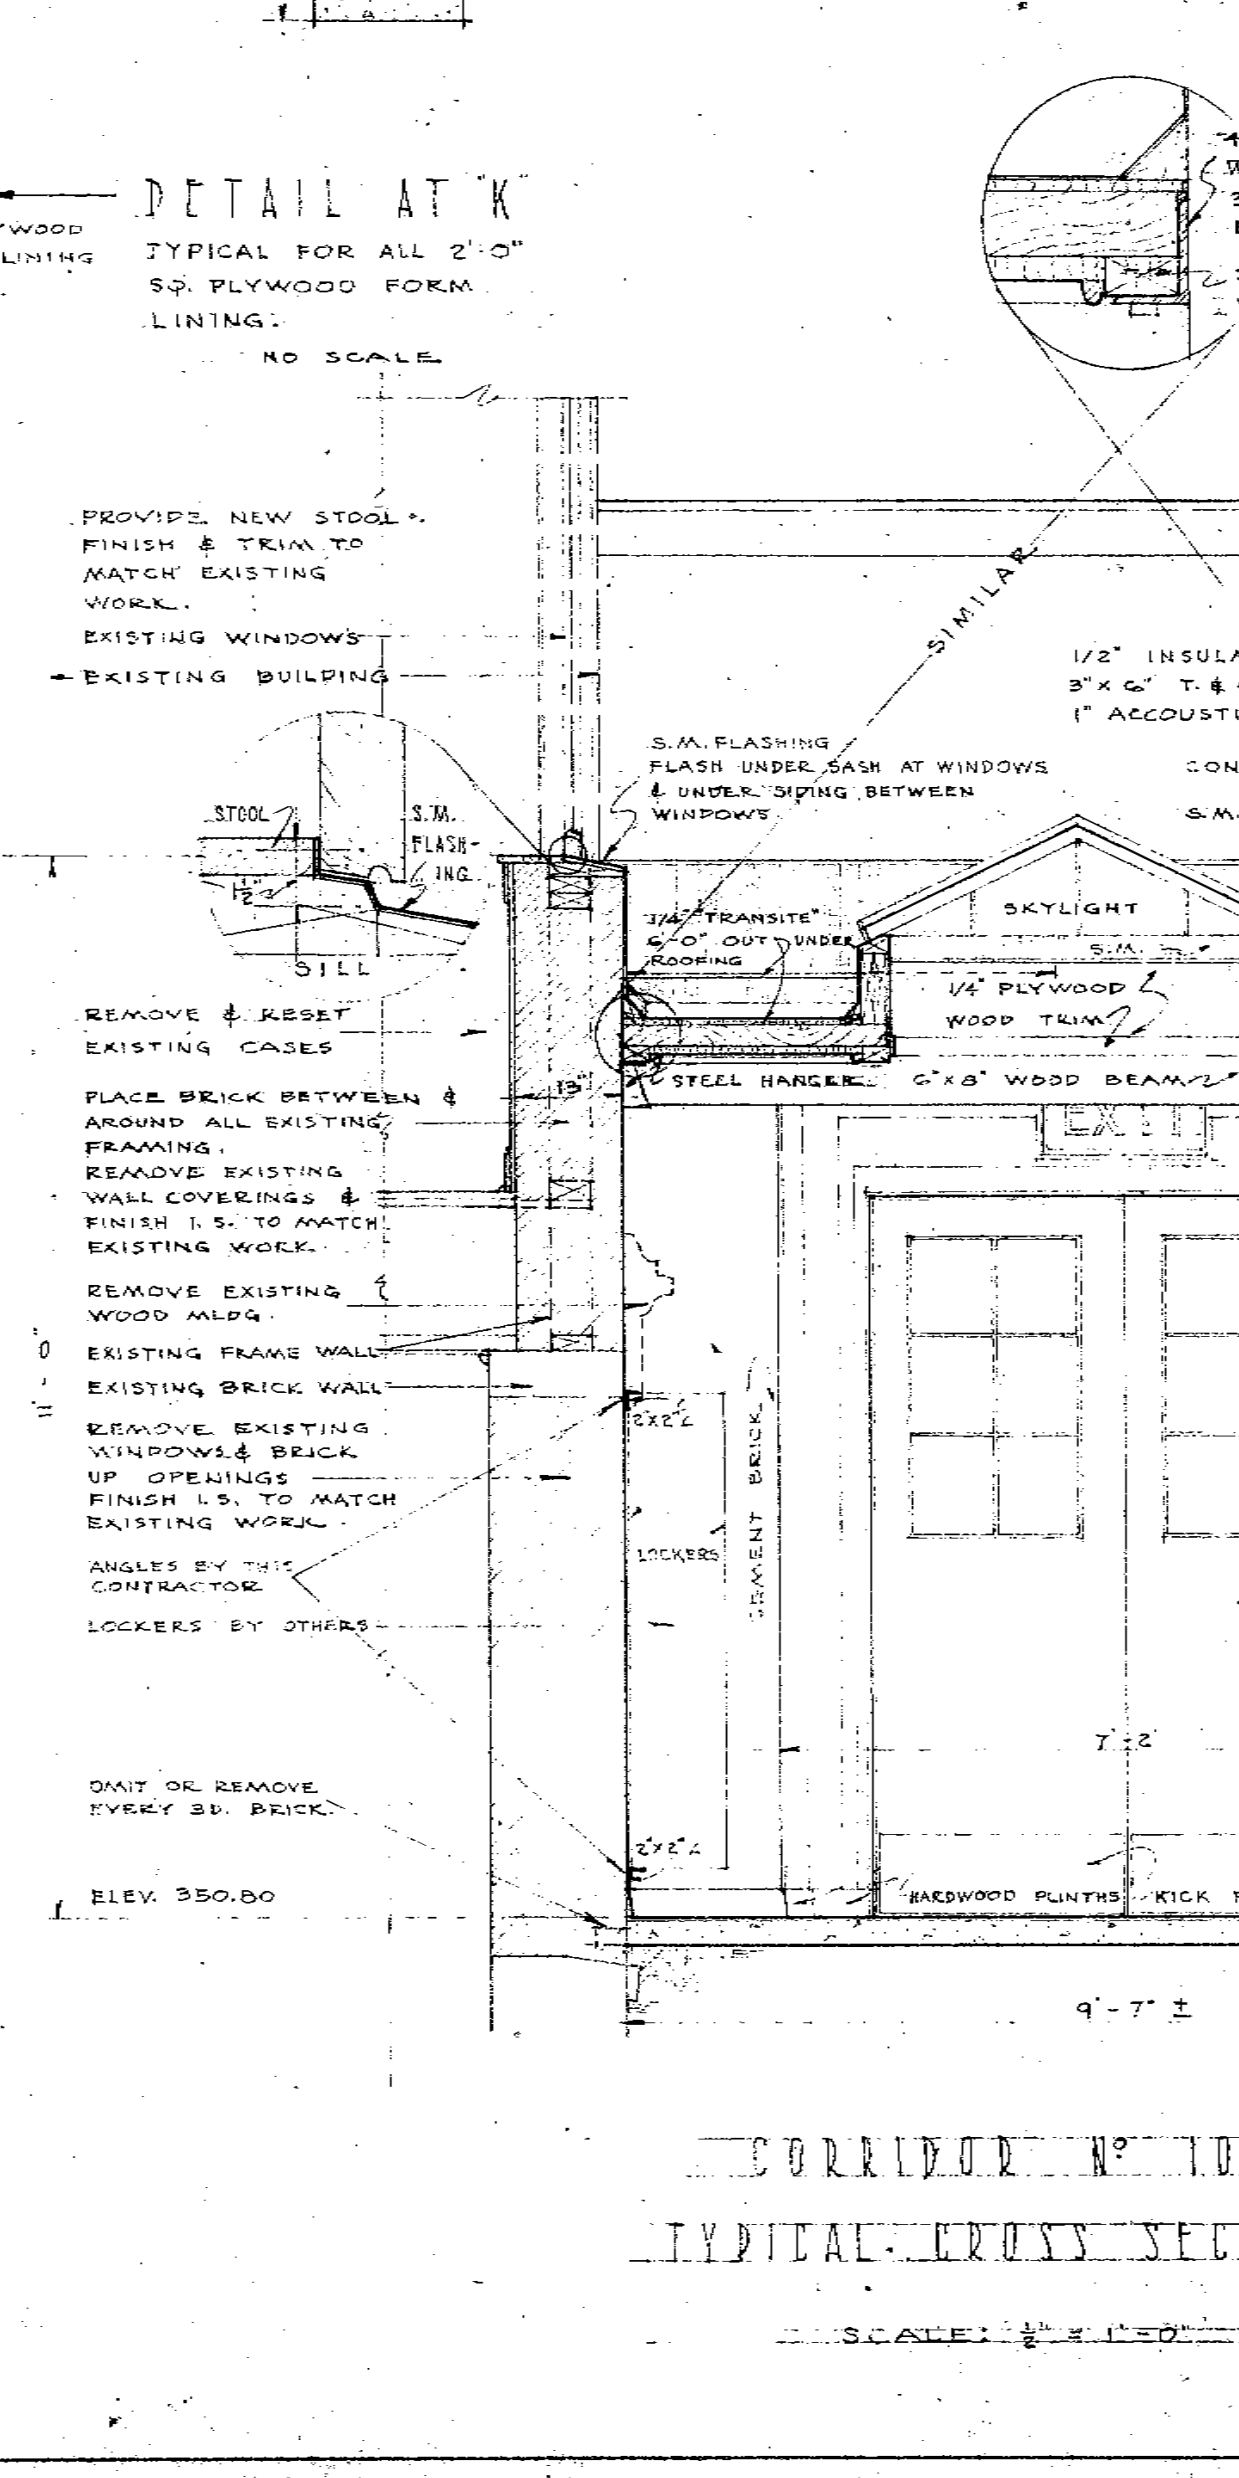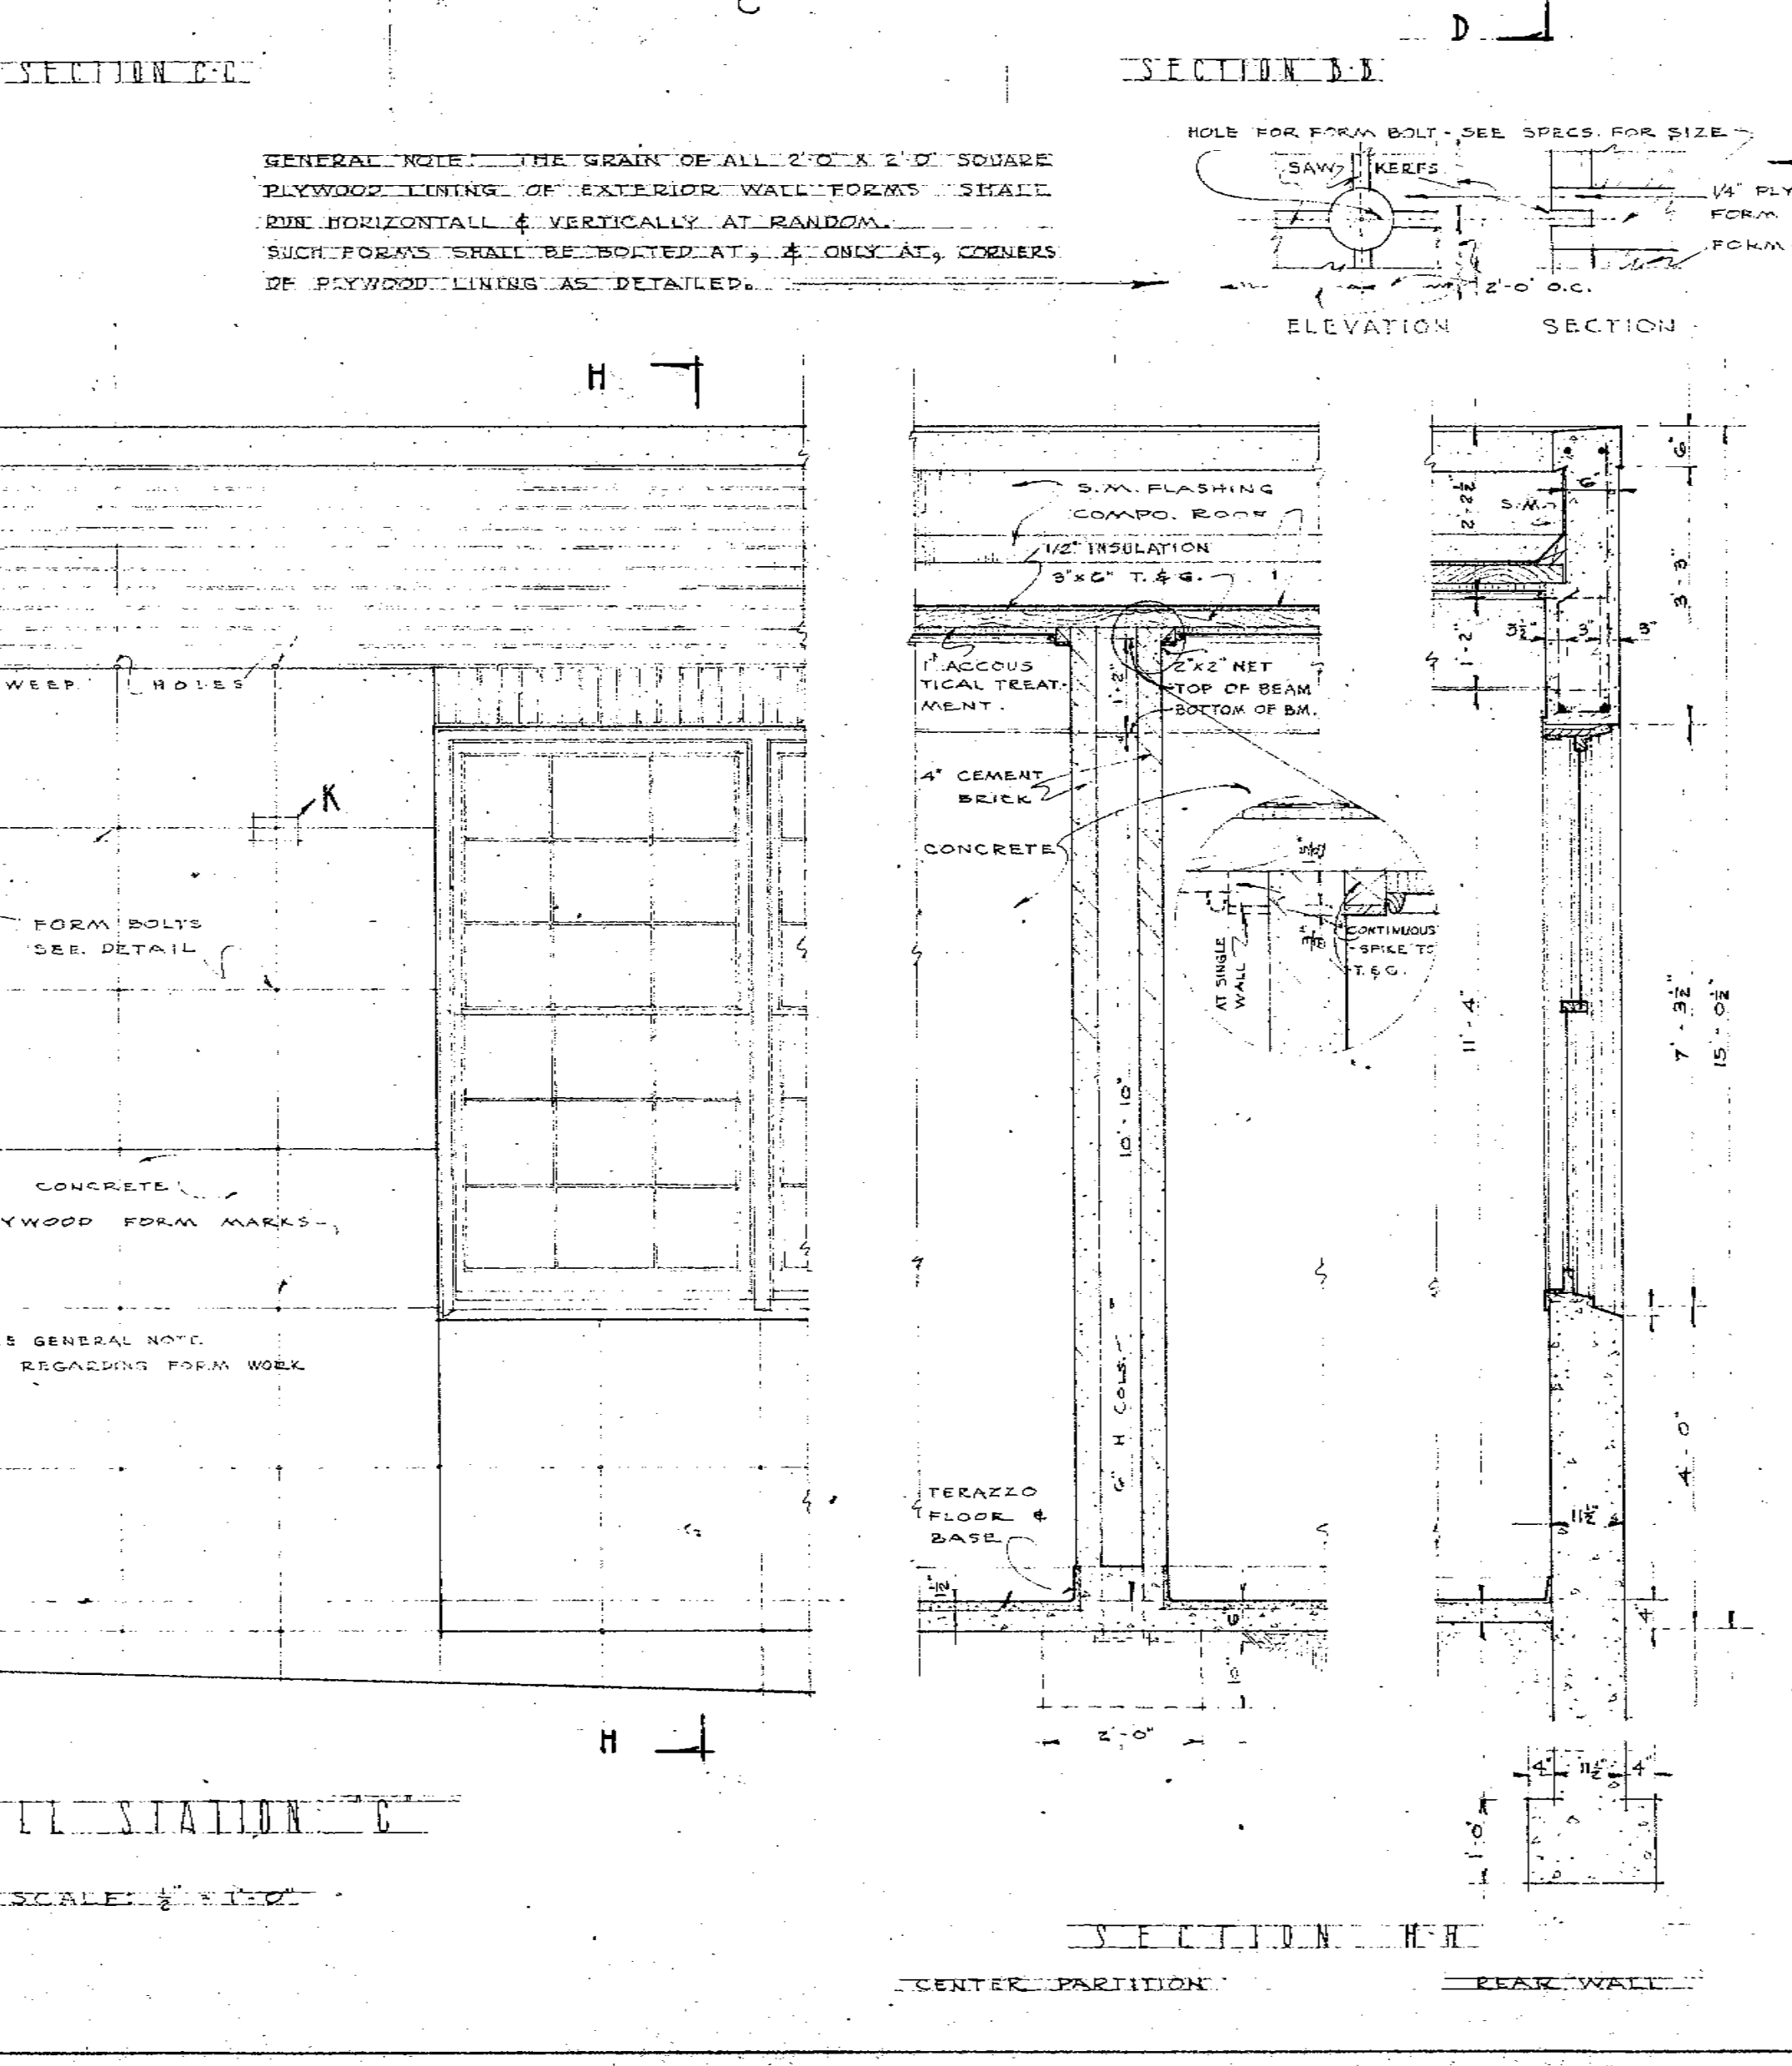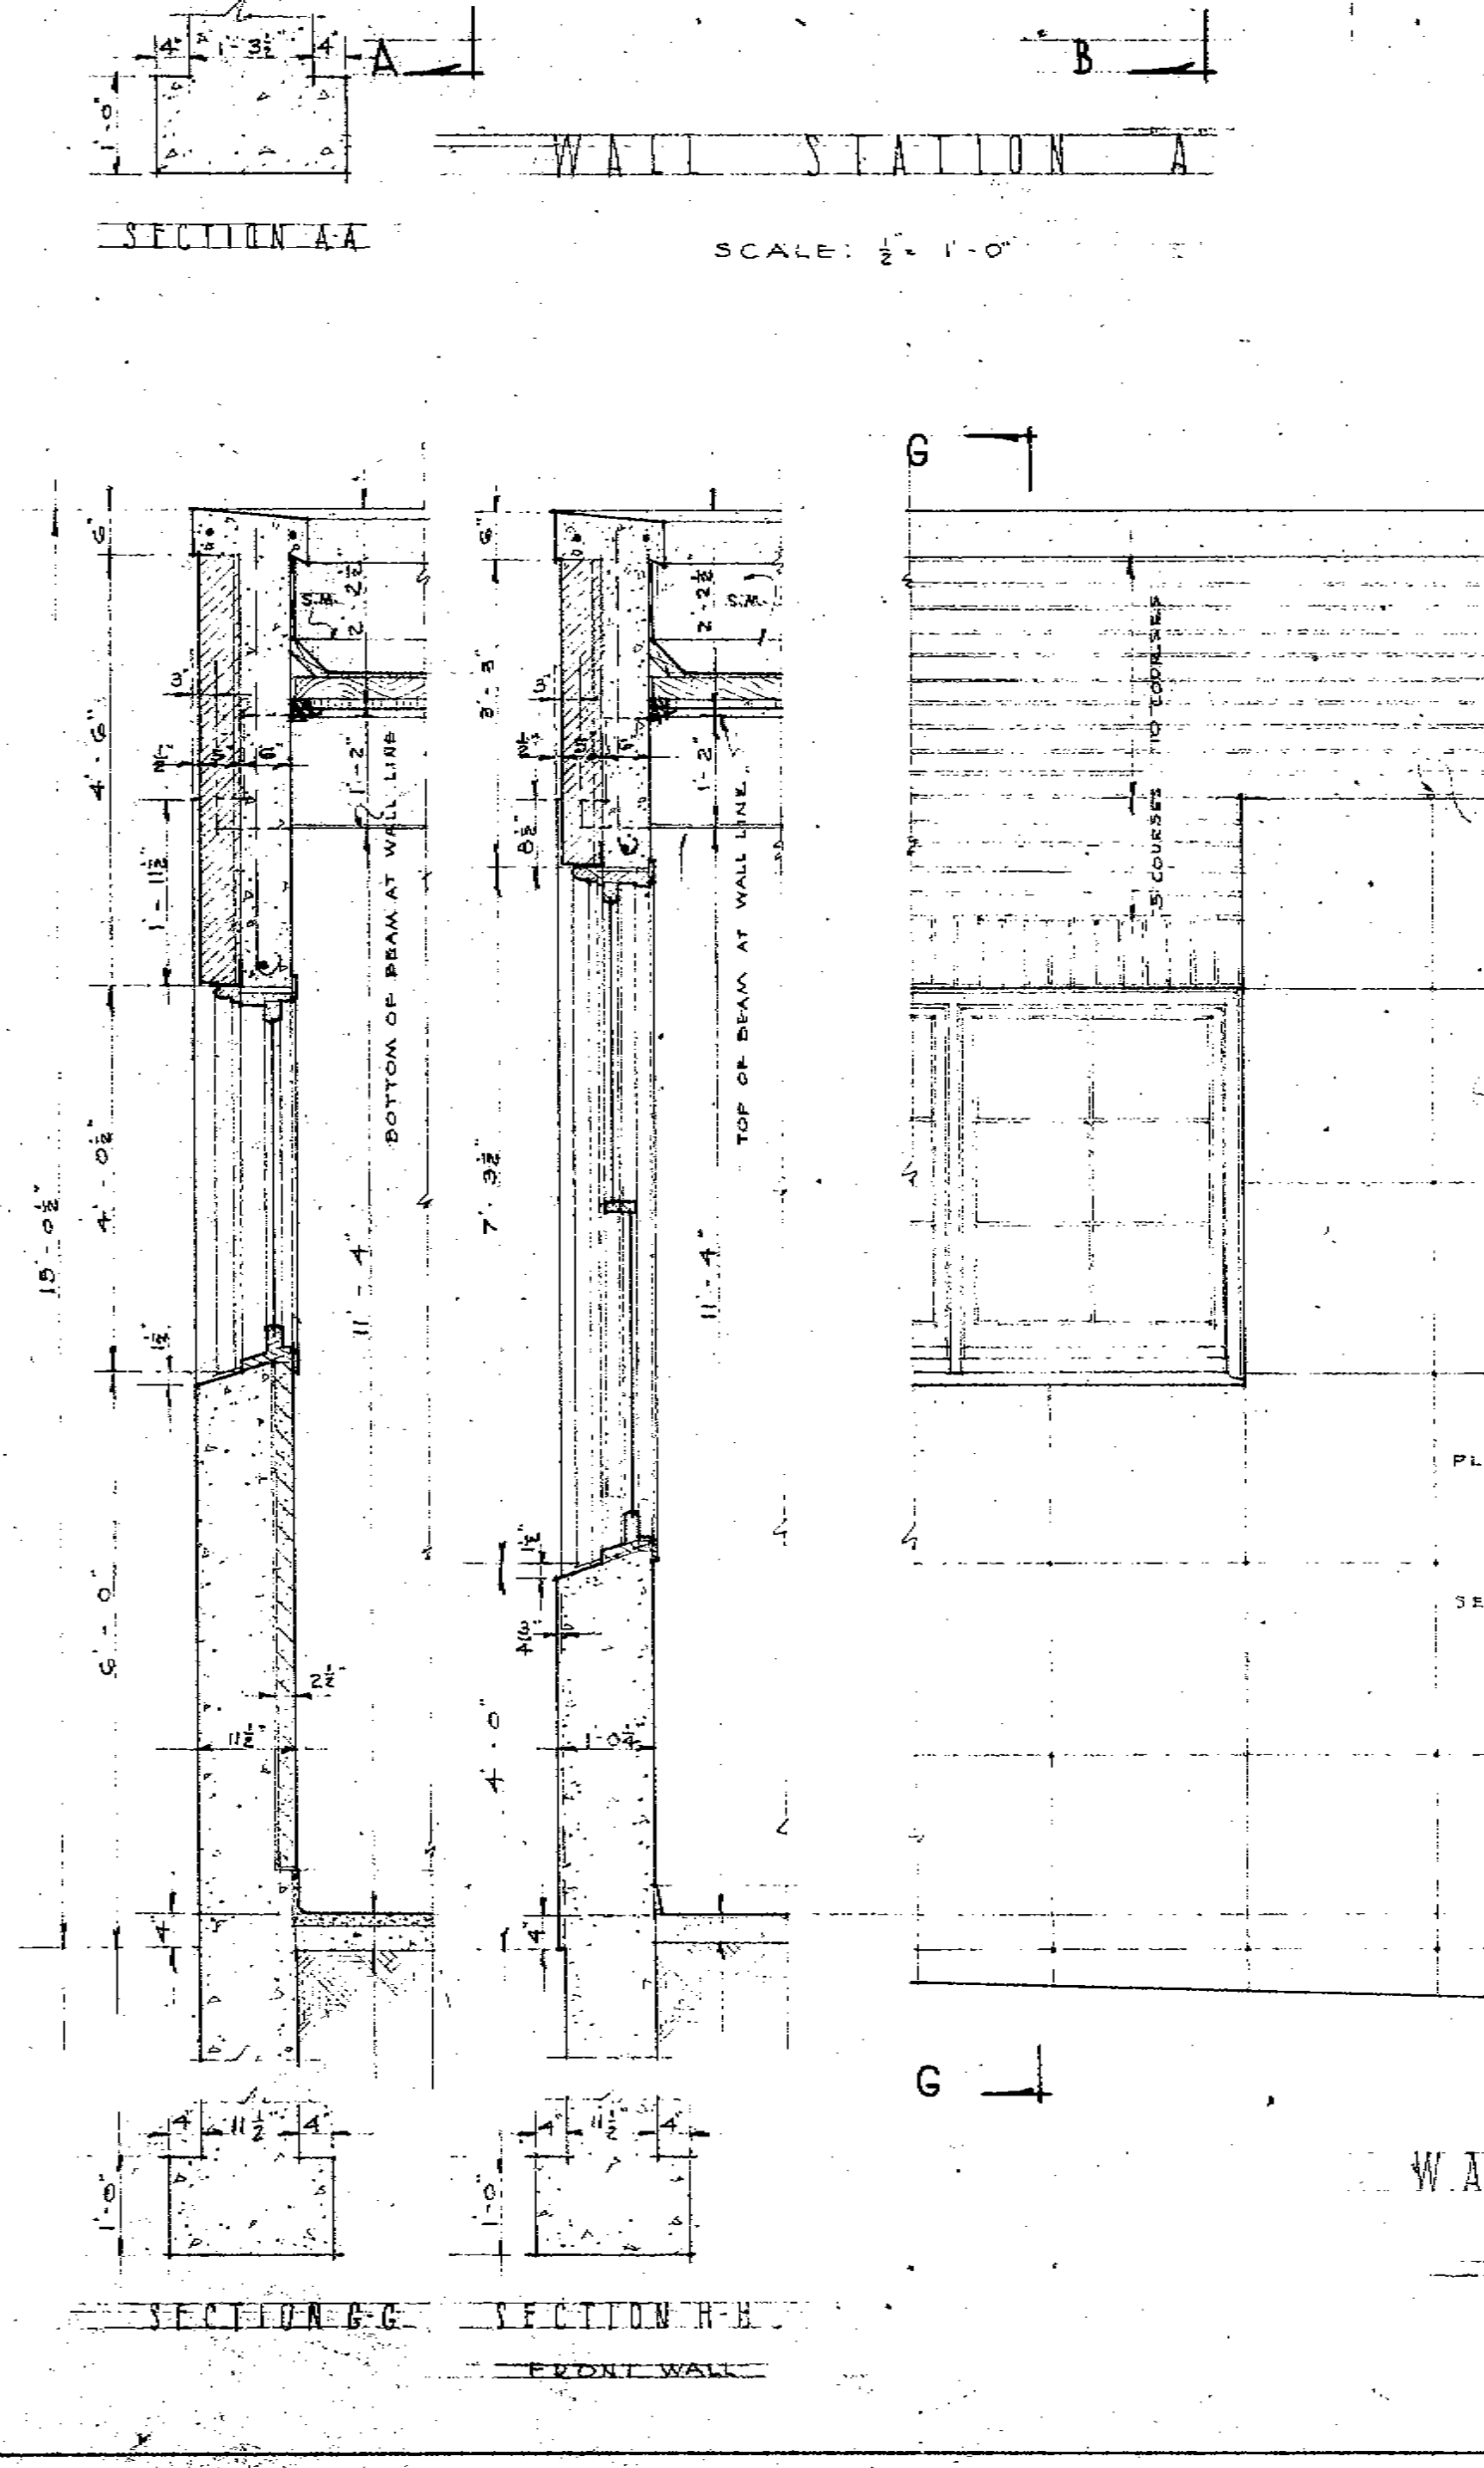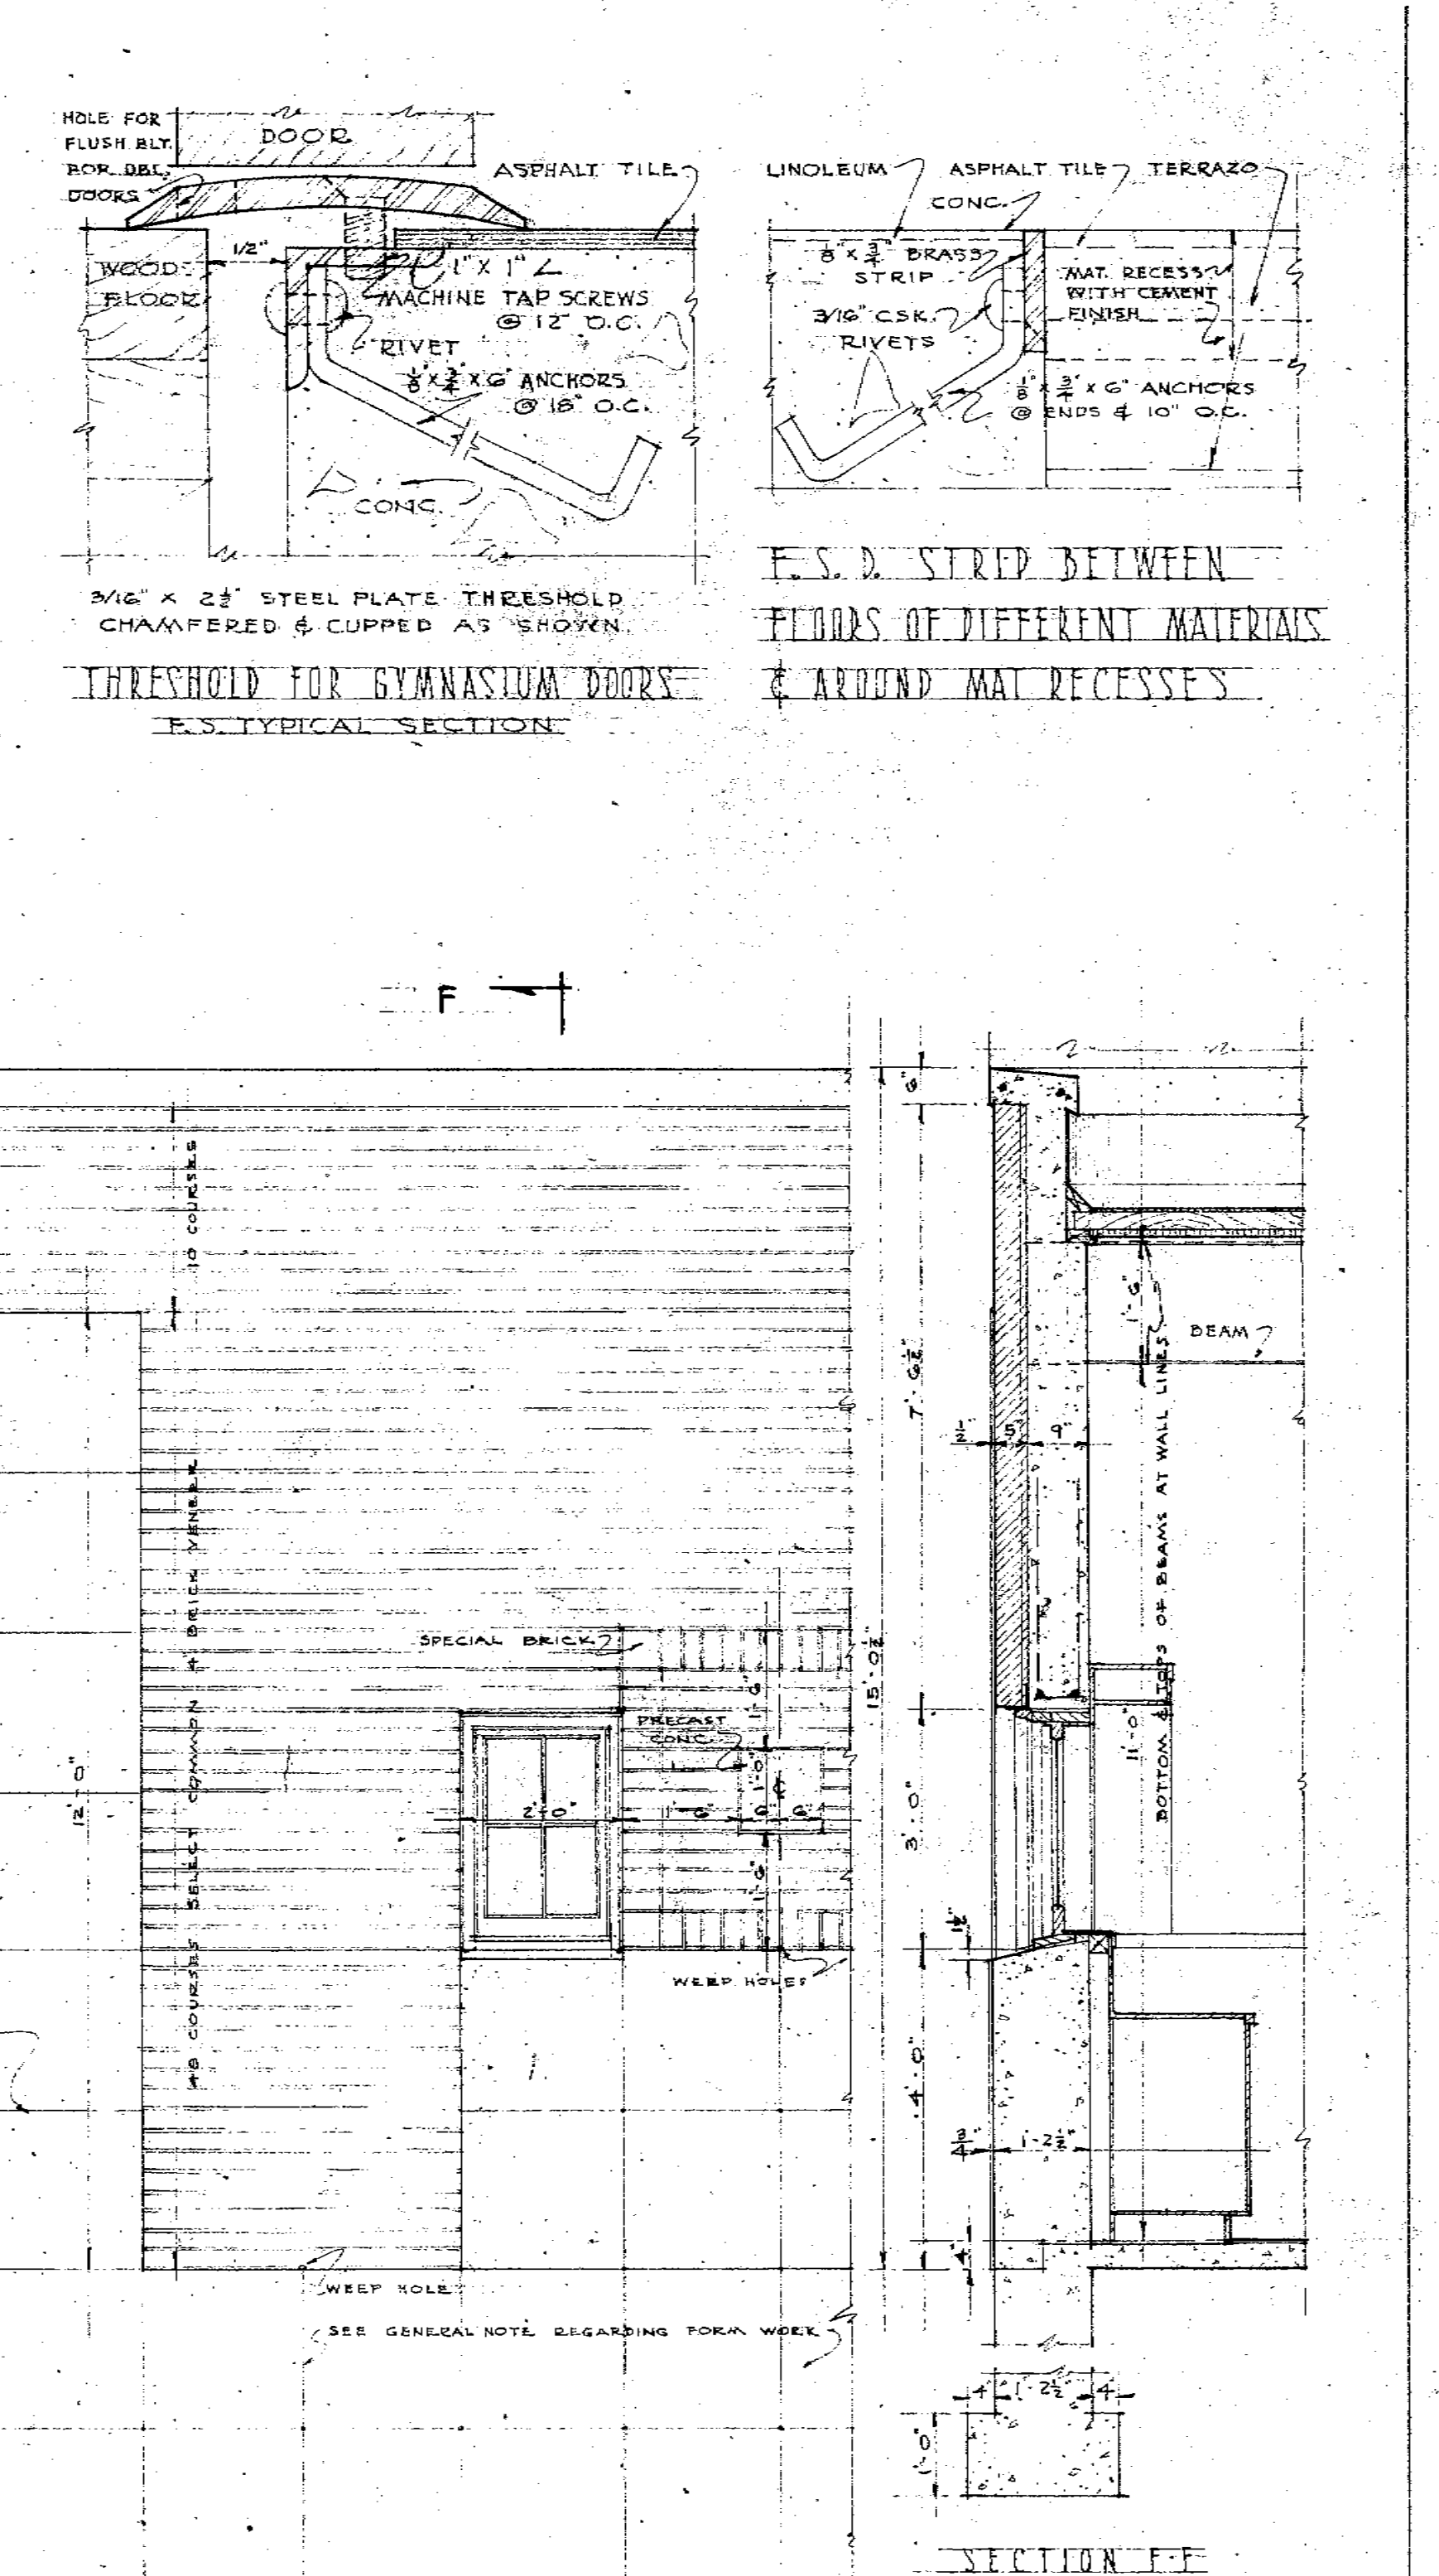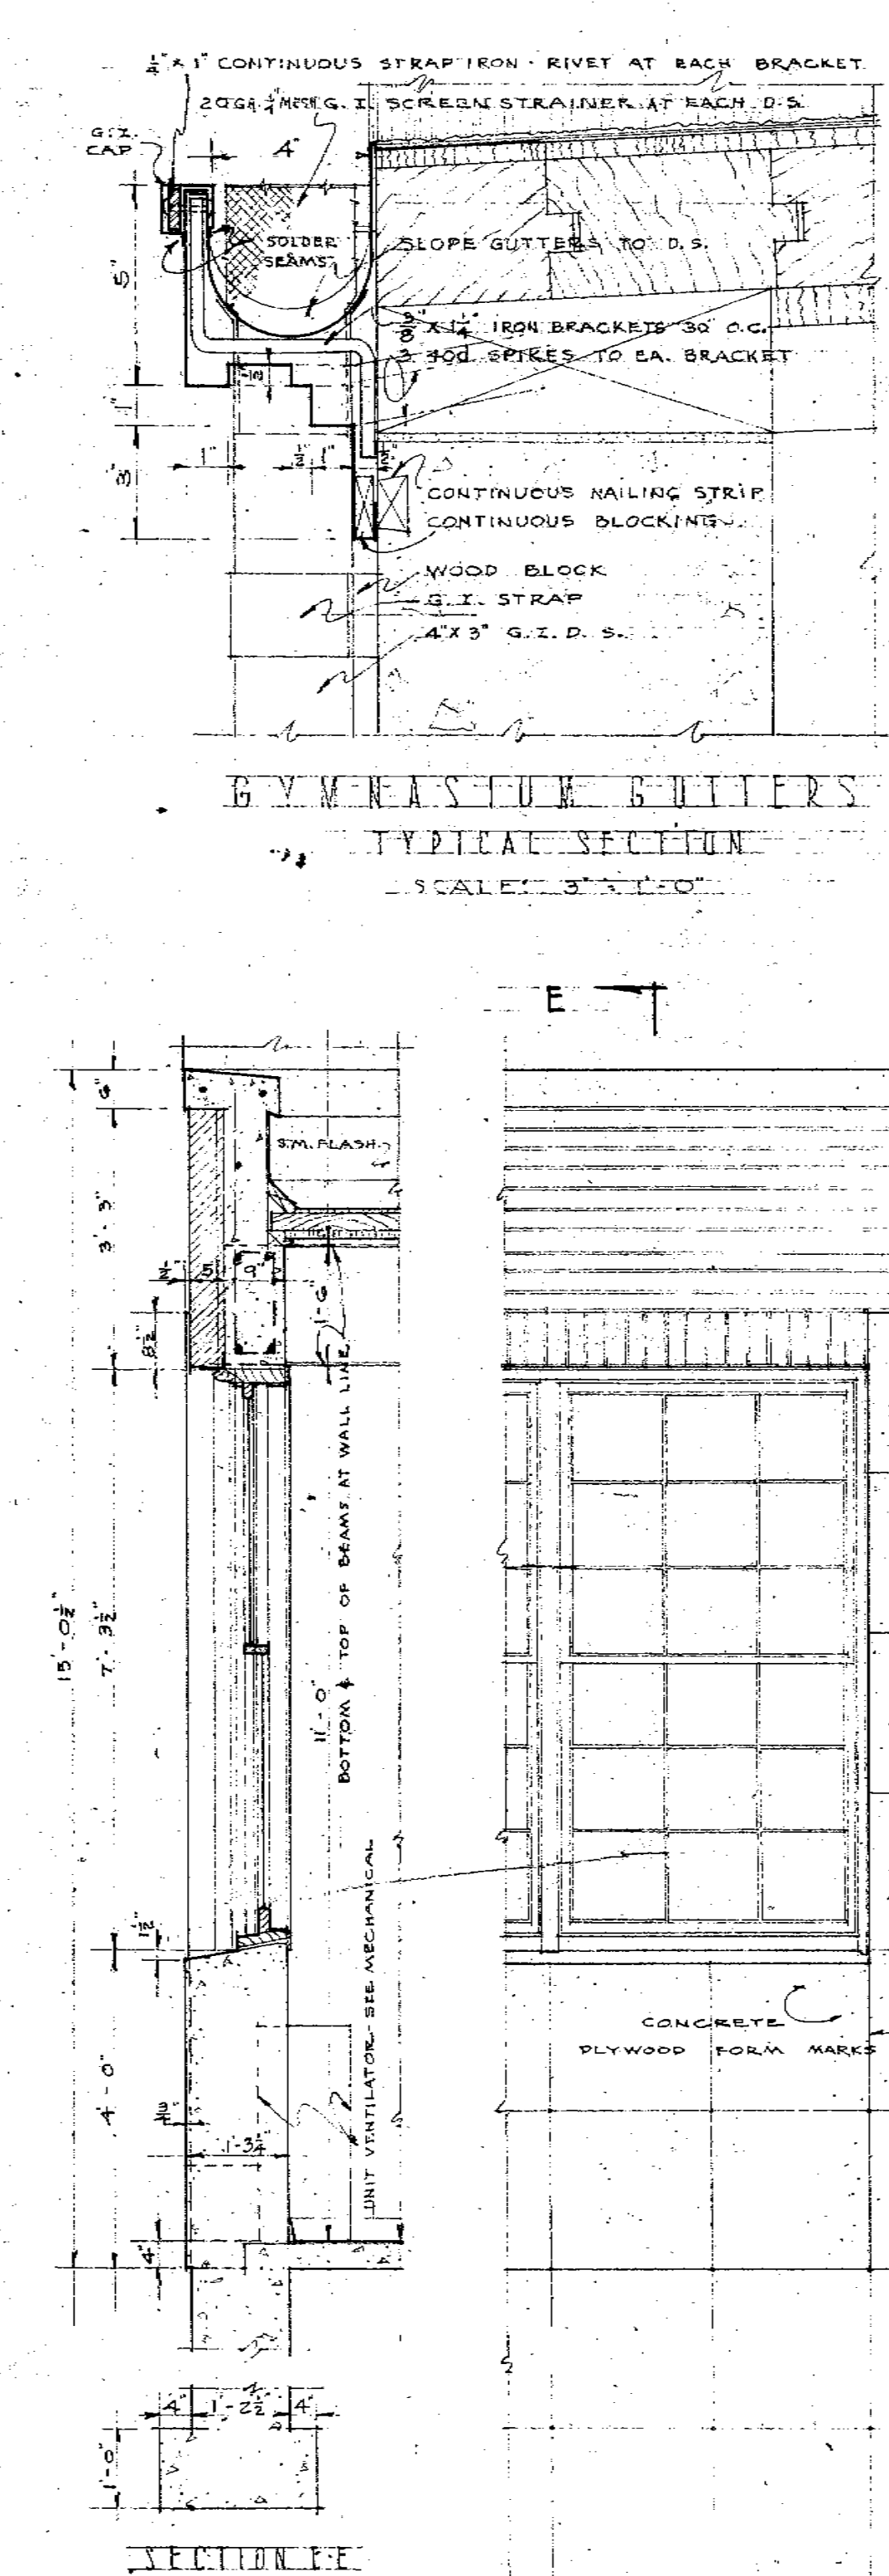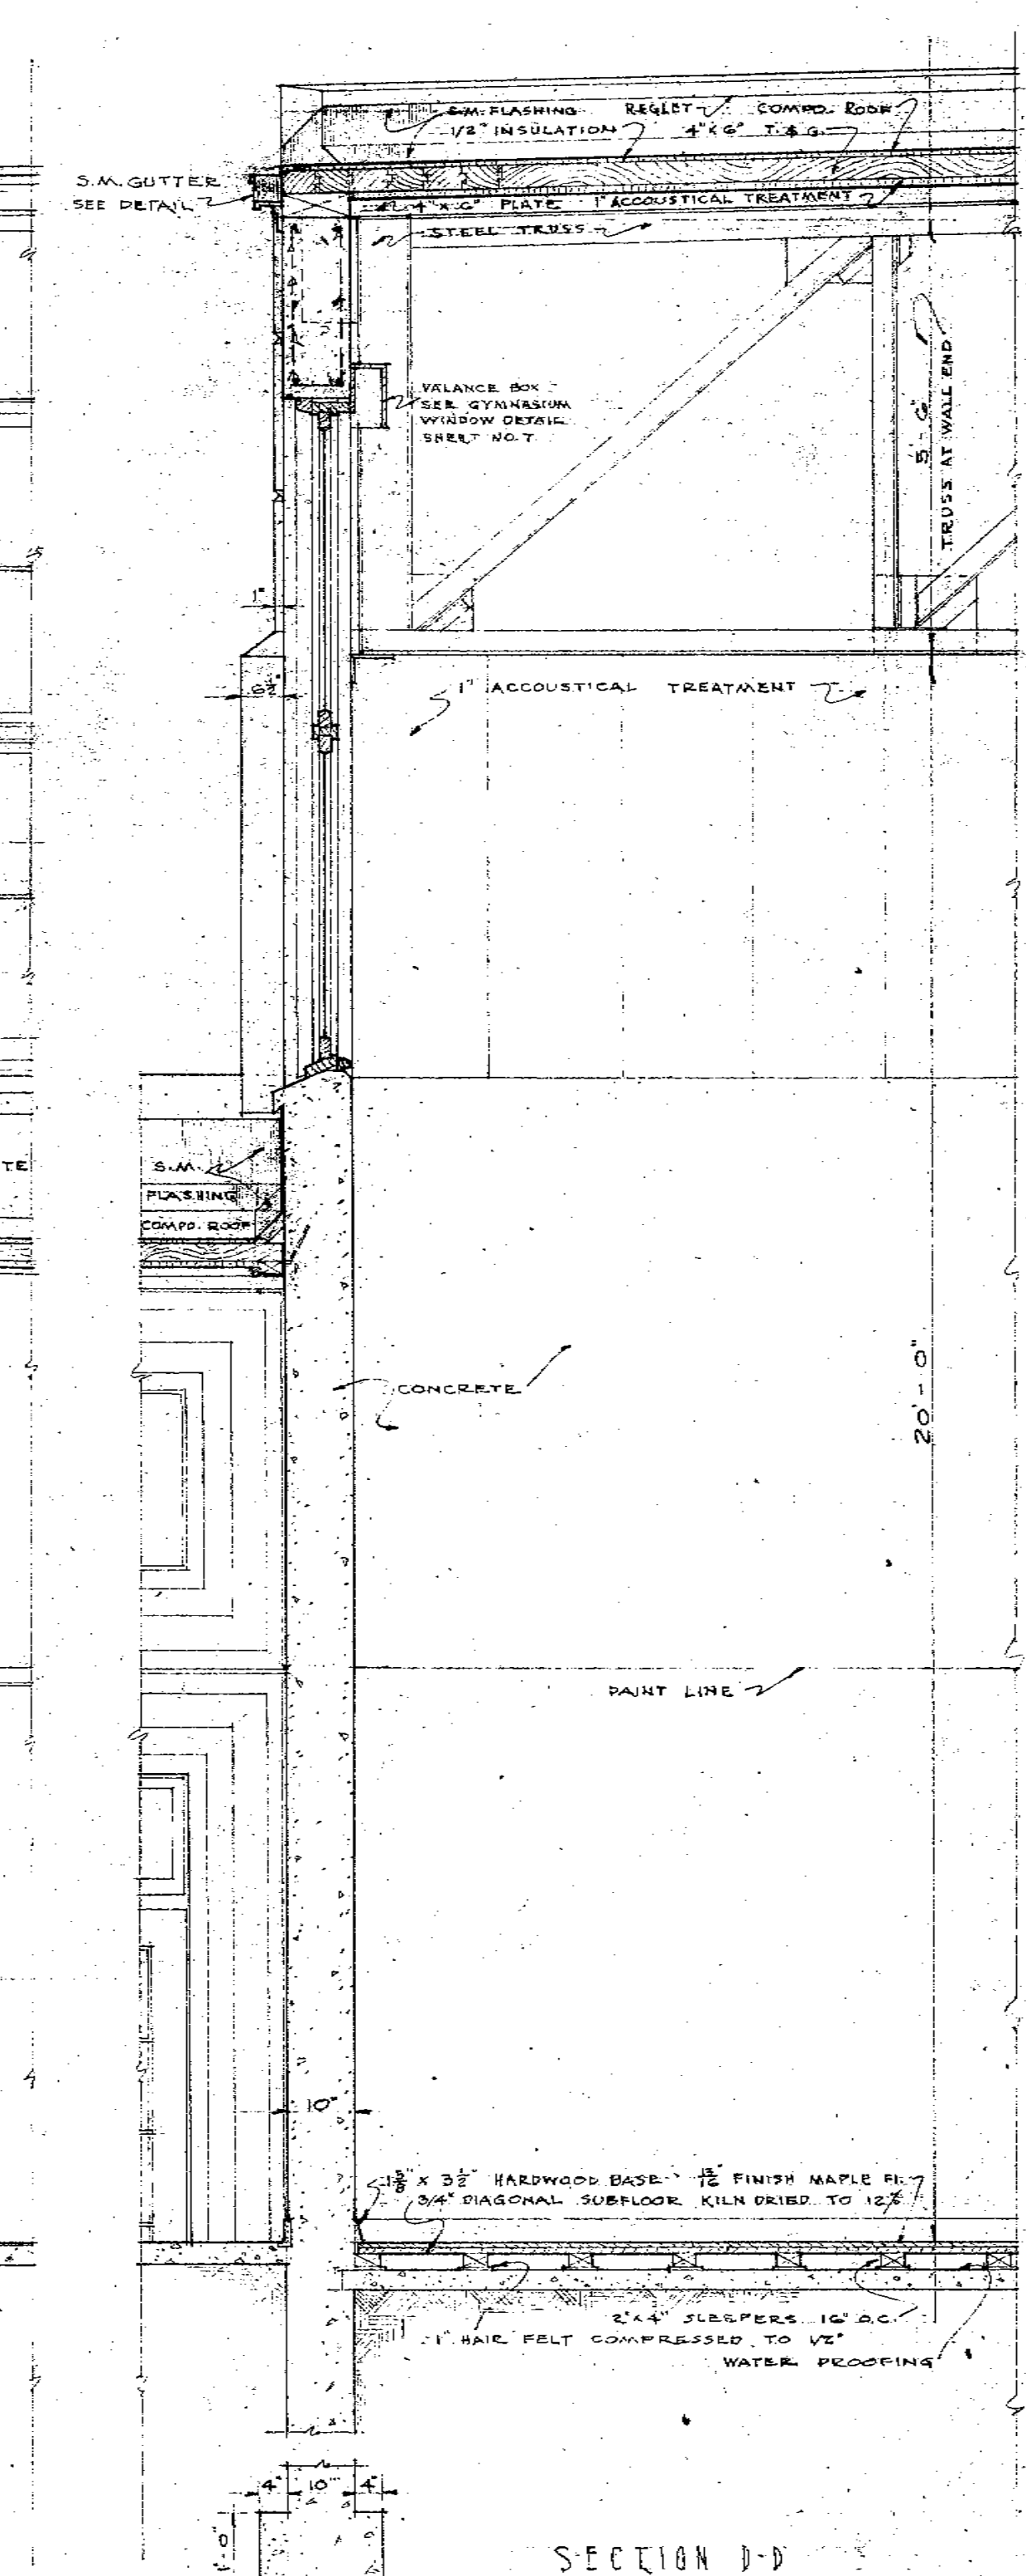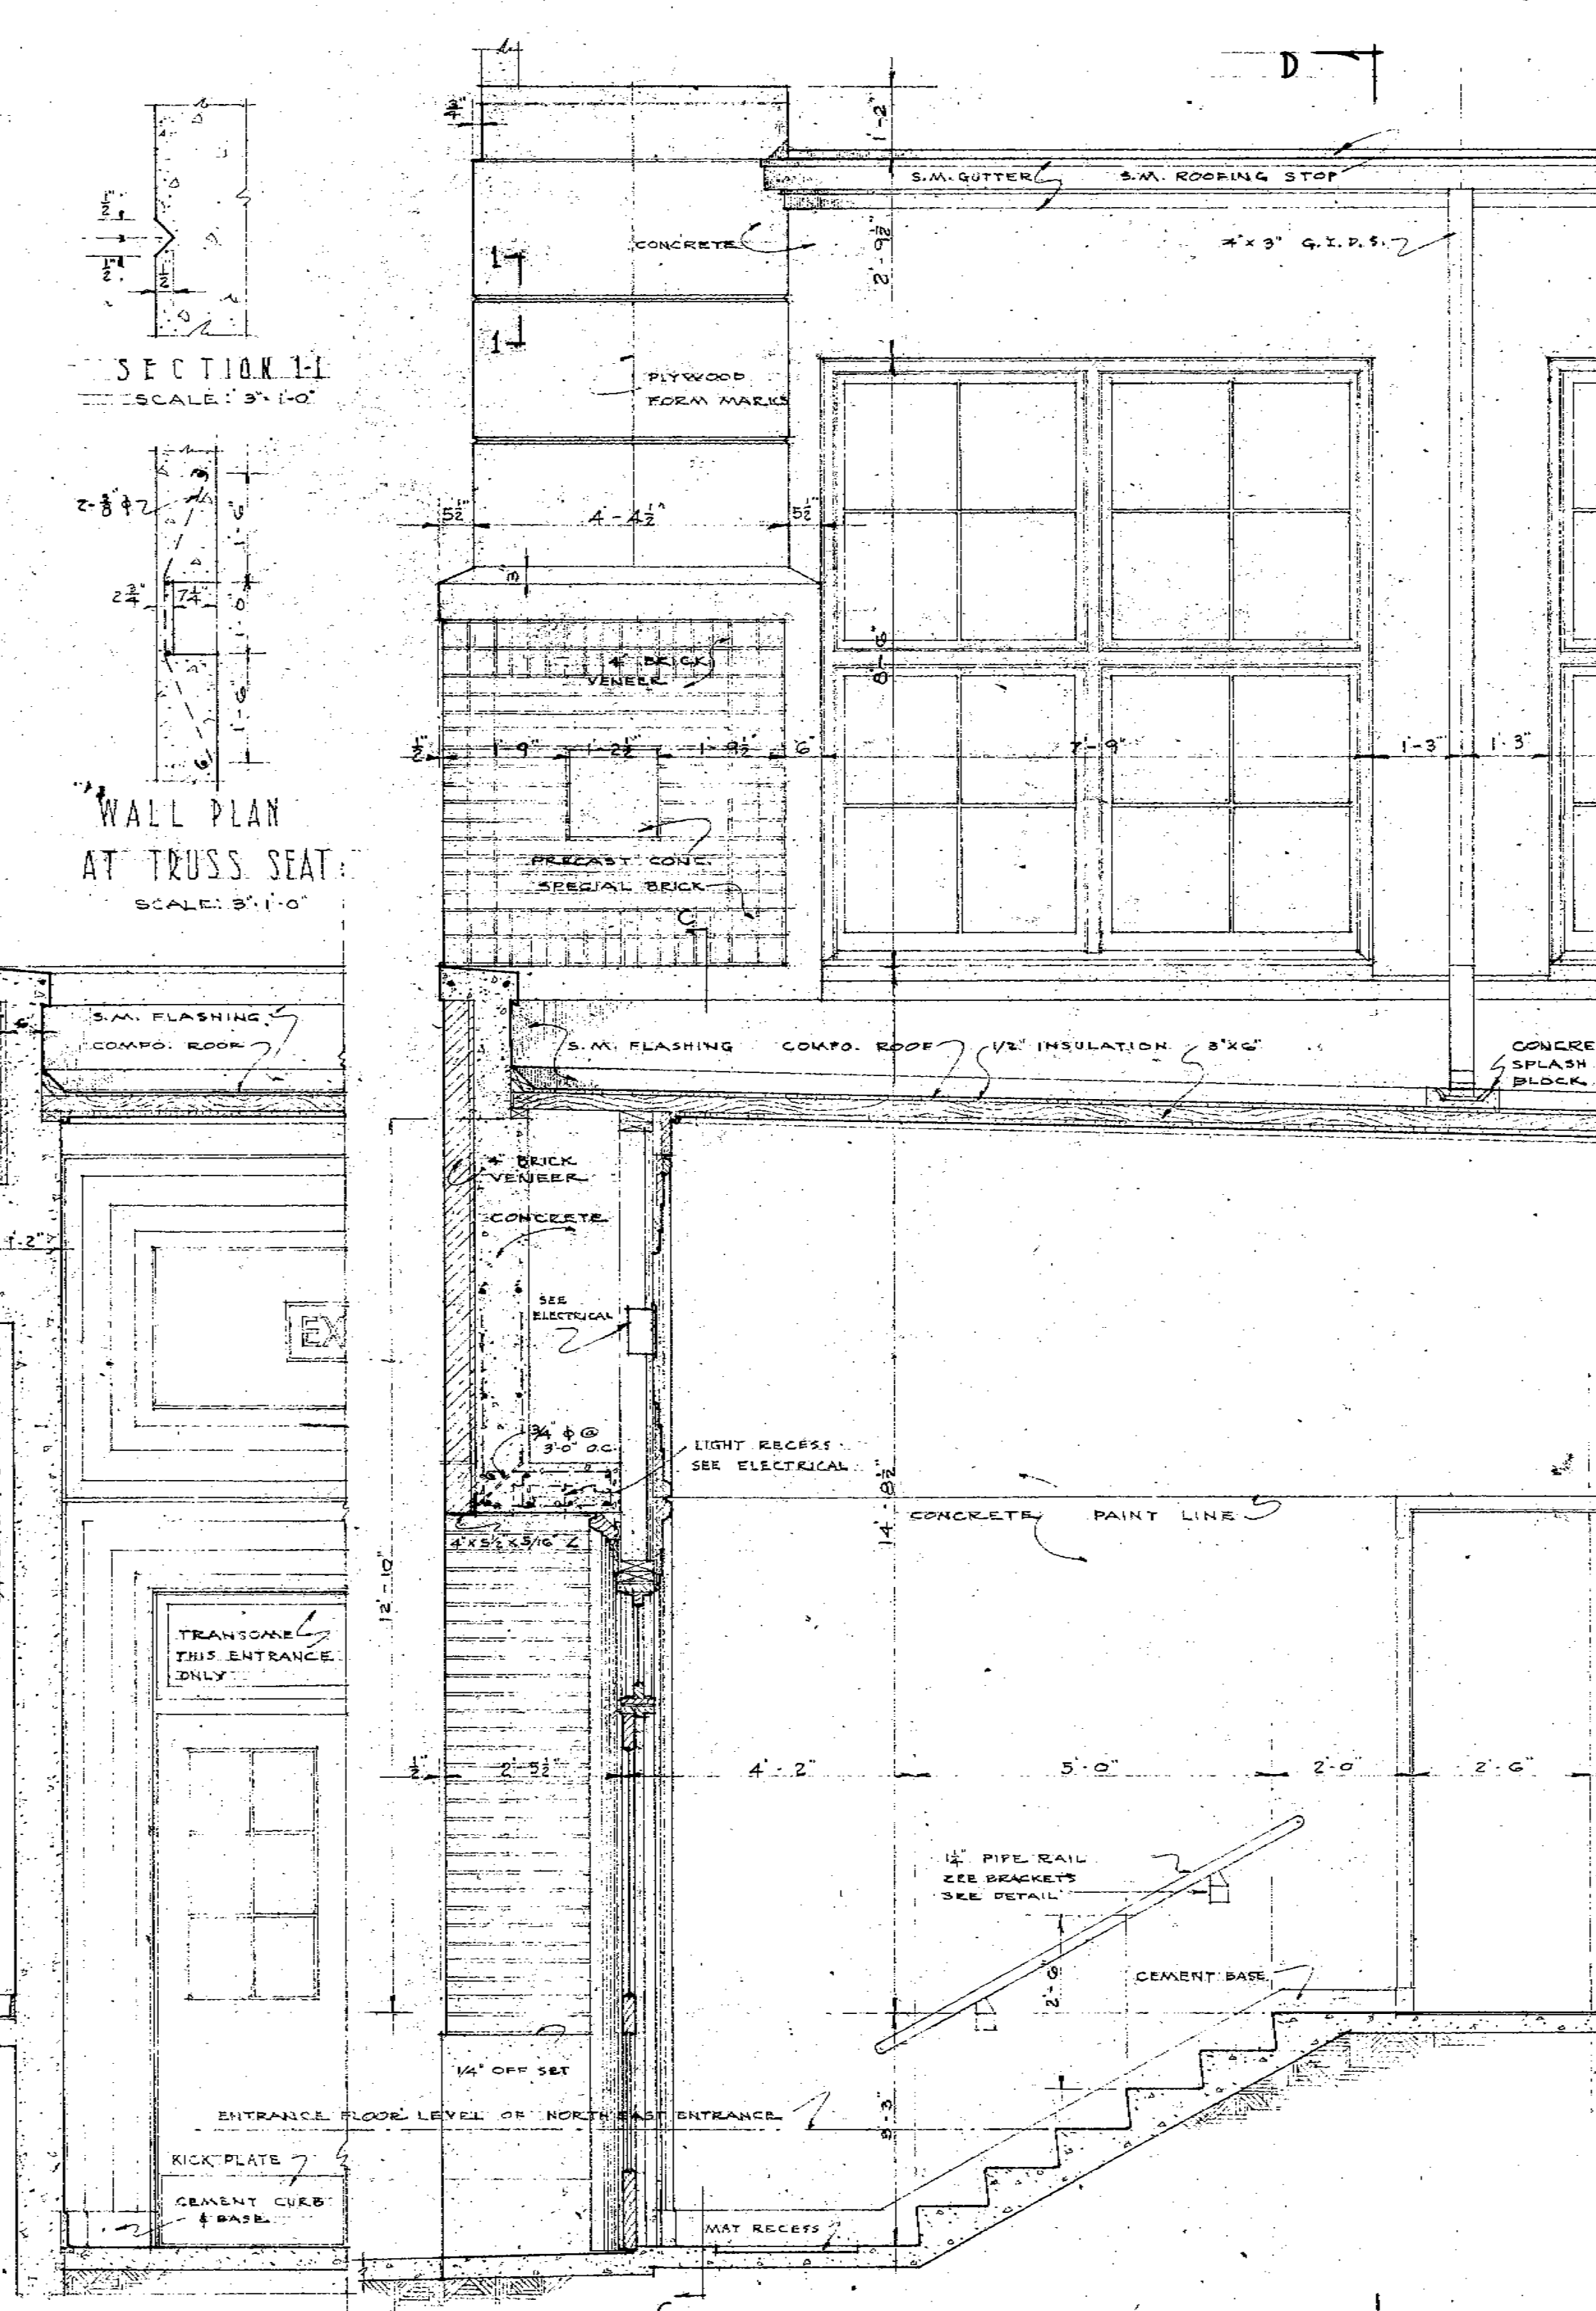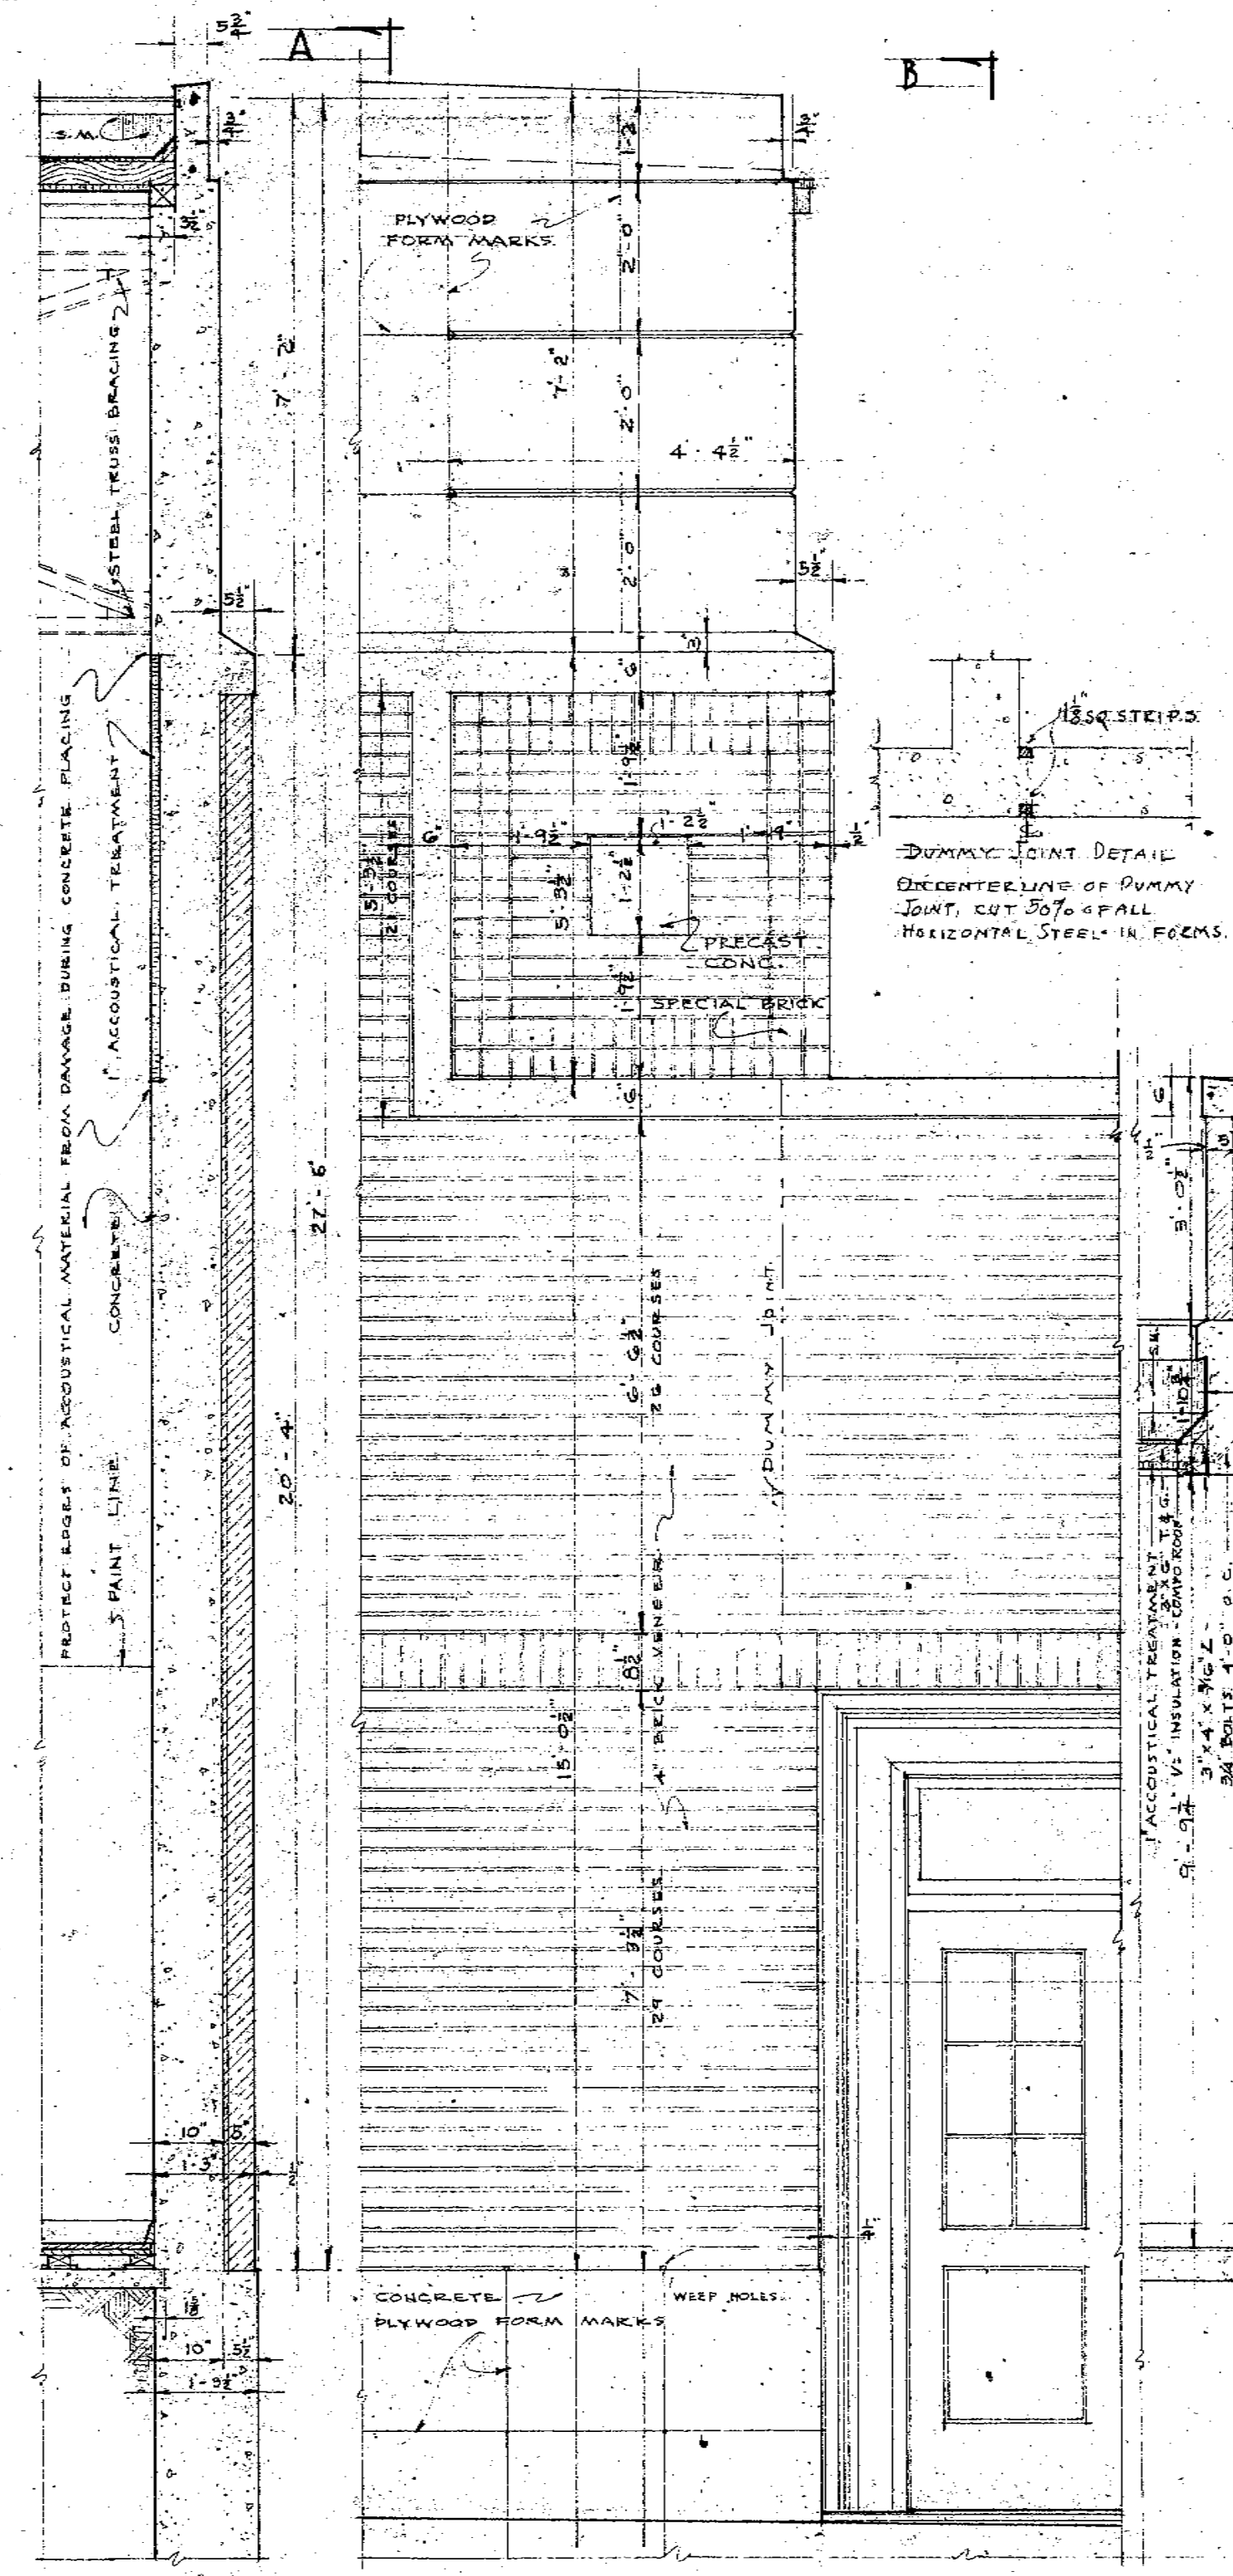

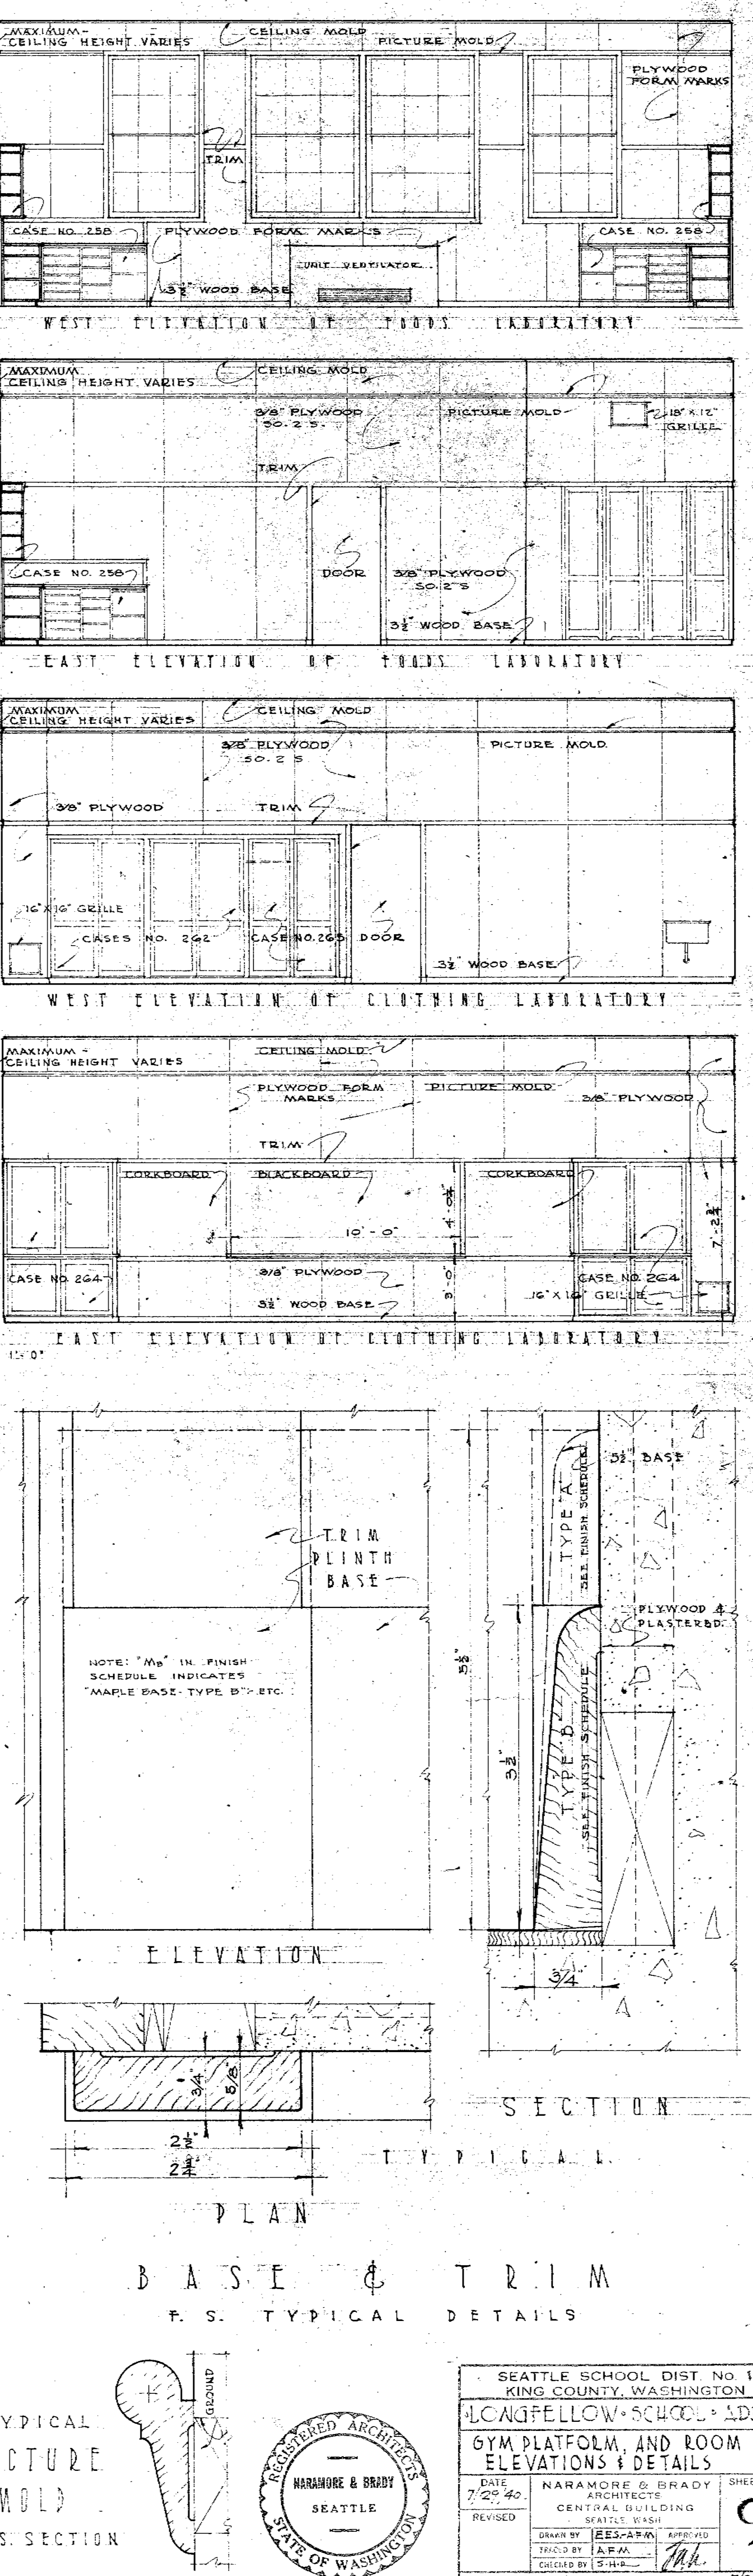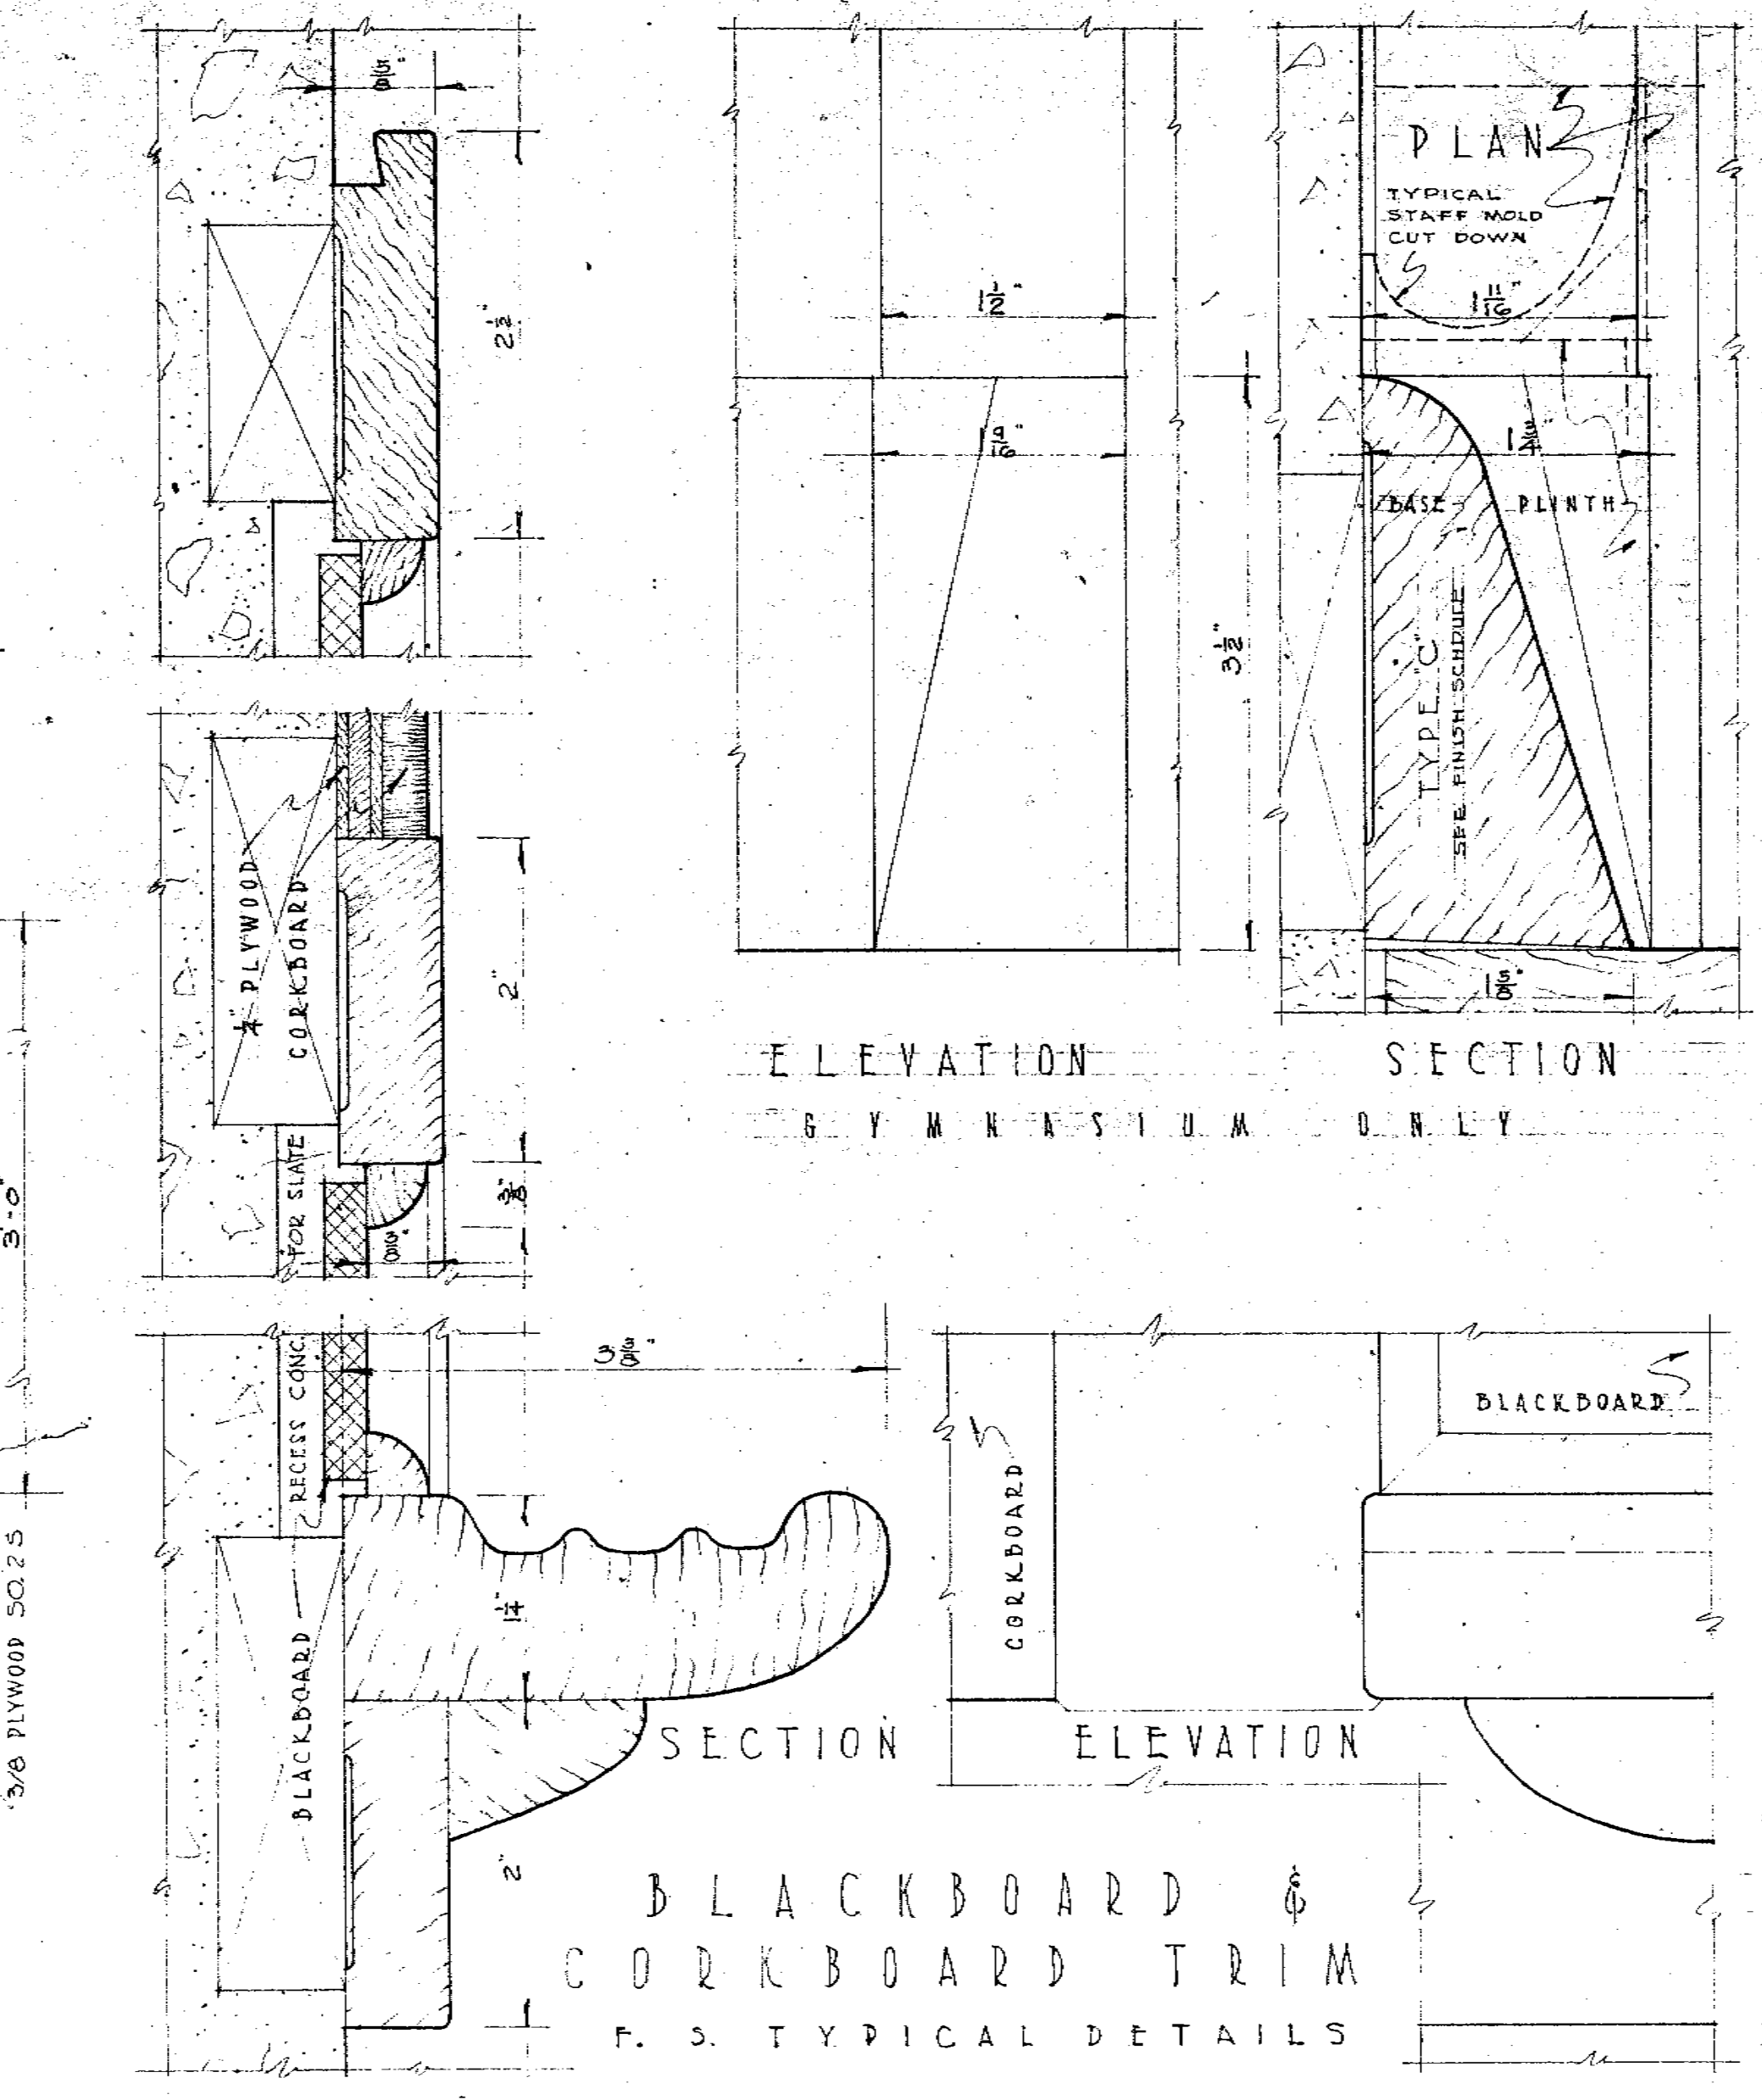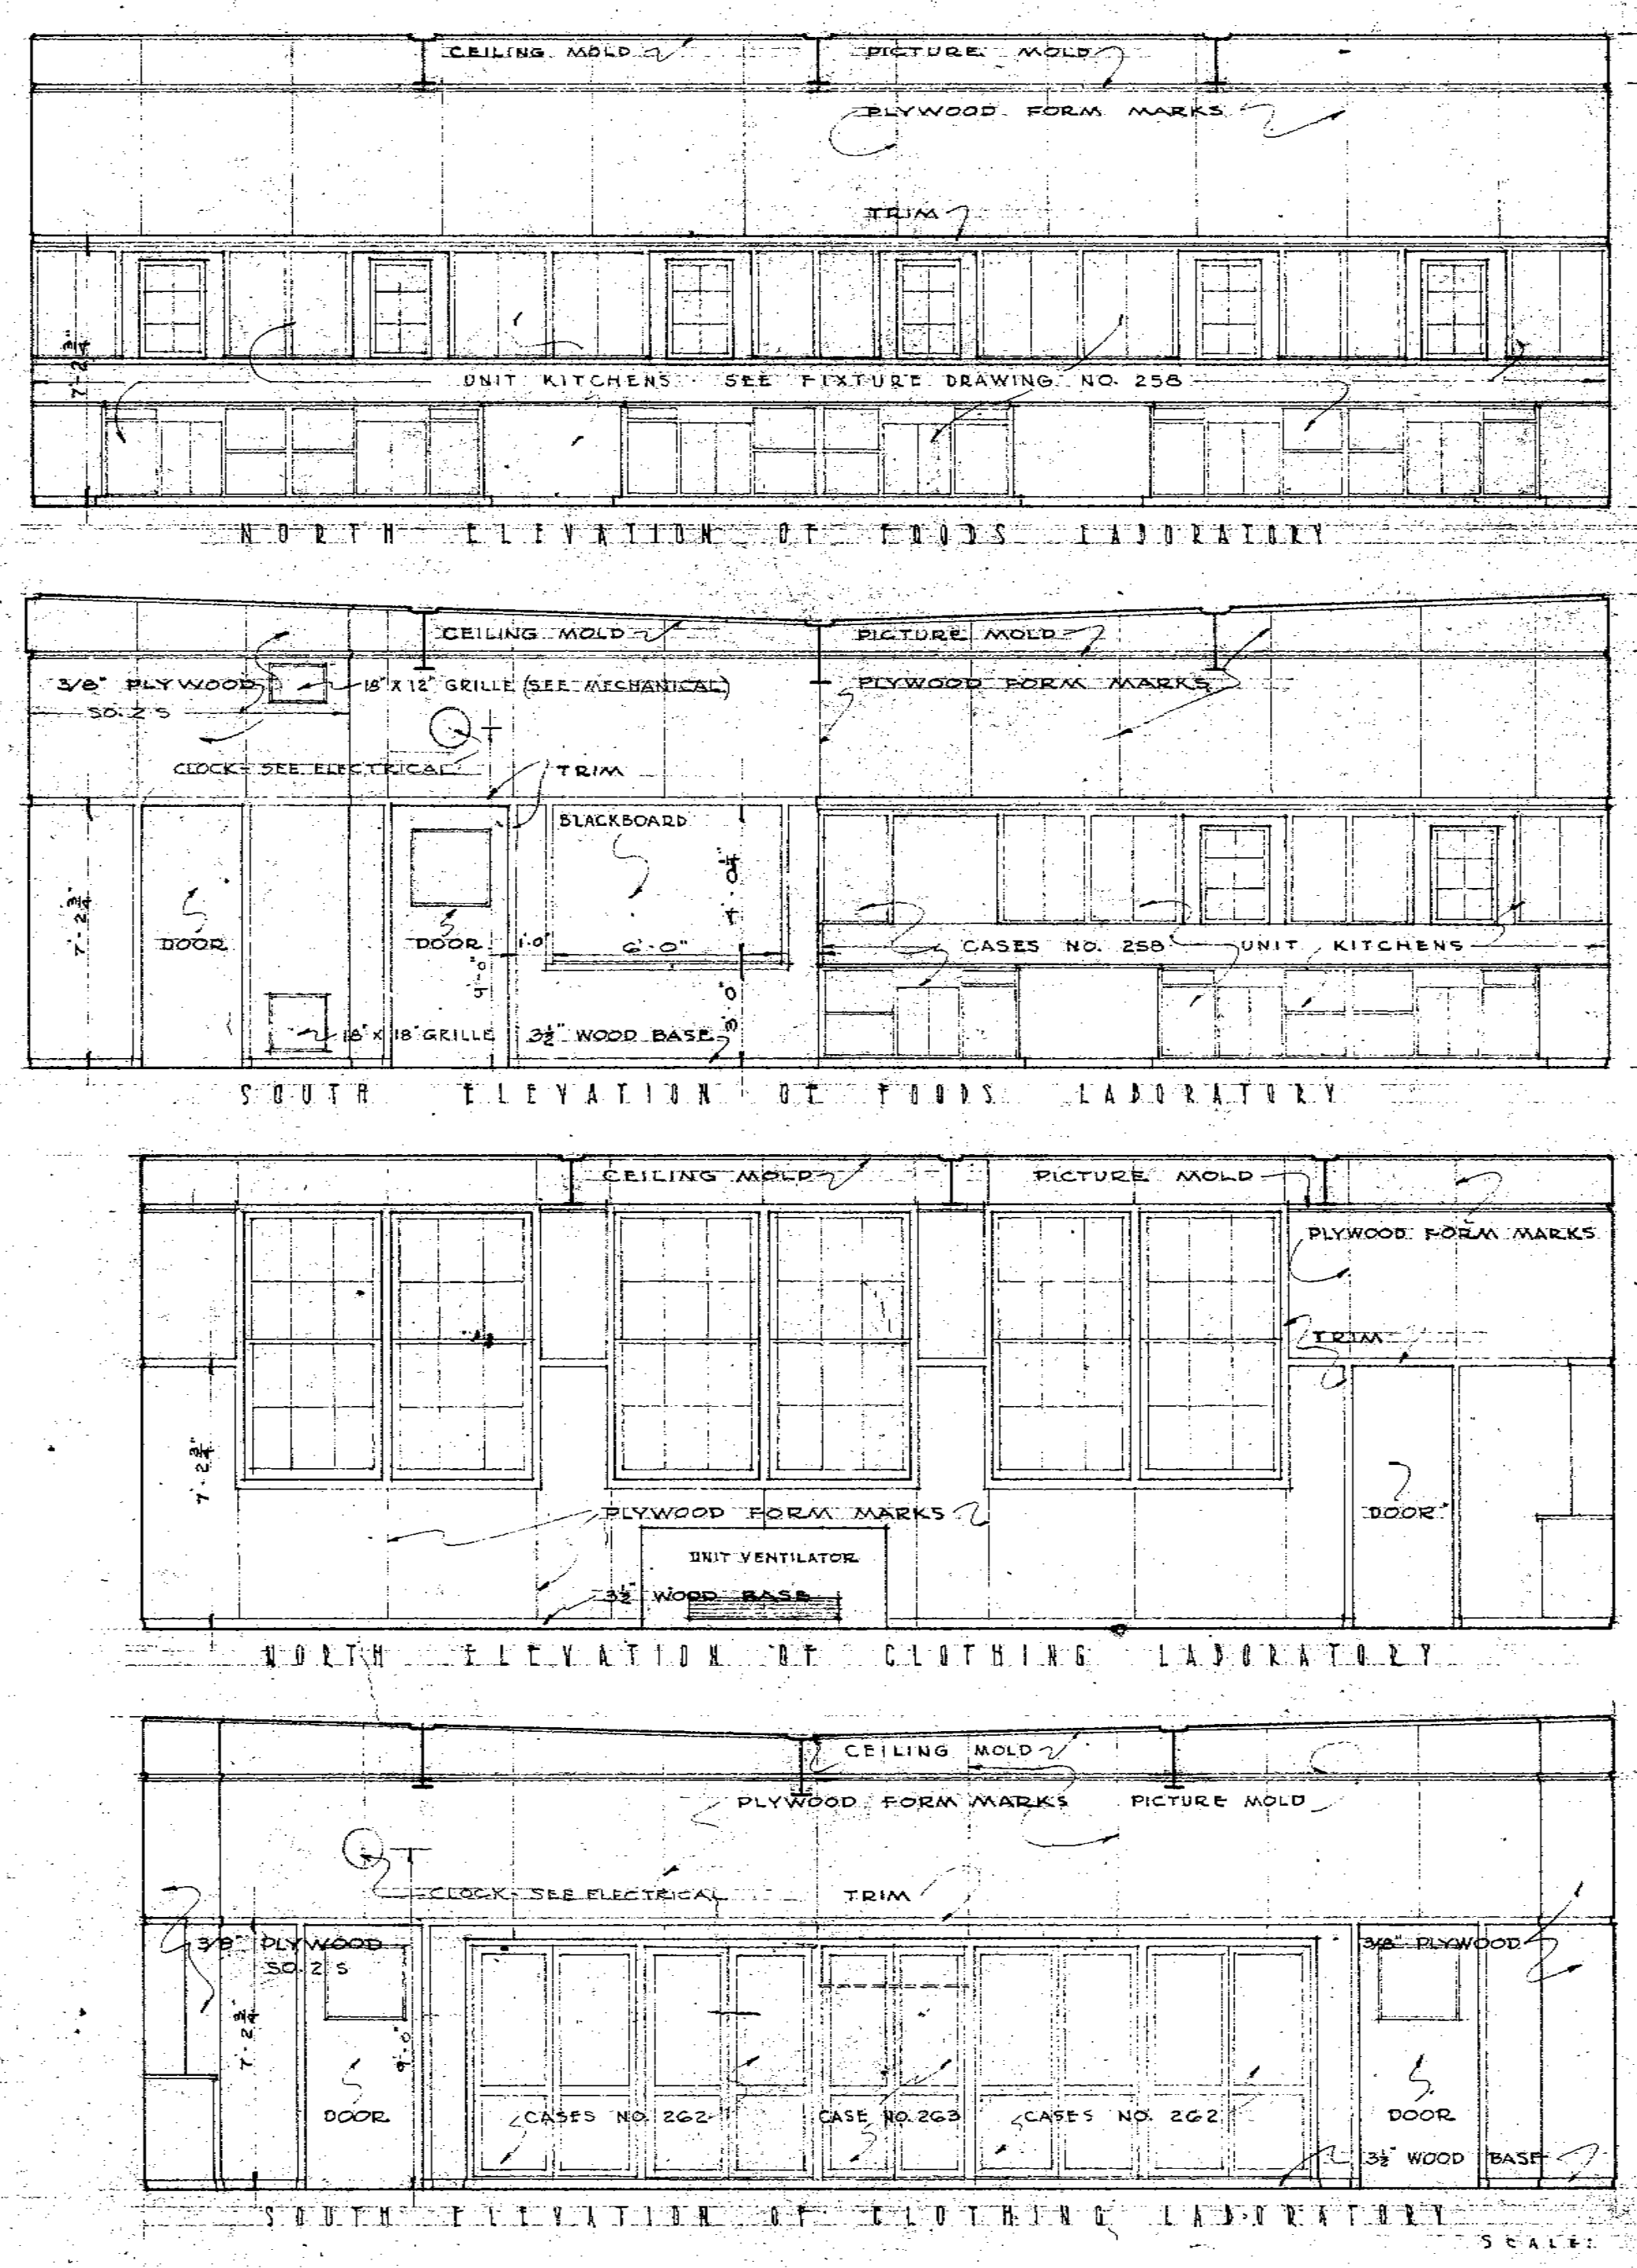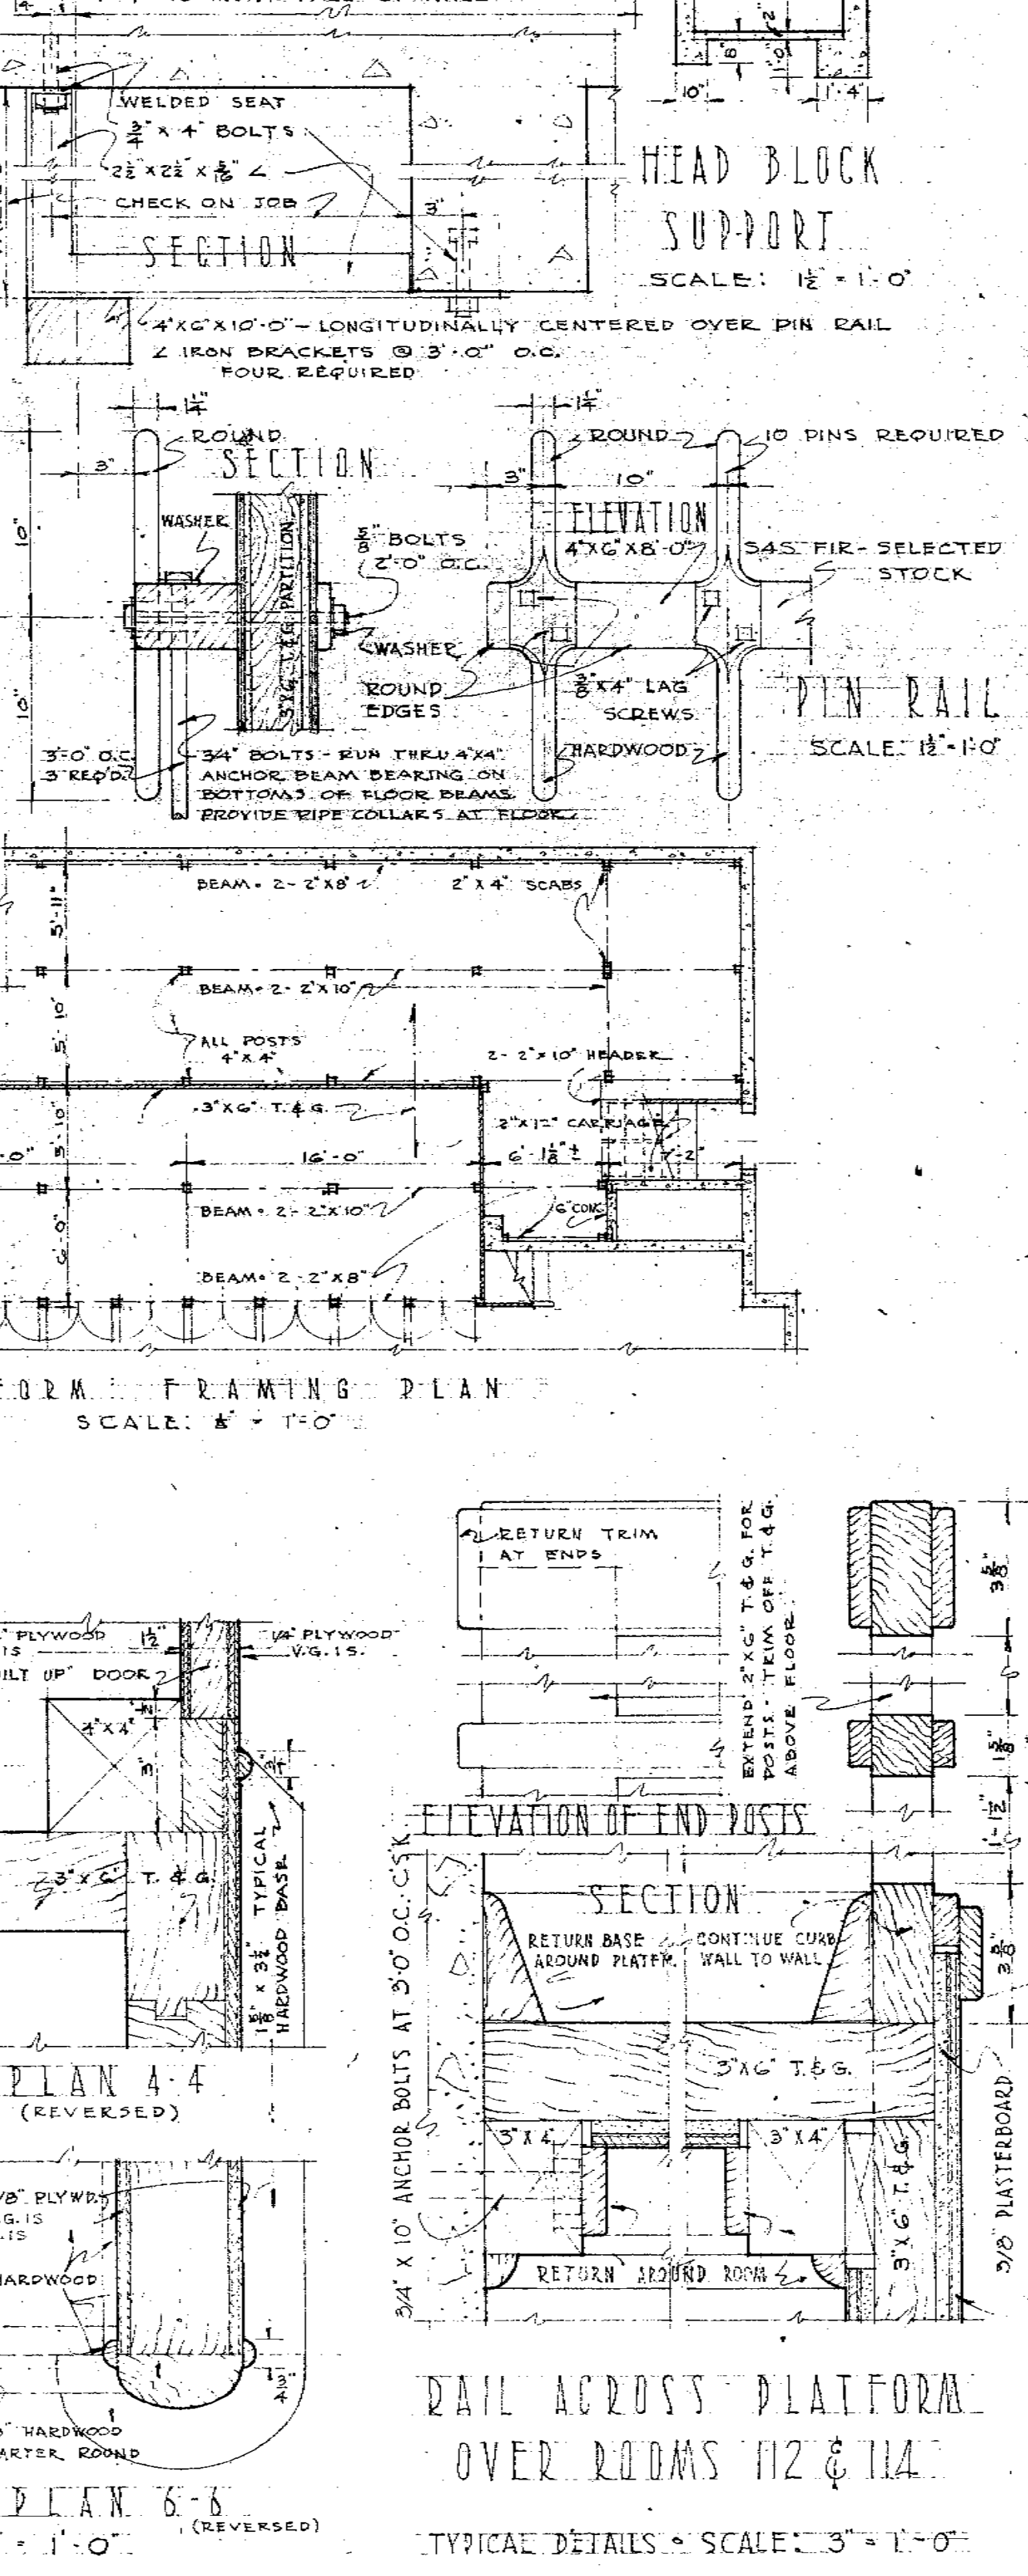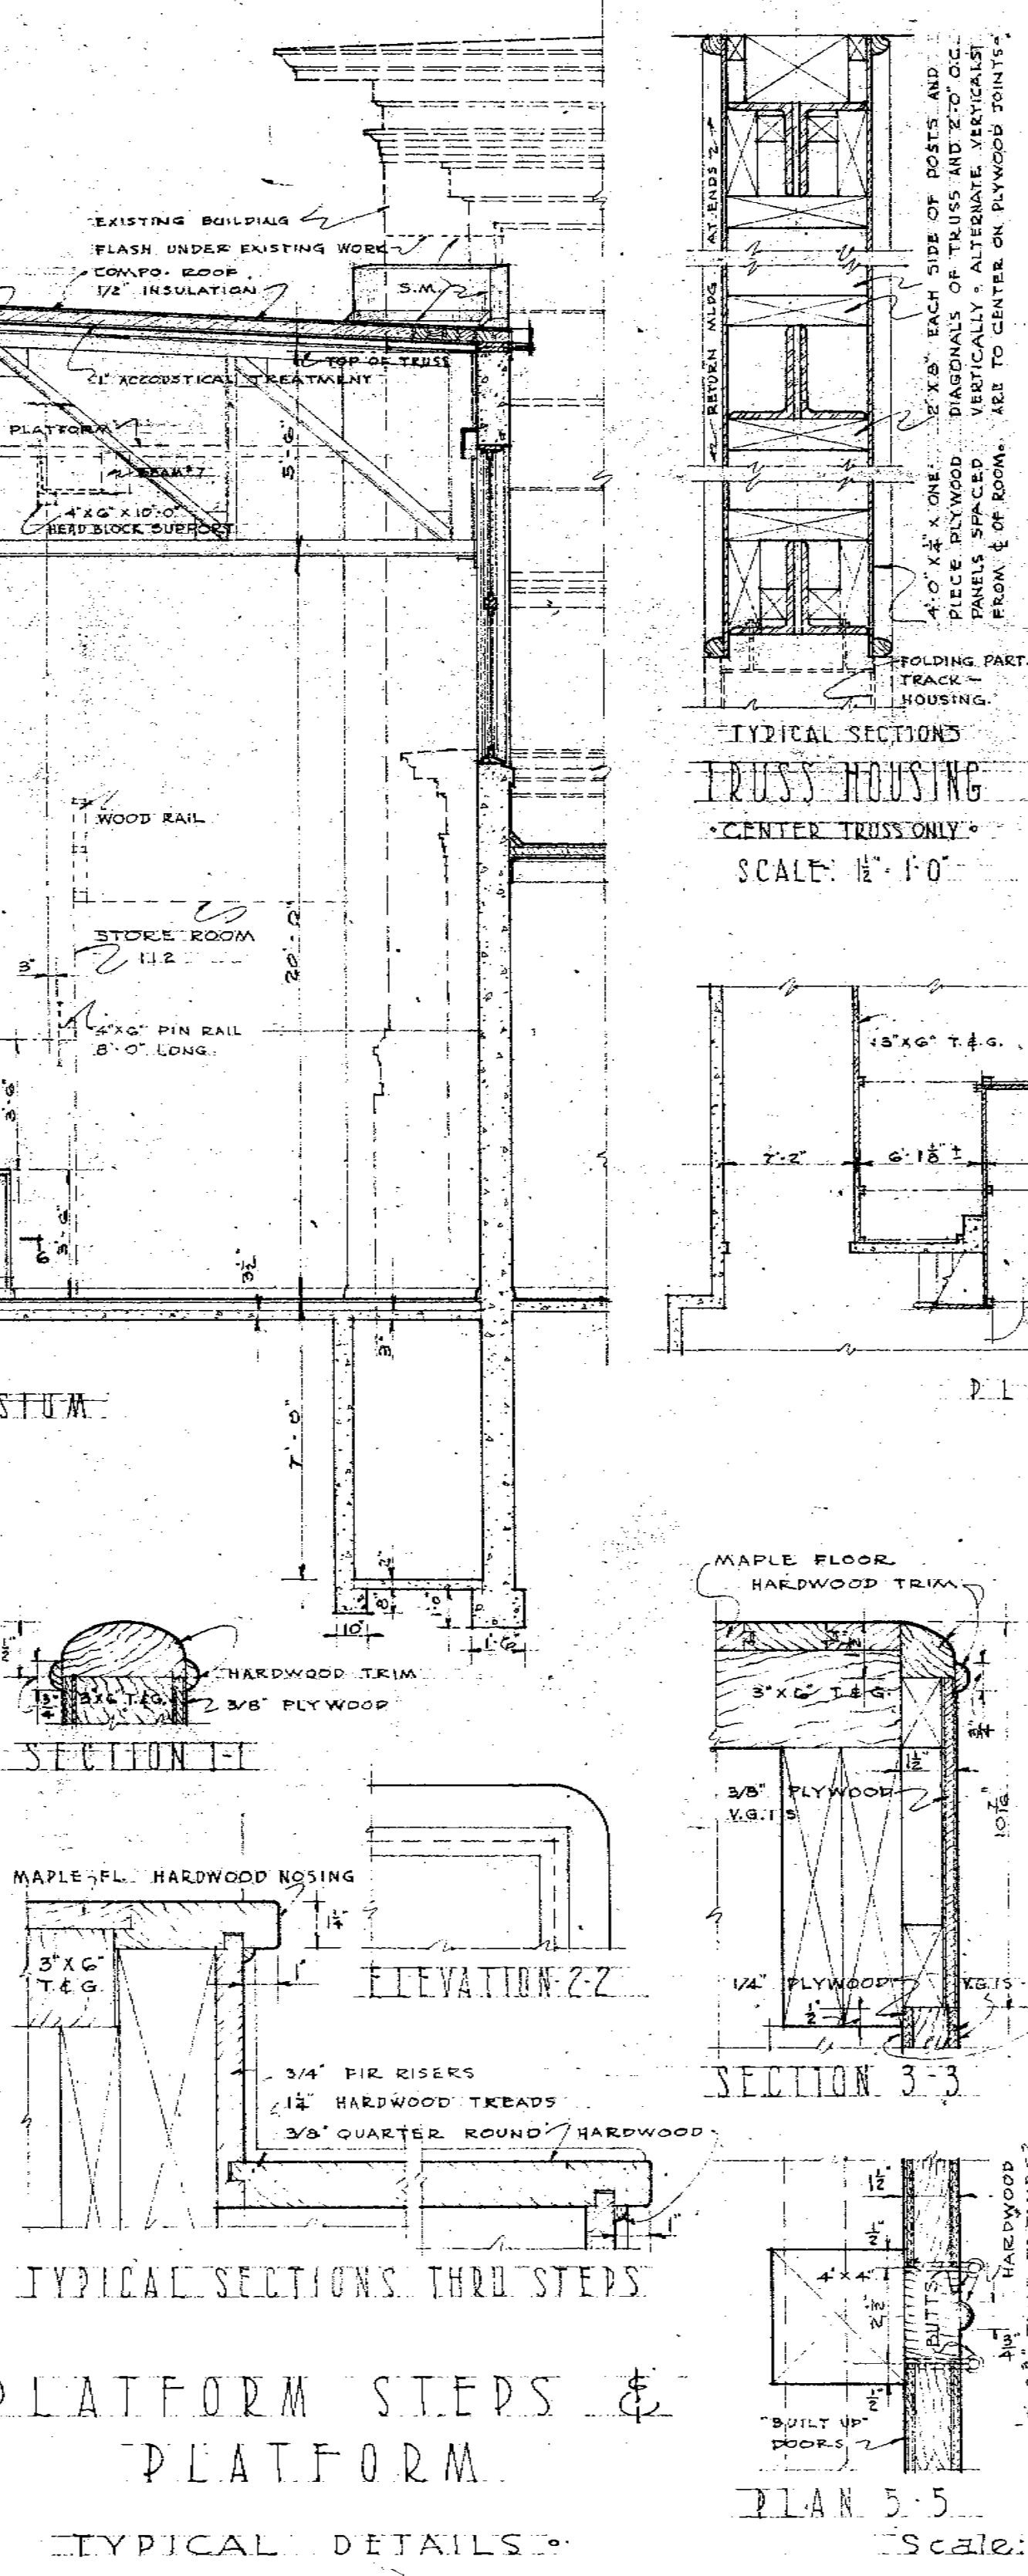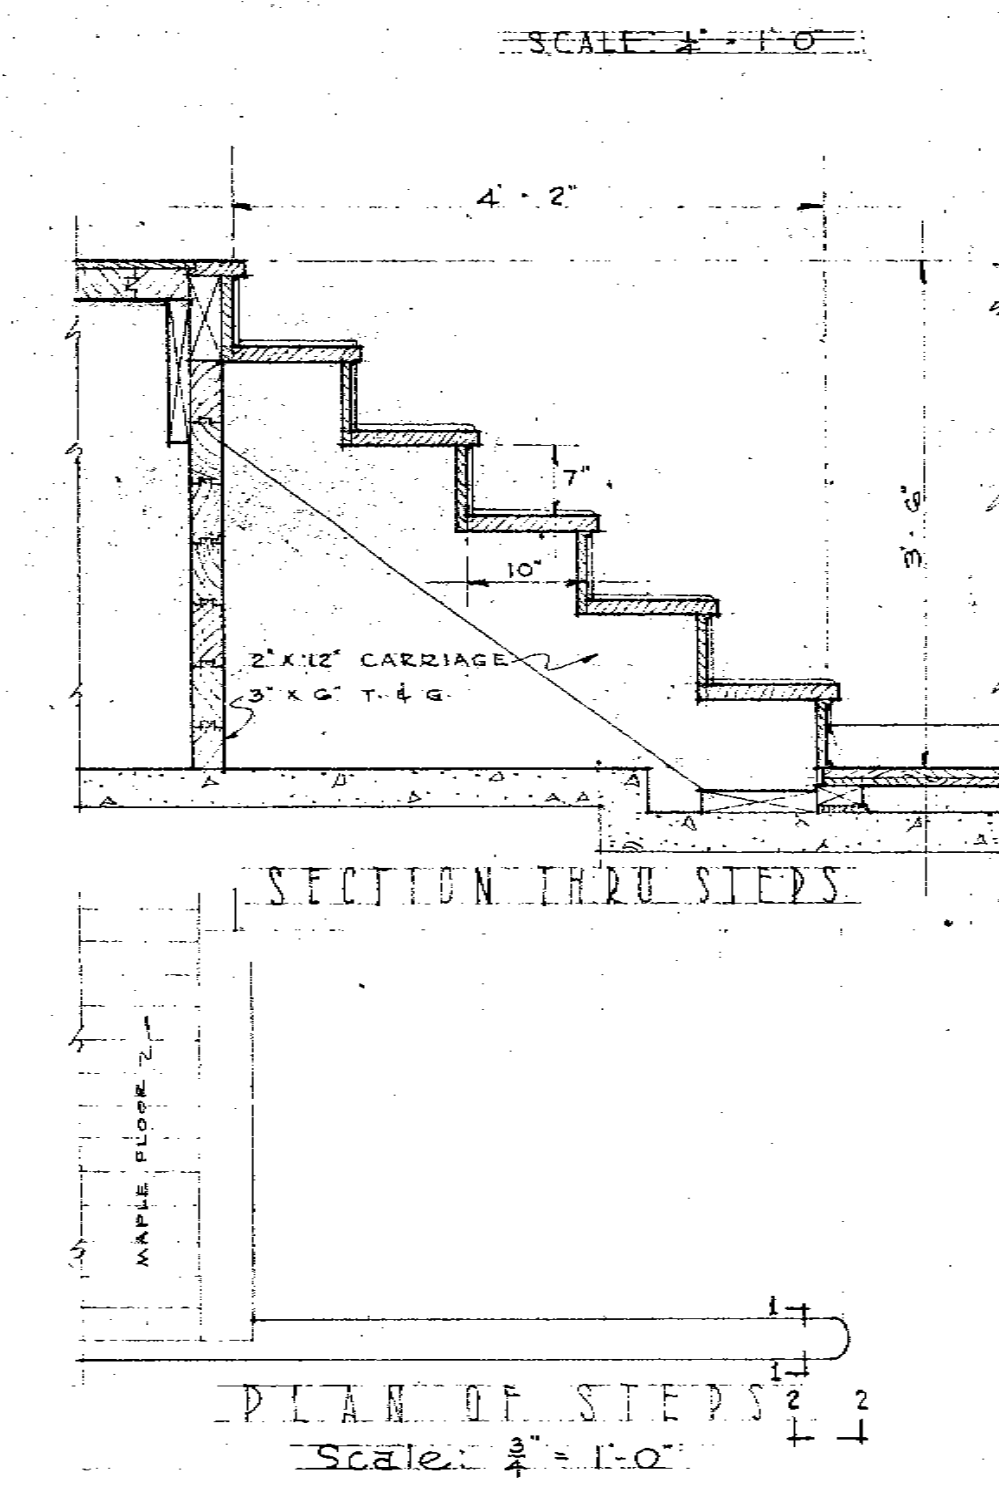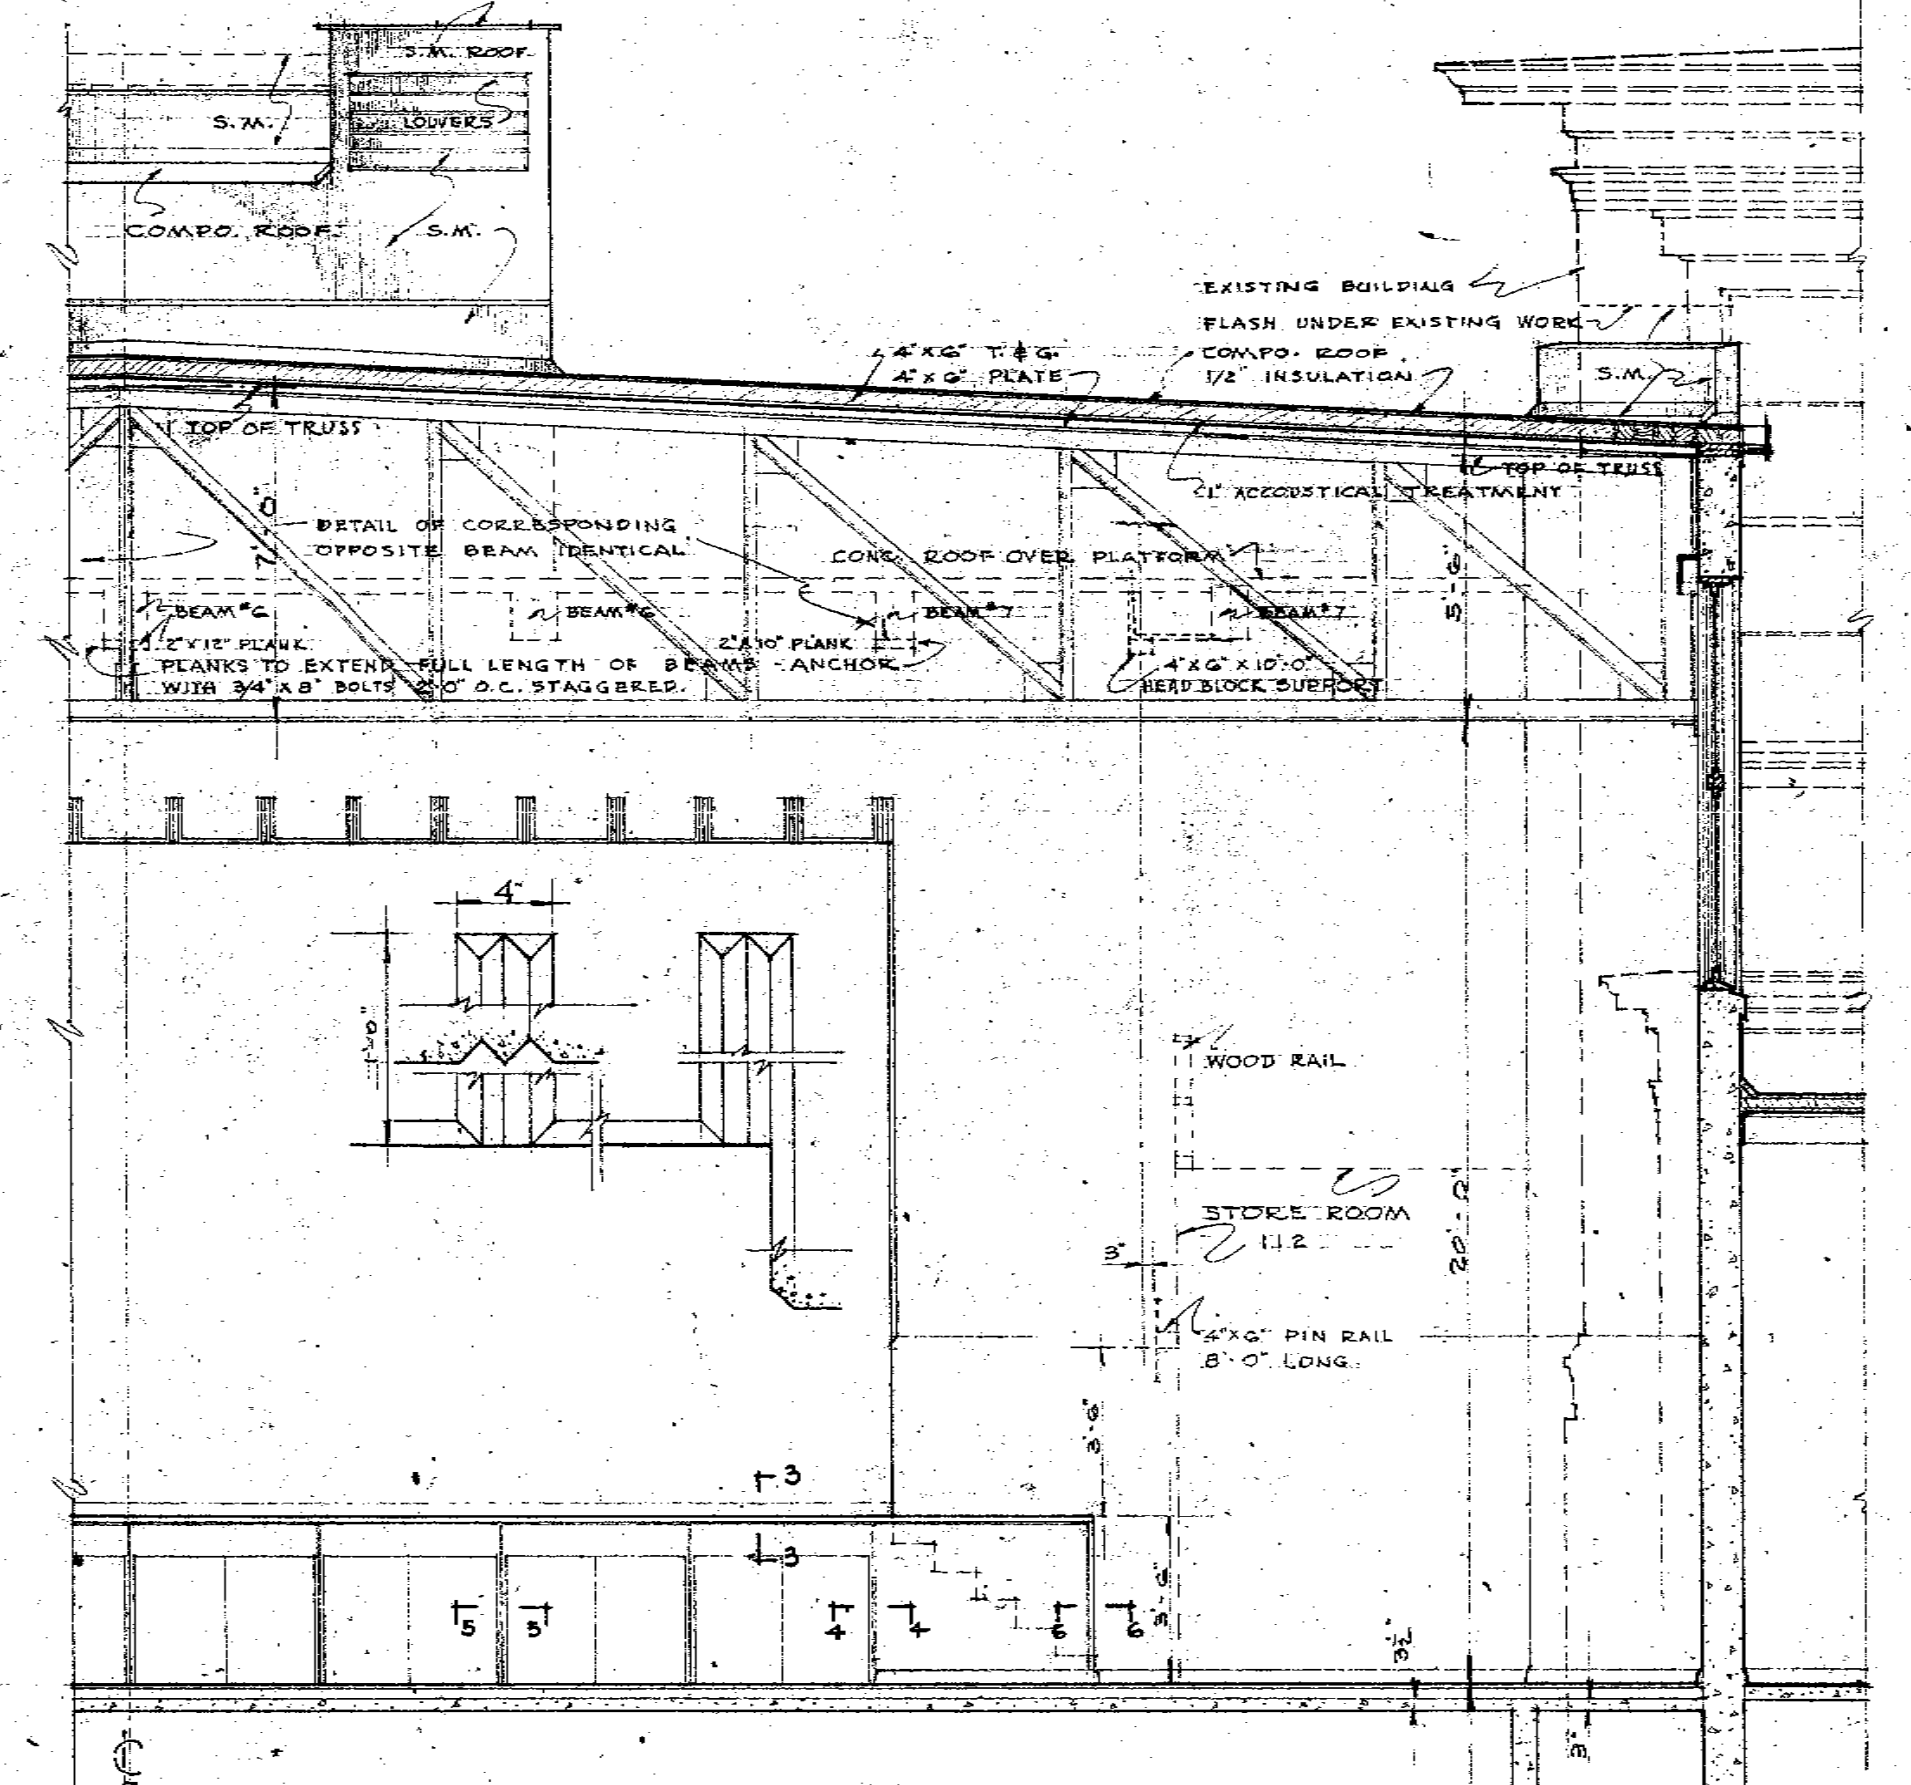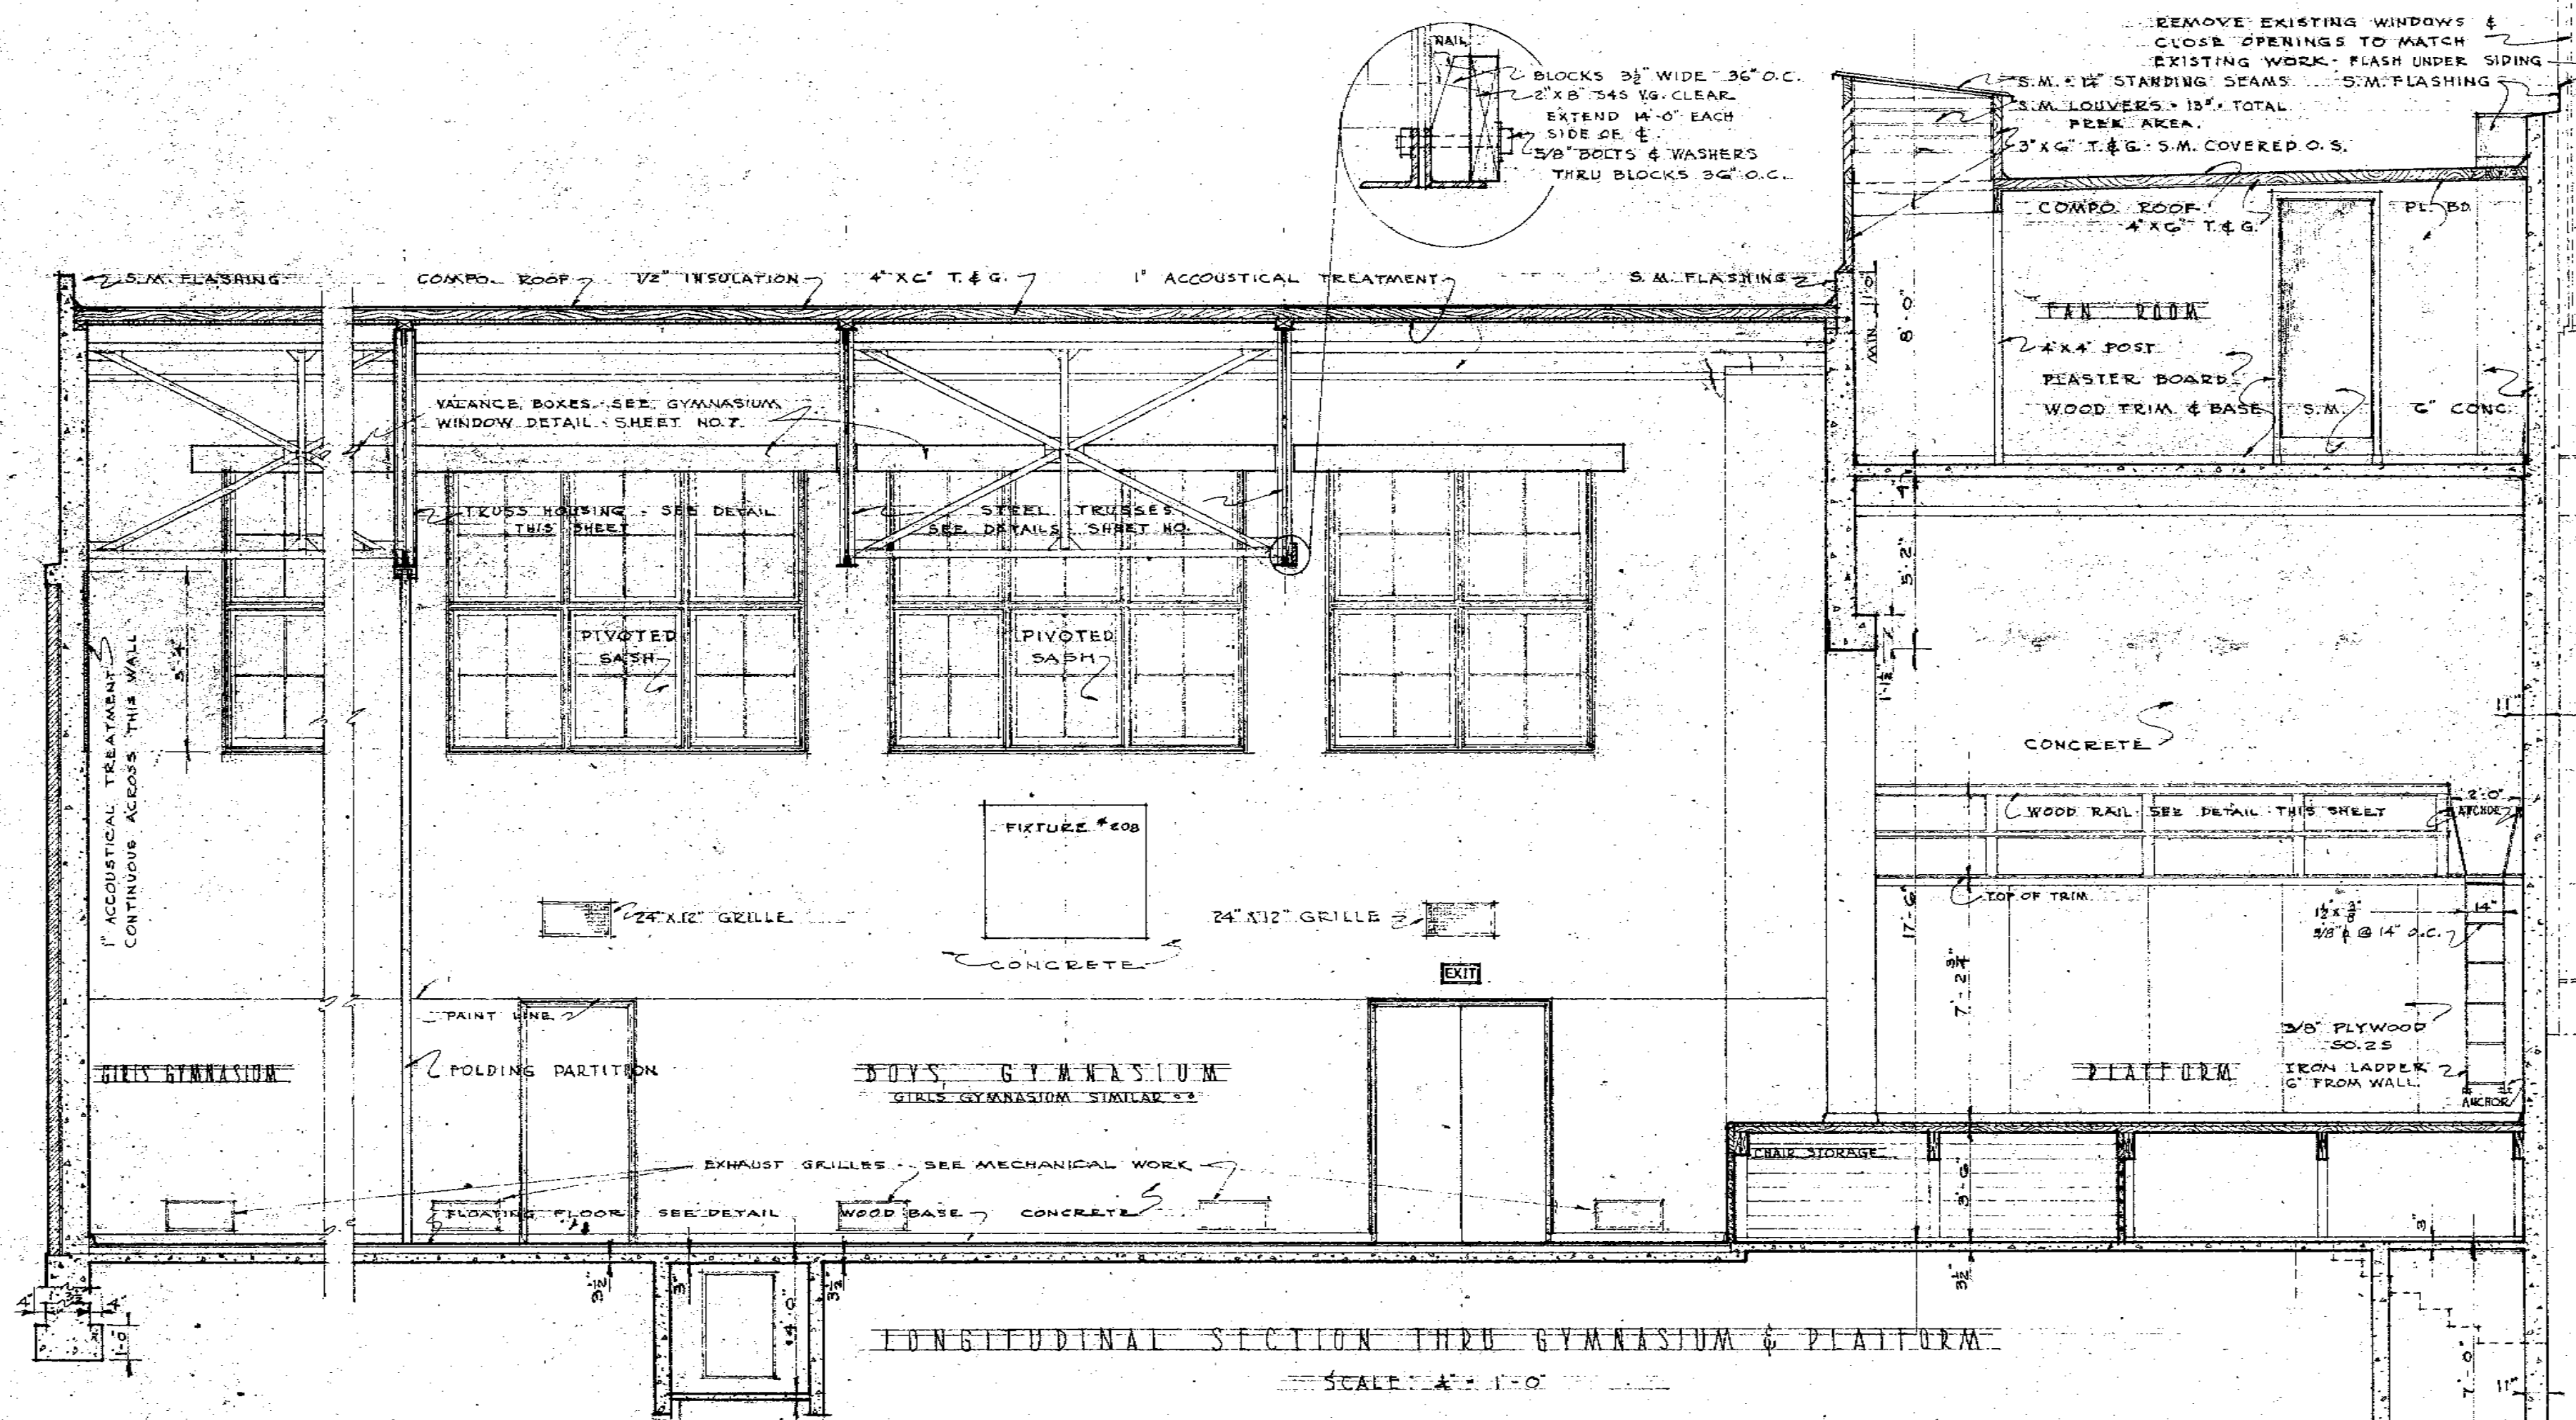

SEATTLE SCHOOL DIST NO 1
KING COUNTY, WASHINGTON
LONGFELLOW SCHOOL - ADDN.
GYM PLATFORM, AND ROOM
ELEVATIONS & DETAILS
DATE 7-20-40
REVISED
DRAWN BY J. E. CARRAN
CHECKED BY J. E. CARRAN
APPROVED
NARAYAN & GRADY
ARCHITECTS
SEATTLE
SHEET NO. 9
DATE 7/20/40

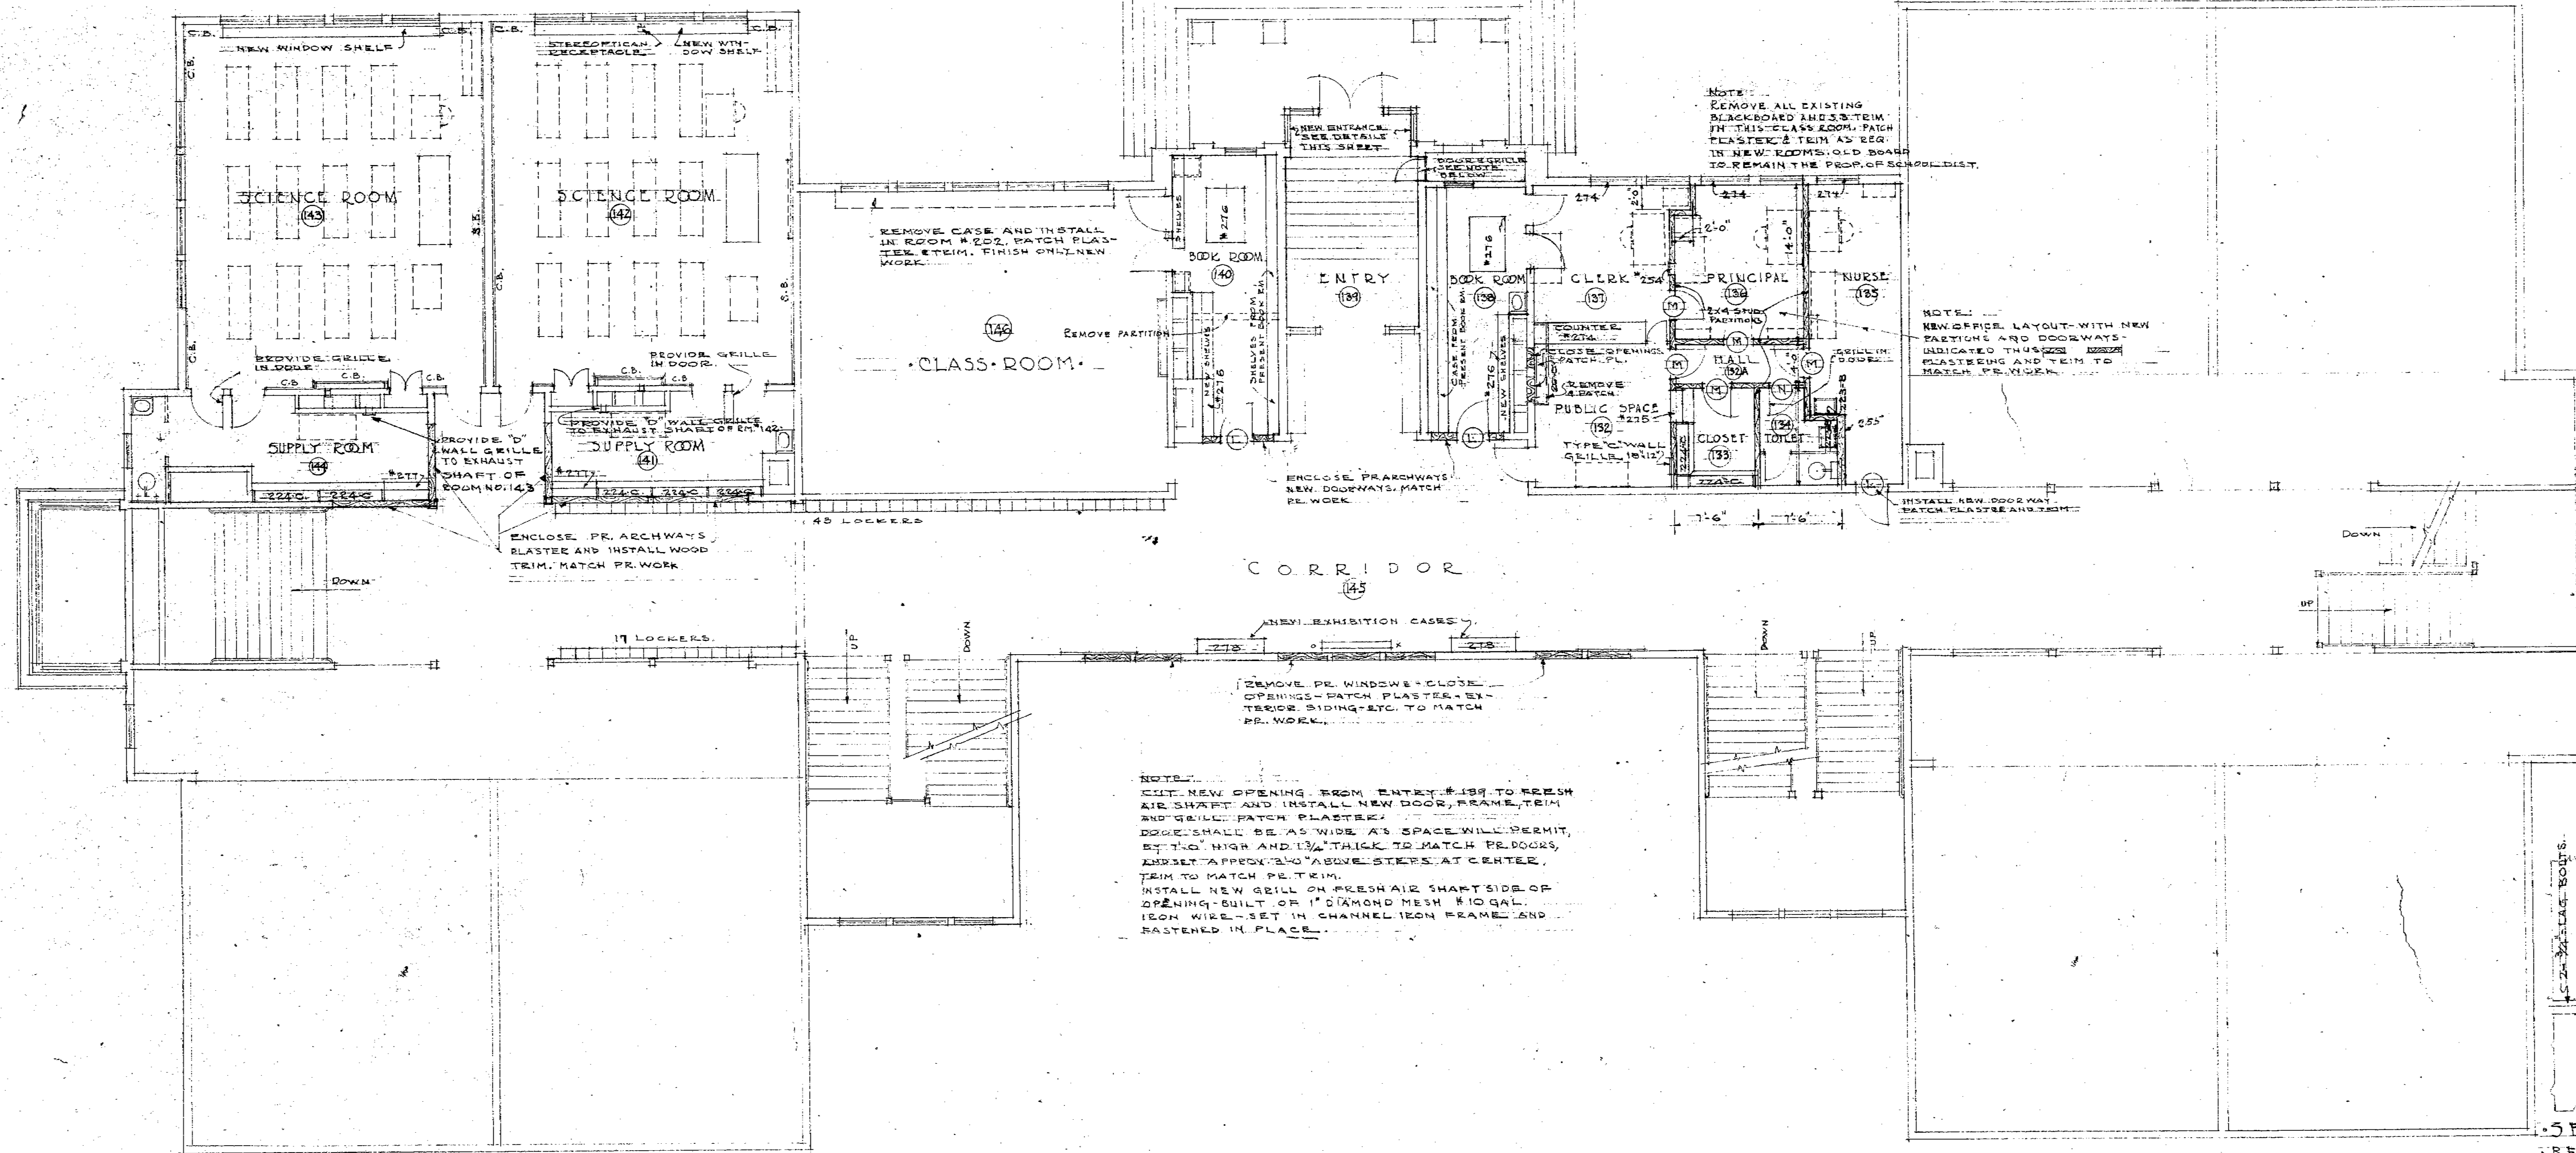












FIRST FLOOR PLAN
SCALE 1/8" = 1'-0"

NAME OF ROOM	NO.	FLOOR	WALL	CEILING	TRIM	DOOR	WINDOW	PAINT	FINISH	REMARKS
PUBLIC SPACE	132	0	SAND	N-F	P-B	N-F	N-F	-	-	N-PL N-PL O D.B. OLYN N-PL K K
HALL	132A	SAND	F	P-B	F	-	-	-	-	PL -PL O D.B. OLYN N-PL K K
CLOSET	133	SAND	N-F	P-B	N-F	-	-	-	-	N-PL N-PL O D.B. OLYN N-PL K K
TOILET	134	SAND	N-F	P-B	N-F	-	-	-	-	N-PL N-PL O D.B. OLYN N-PL K K
NURSE	135	SAND	N-F	P-B	N-F	-	-	-	-	N-PL N-PL O D.B. OLYN N-PL K K
PRINCIPAL	136	SAND	N-F	P-B	N-F	-	-	-	-	N-PL N-PL O D.B. OLYN N-PL K K
CLERK	137	SAND	N-F	P-B	N-F	-	-	-	-	N-PL N-PL O D.B. OLYN N-PL K K
BOOK ROOM	138	0	N-F	P-B	N-F	-	-	-	-	N-PL N-PL O D.B. OLYN N-PL K K
ENTRY	139	0	O	P-B	N-F	-	-	-	-	ENTR. N-PL O D.B. OLYN N-PL K K
BOOK ROOM	140	0	N-F	P-B	N-F	-	-	-	-	N-PL N-PL O D.B. OLYN N-PL K K
SUPPLY RM.	141	0	N-F	P-B	N-F	-	-	-	-	N-PL N-PL O D.B. OLYN N-PL K K
SCIENCE RM.	142	0	O	O	N-F	O	N-CB	O	O	N-PL N-PL O D.B. OLYN N-PL K K
SUPPLY RM.	144	0	N-F	P-B	N-F	-	-	-	-	N-PL N-PL O D.B. OLYN N-PL K K
CORRIDOR	145	0	N-F	P-B	N-F	-	-	-	-	N-PL N-PL O D.B. OLYN N-PL K K
CLASS ROOM	146	0	N-F	P-B	N-F	-	-	-	-	N-PL N-PL O D.B. OLYN N-PL K K

GENERAL NOTE:
THE ABOVE SCHEDULE SHALL BE USED WITH THE FLOOR PLAN AND ROOM ELEVATIONS ON THIS SHEET, SHOWING WORK ON PRESENT TRIM SHALL MATCH PRESENT WORK UNLESS OTHERWISE SHOWN. PATCH AND REFINISH PLASTER AND TRIM WHERE DAMAGED BY NEW WORK. PATCHING OF ALL WORK COVERING ADDITIONS AND CHANGES SHALL BE COMPLETE IN EVERY DETAIL AND SHALL MATCH PRESENT WORK. WHERE TRIM SHALL BE BLACKBOARD ETC. AS REQUIRED PLASTER SHALL BE PATCHED TO MATCH PRESENT WORK.

WHERE SYMBOL LETTER 'N' IS USED IN SCHEDULE IT SHALL INDICATE NEW WORK. FOR EXAMPLE N-PL IN SCHEDULE MEANS THAT ONLY NEW WORK SHALL BE PLASTERED. PRESENT WORK IS REPRESENTED BY 'P' SYMBOL.














WHERE SCHEDULE CALLS FOR PRESENT TRIM TO BE CLEANED AND VARNISHED IT SHALL INCLUDE WINDOW SASH. ANY SYMBOL WHEN NOT PRECEDED BY 'O' OR 'N' AS EXAMPLE [P] MEANS WHOLE SURFACE. NEW AND OLD IS TO BE PAINTED.

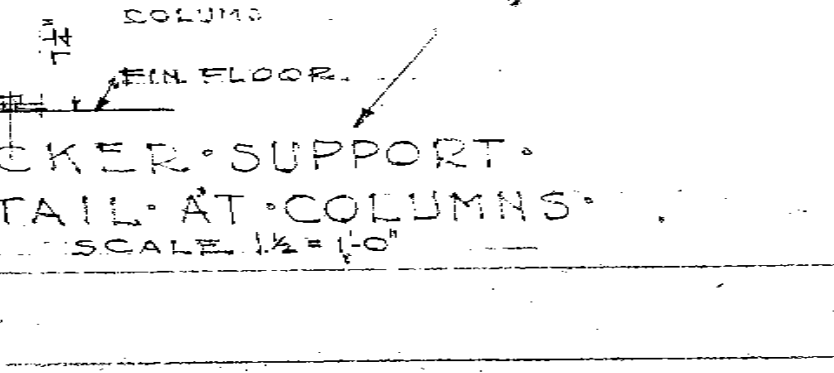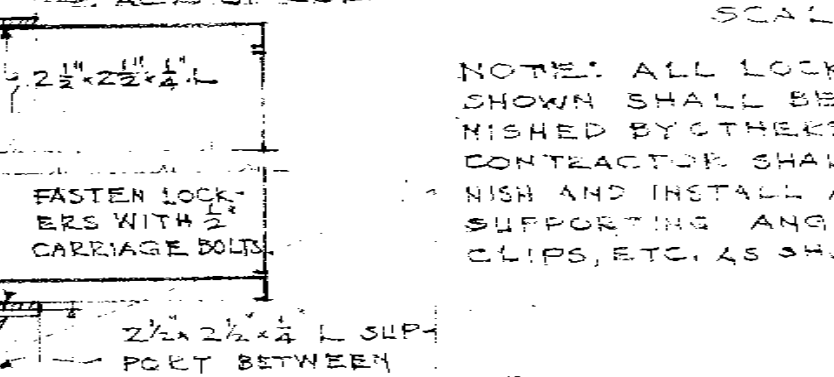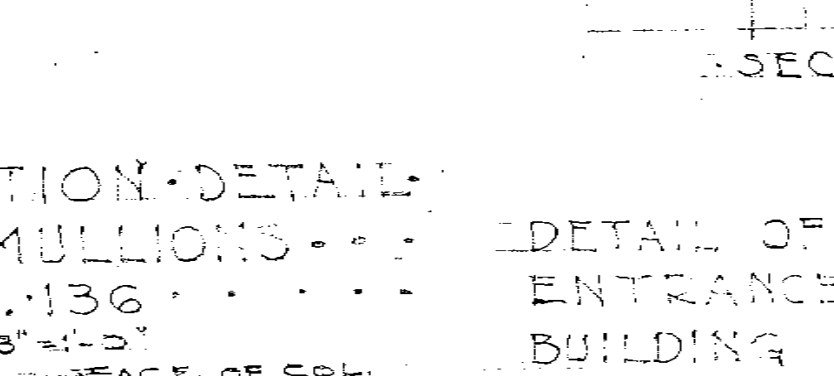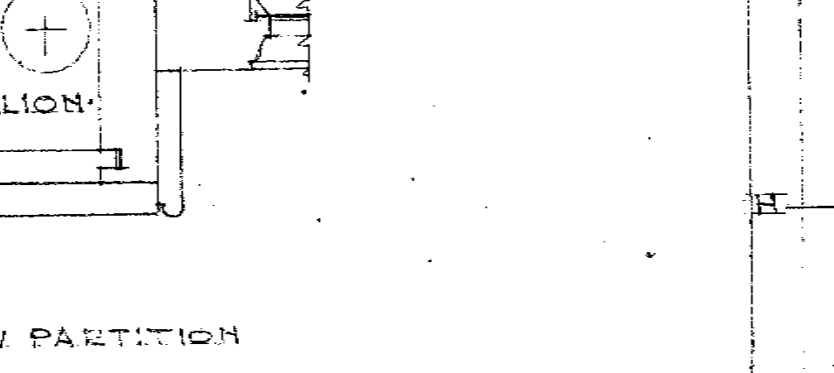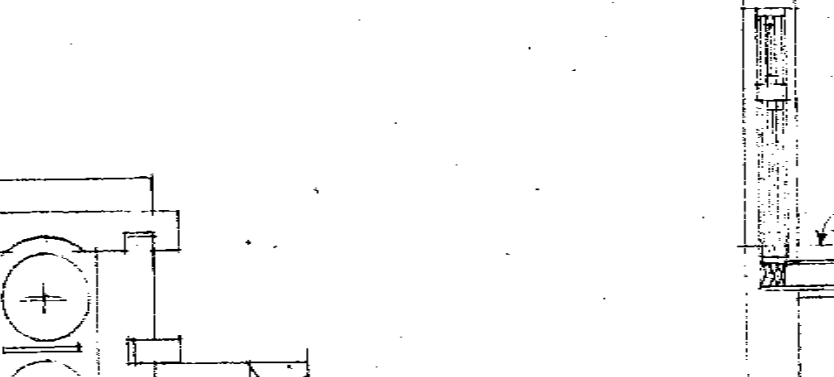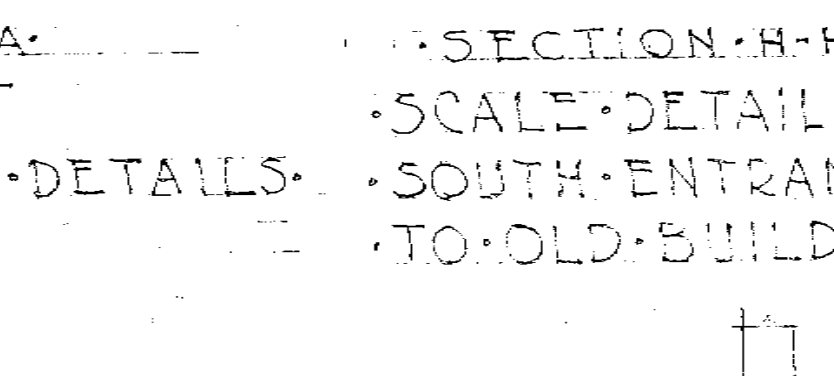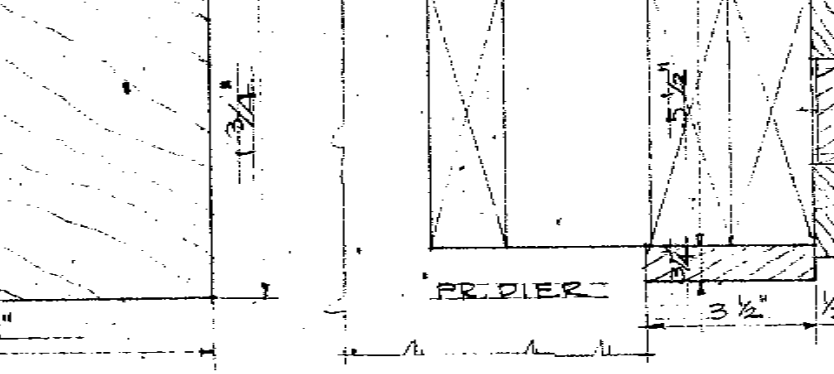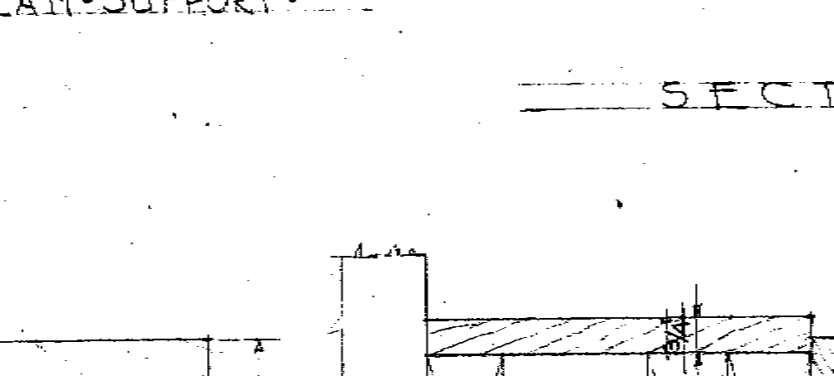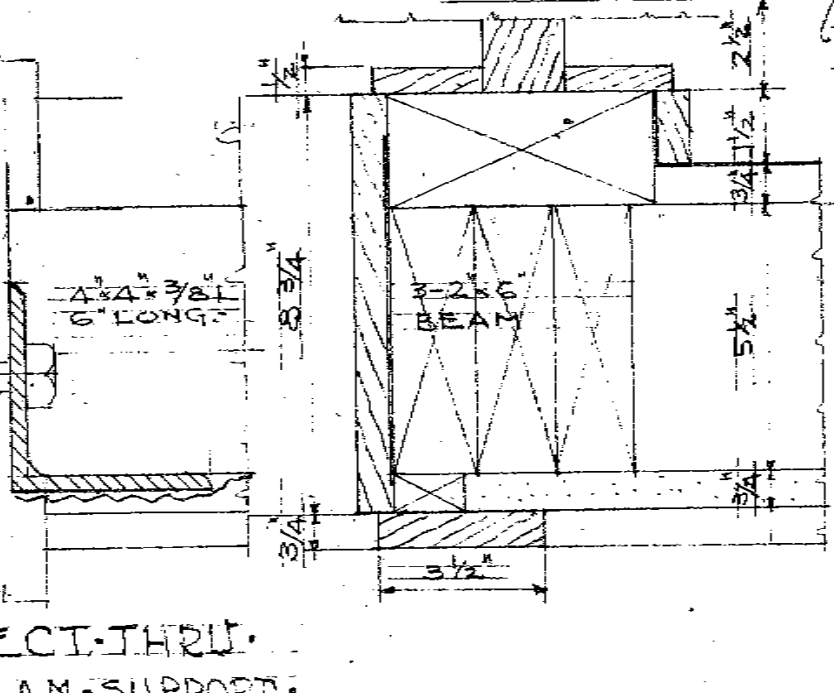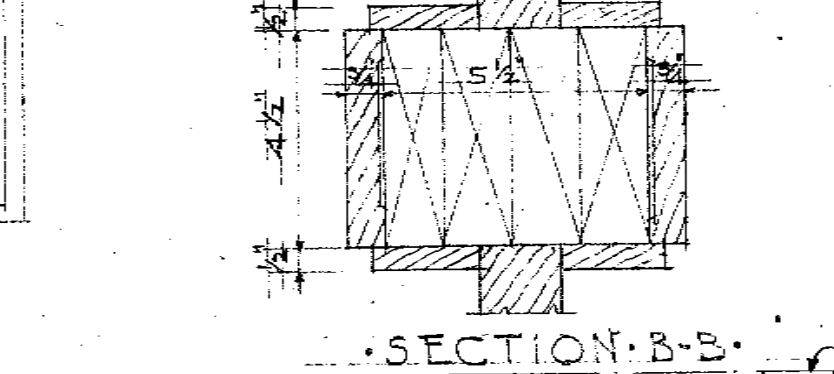
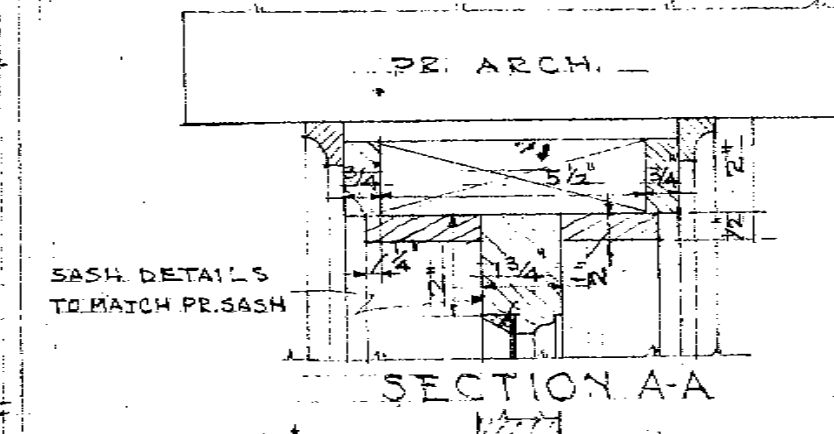


NOTE: FULL SIZE DETAIL FOR EXTERIOR DOORS AND SIDE LIGHTS SHOWN ON DRAWING # 2. SAME AS SHOWN PE 2" DOORS.

NOTE: ALL LOCKERS SHOWN SHALL BE FINISHED BY CONTRACTOR. THIS CONTRACTOR SHALL REFINISH AND INSTALL ALL SUPPORTING ANGLES AND CLIPS, ETC. AS SHOWN.



SEATTLE SCHOOL DIST NO. 1 KING COUNTY, WASHINGTON
LONGFELLOW SCHOOL - ADDN.
FIRST FLOOR PLAN - OLD BUILDING
MISC. ALTERATION DETAILS
DATE: 7/25/40
DRAWN BY: [Signature]
CHECKED BY: [Signature]
APPROVED BY: [Signature]
DATE: 7/25/40

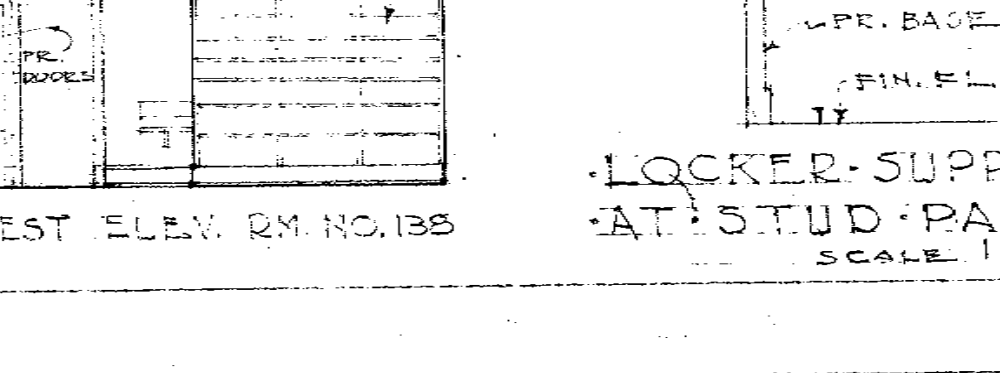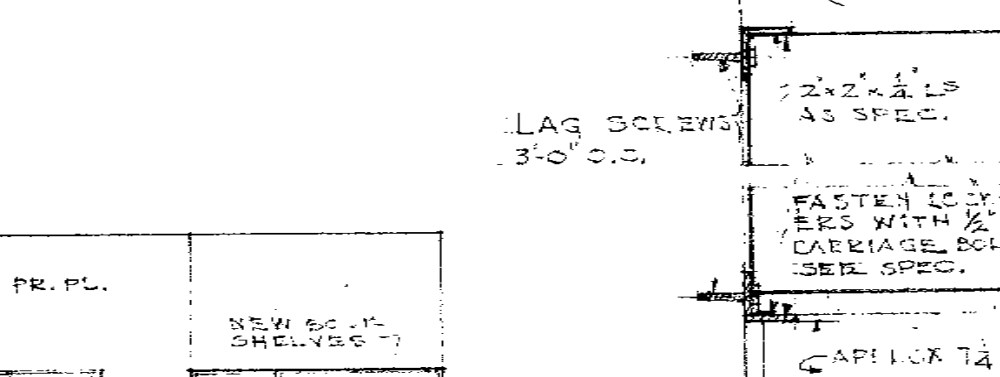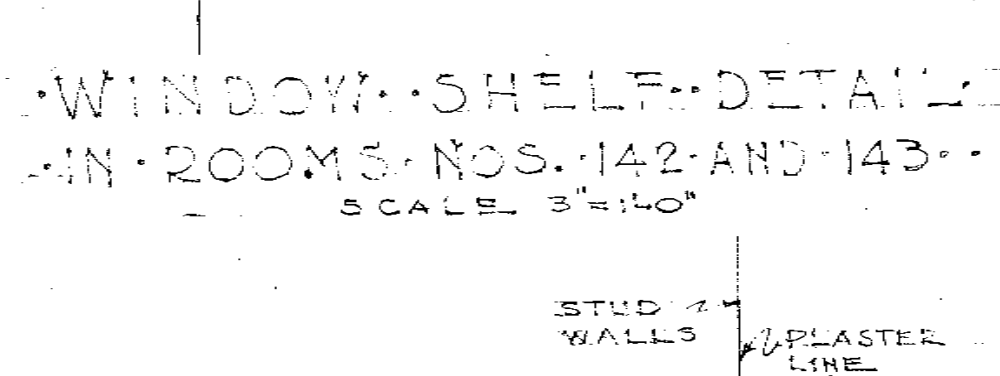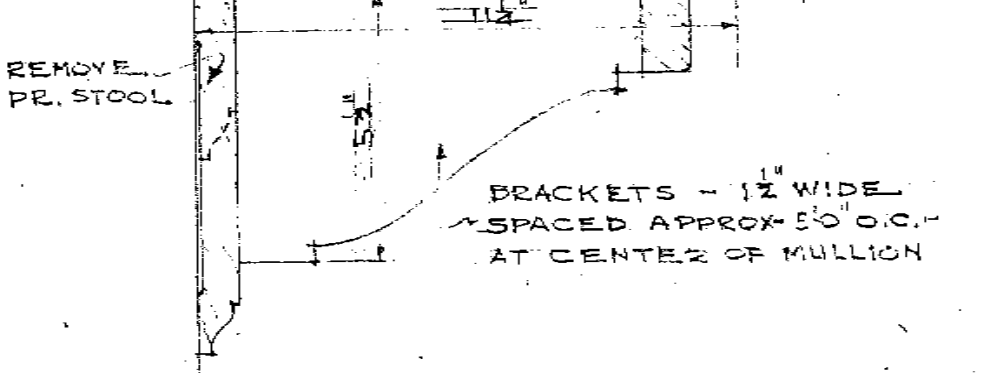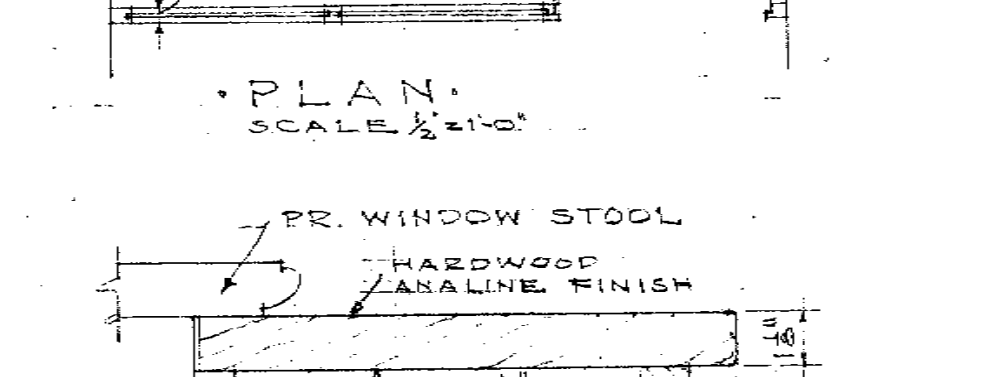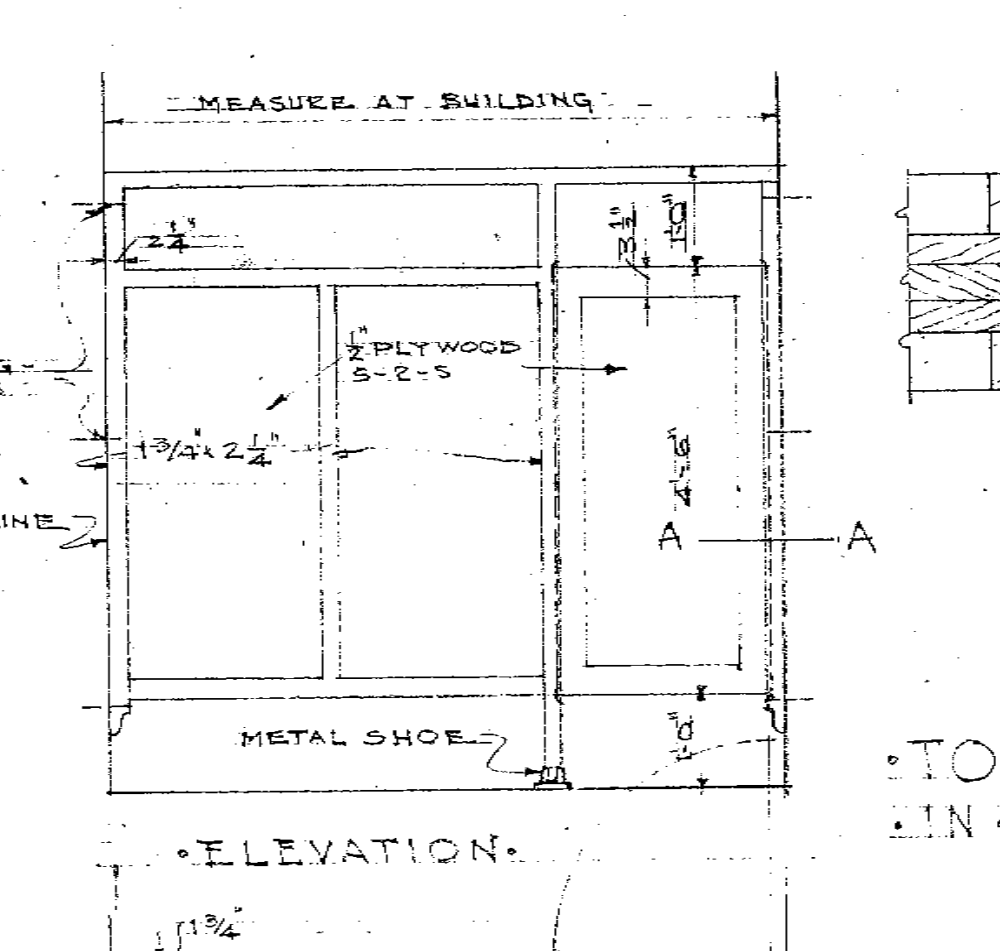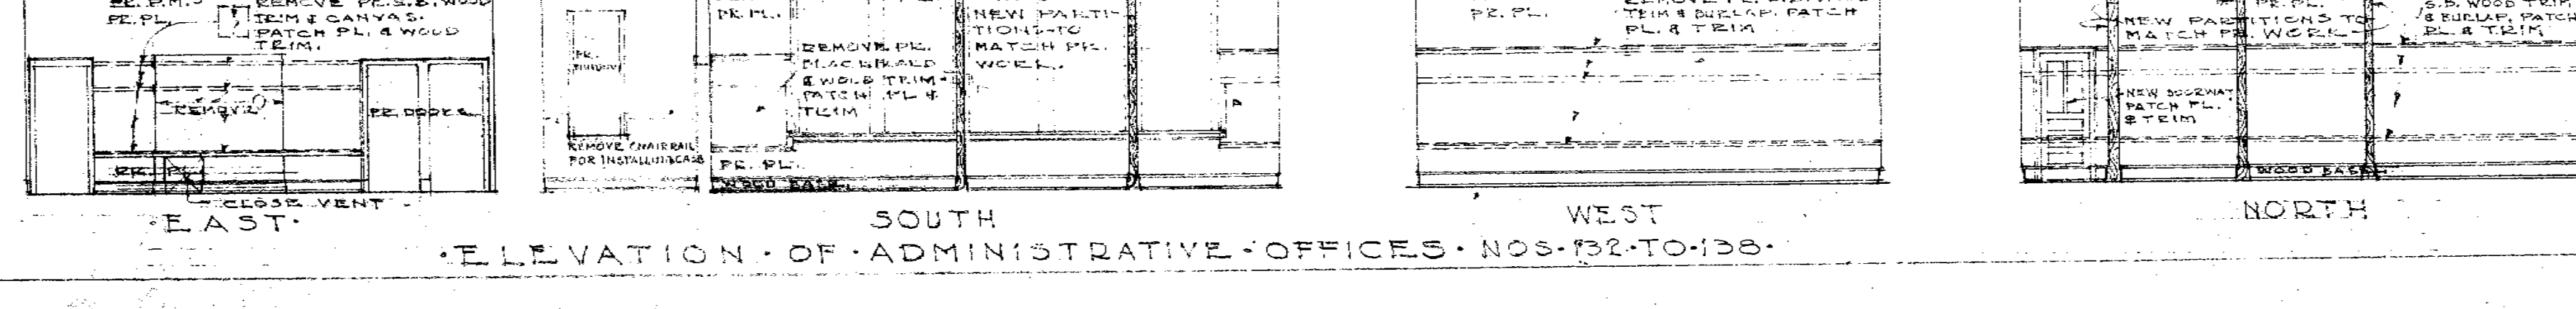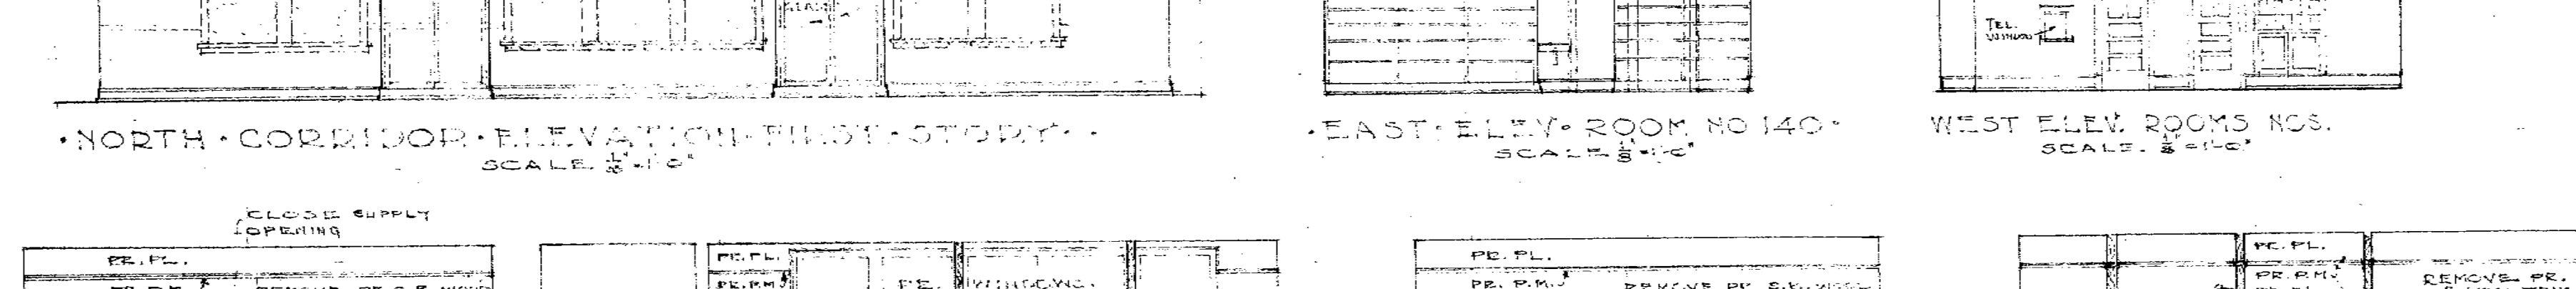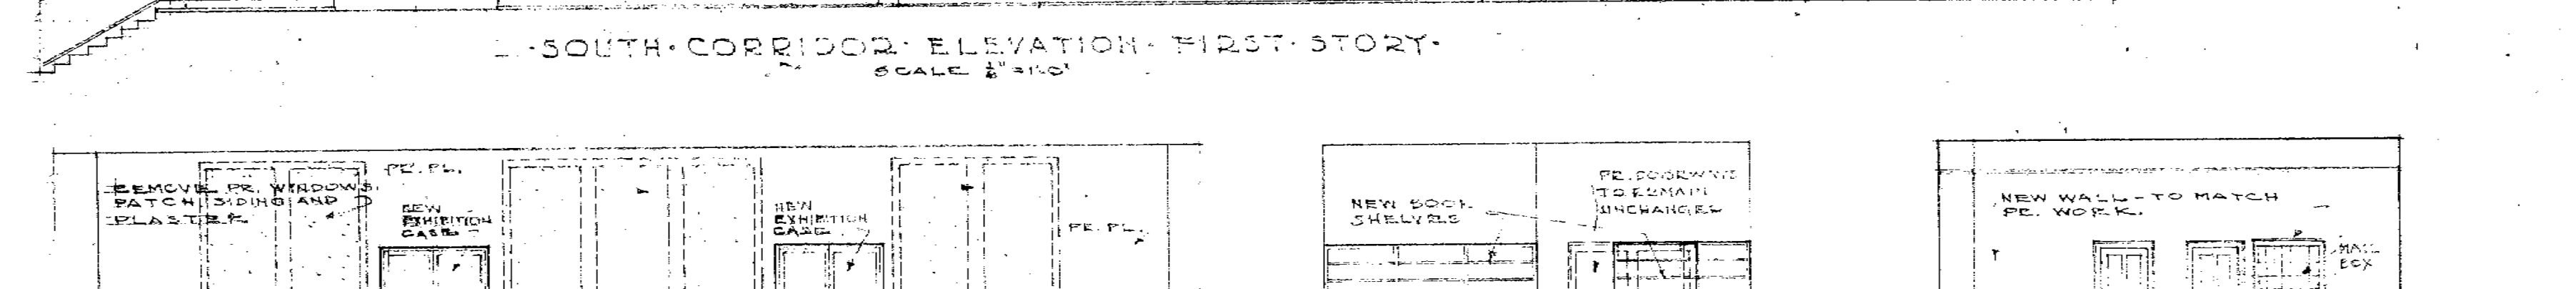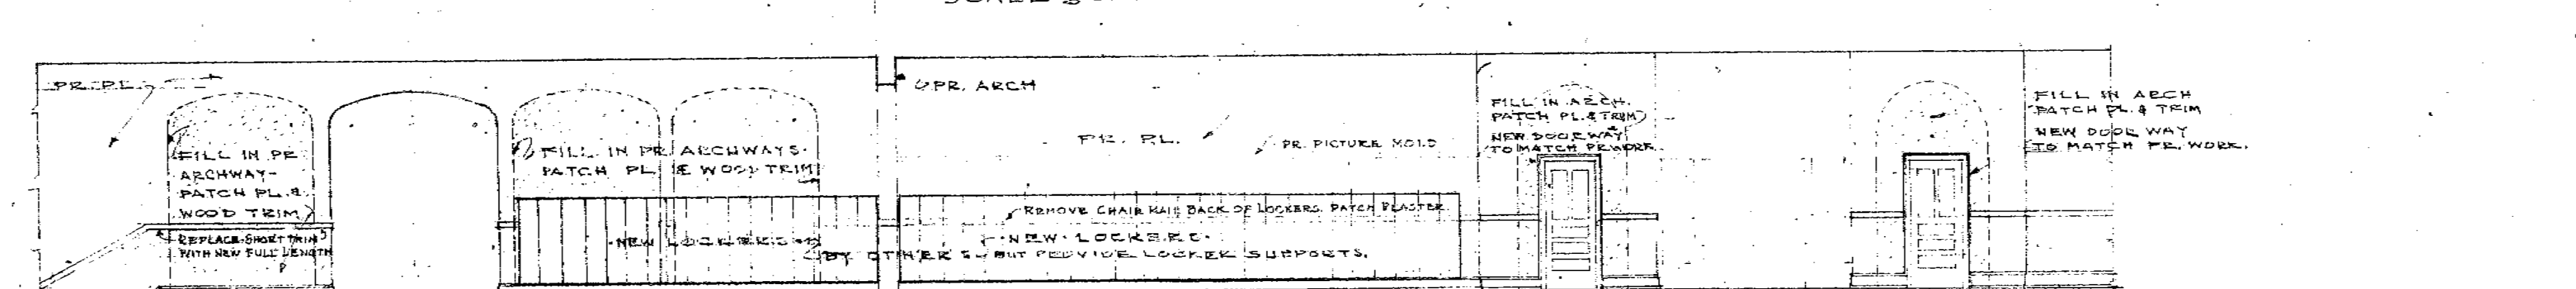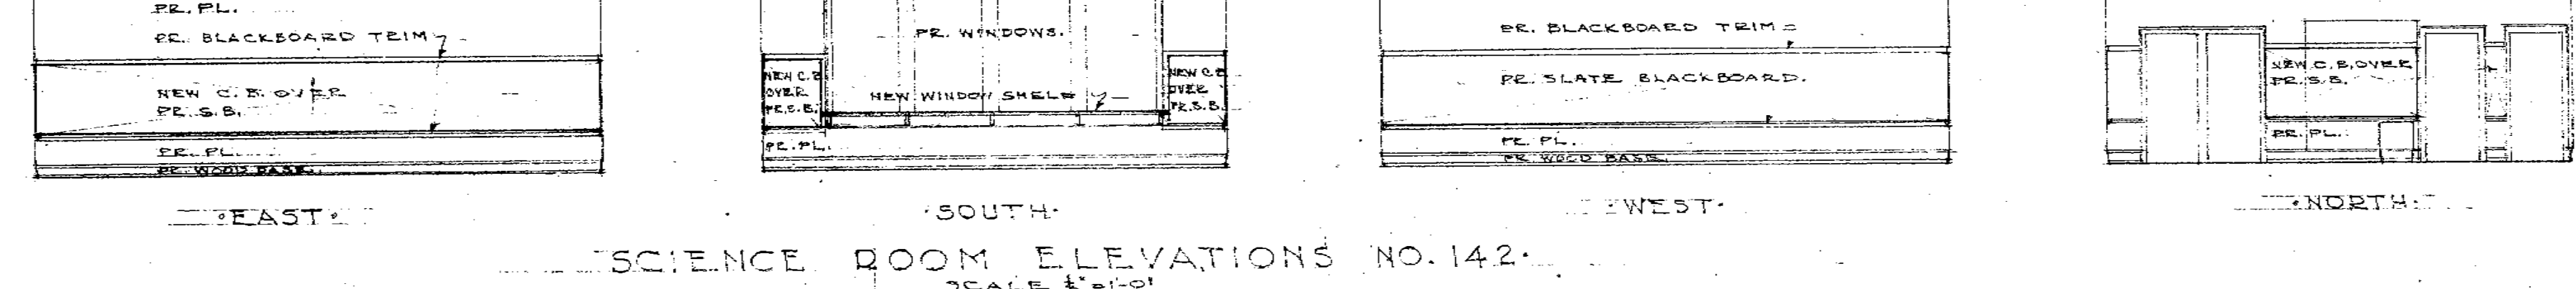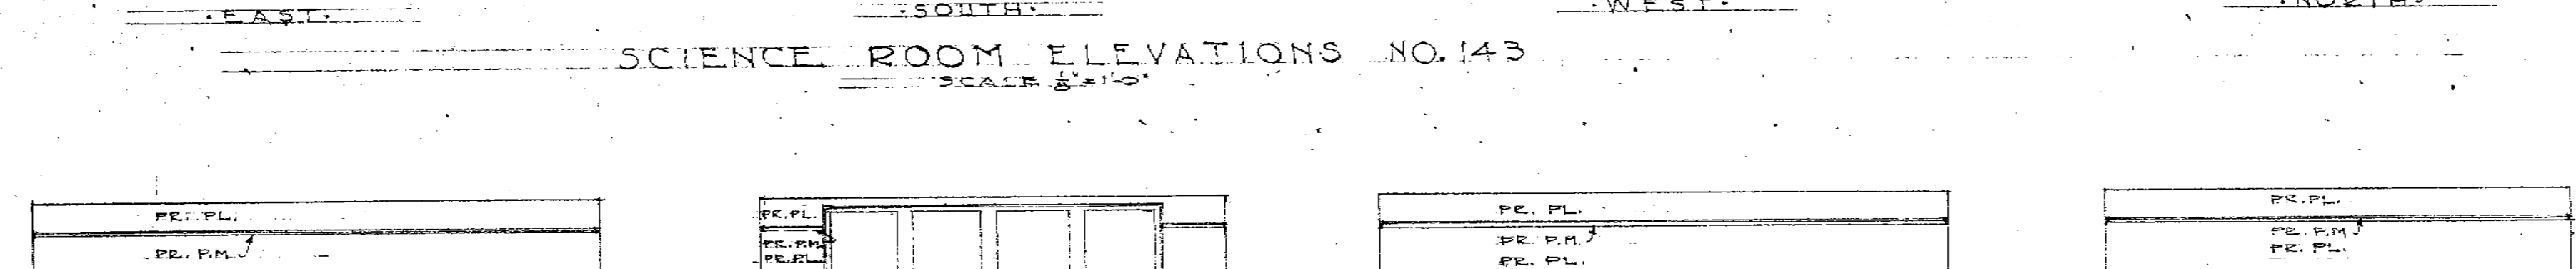
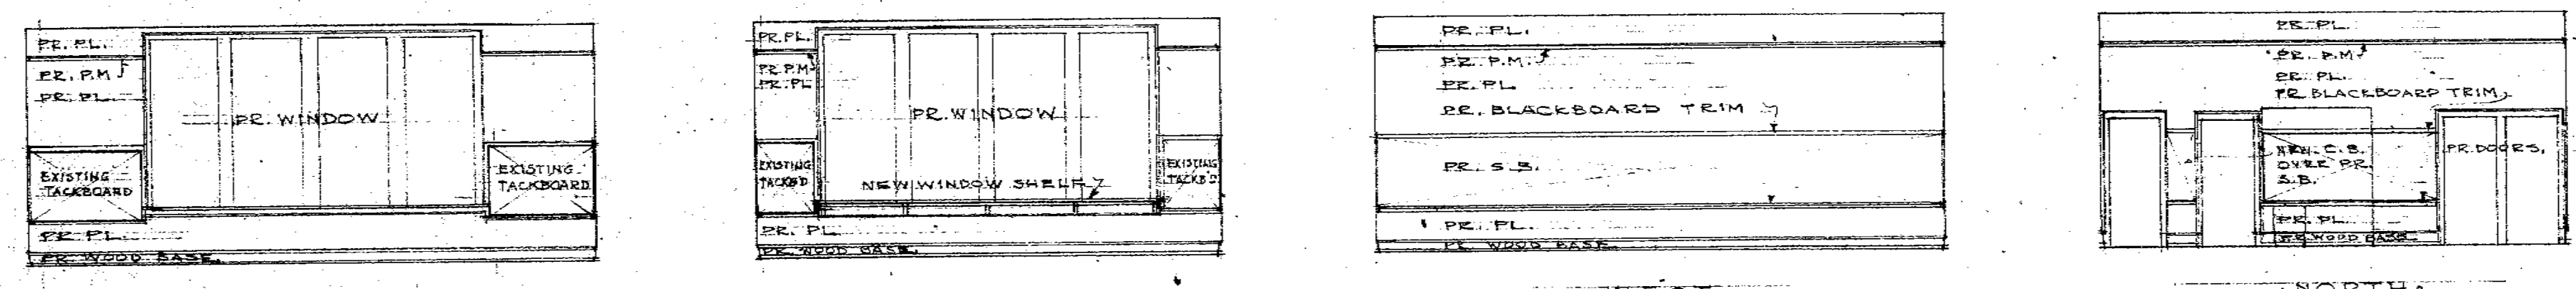






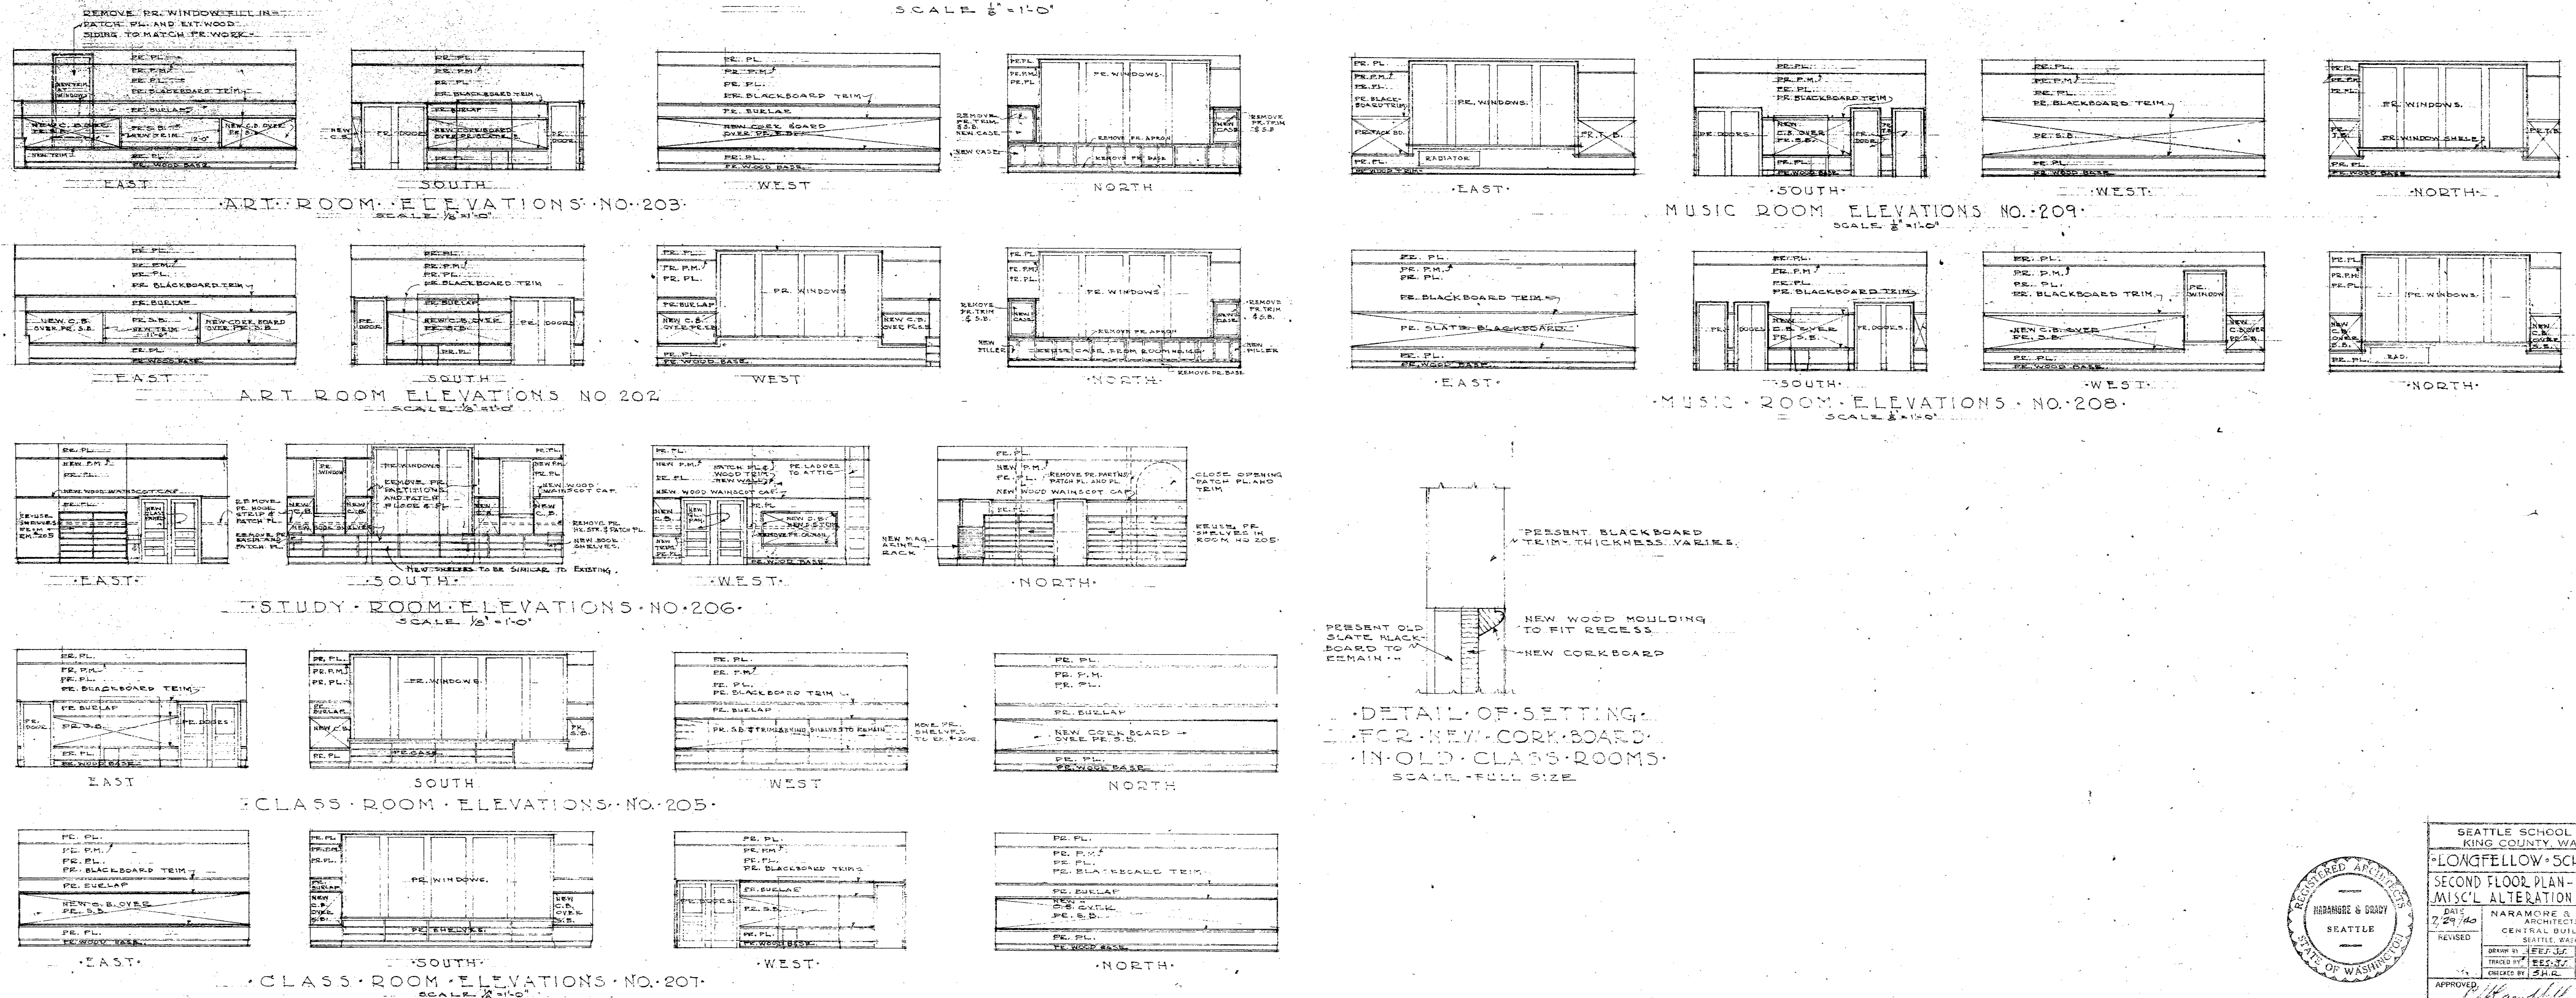
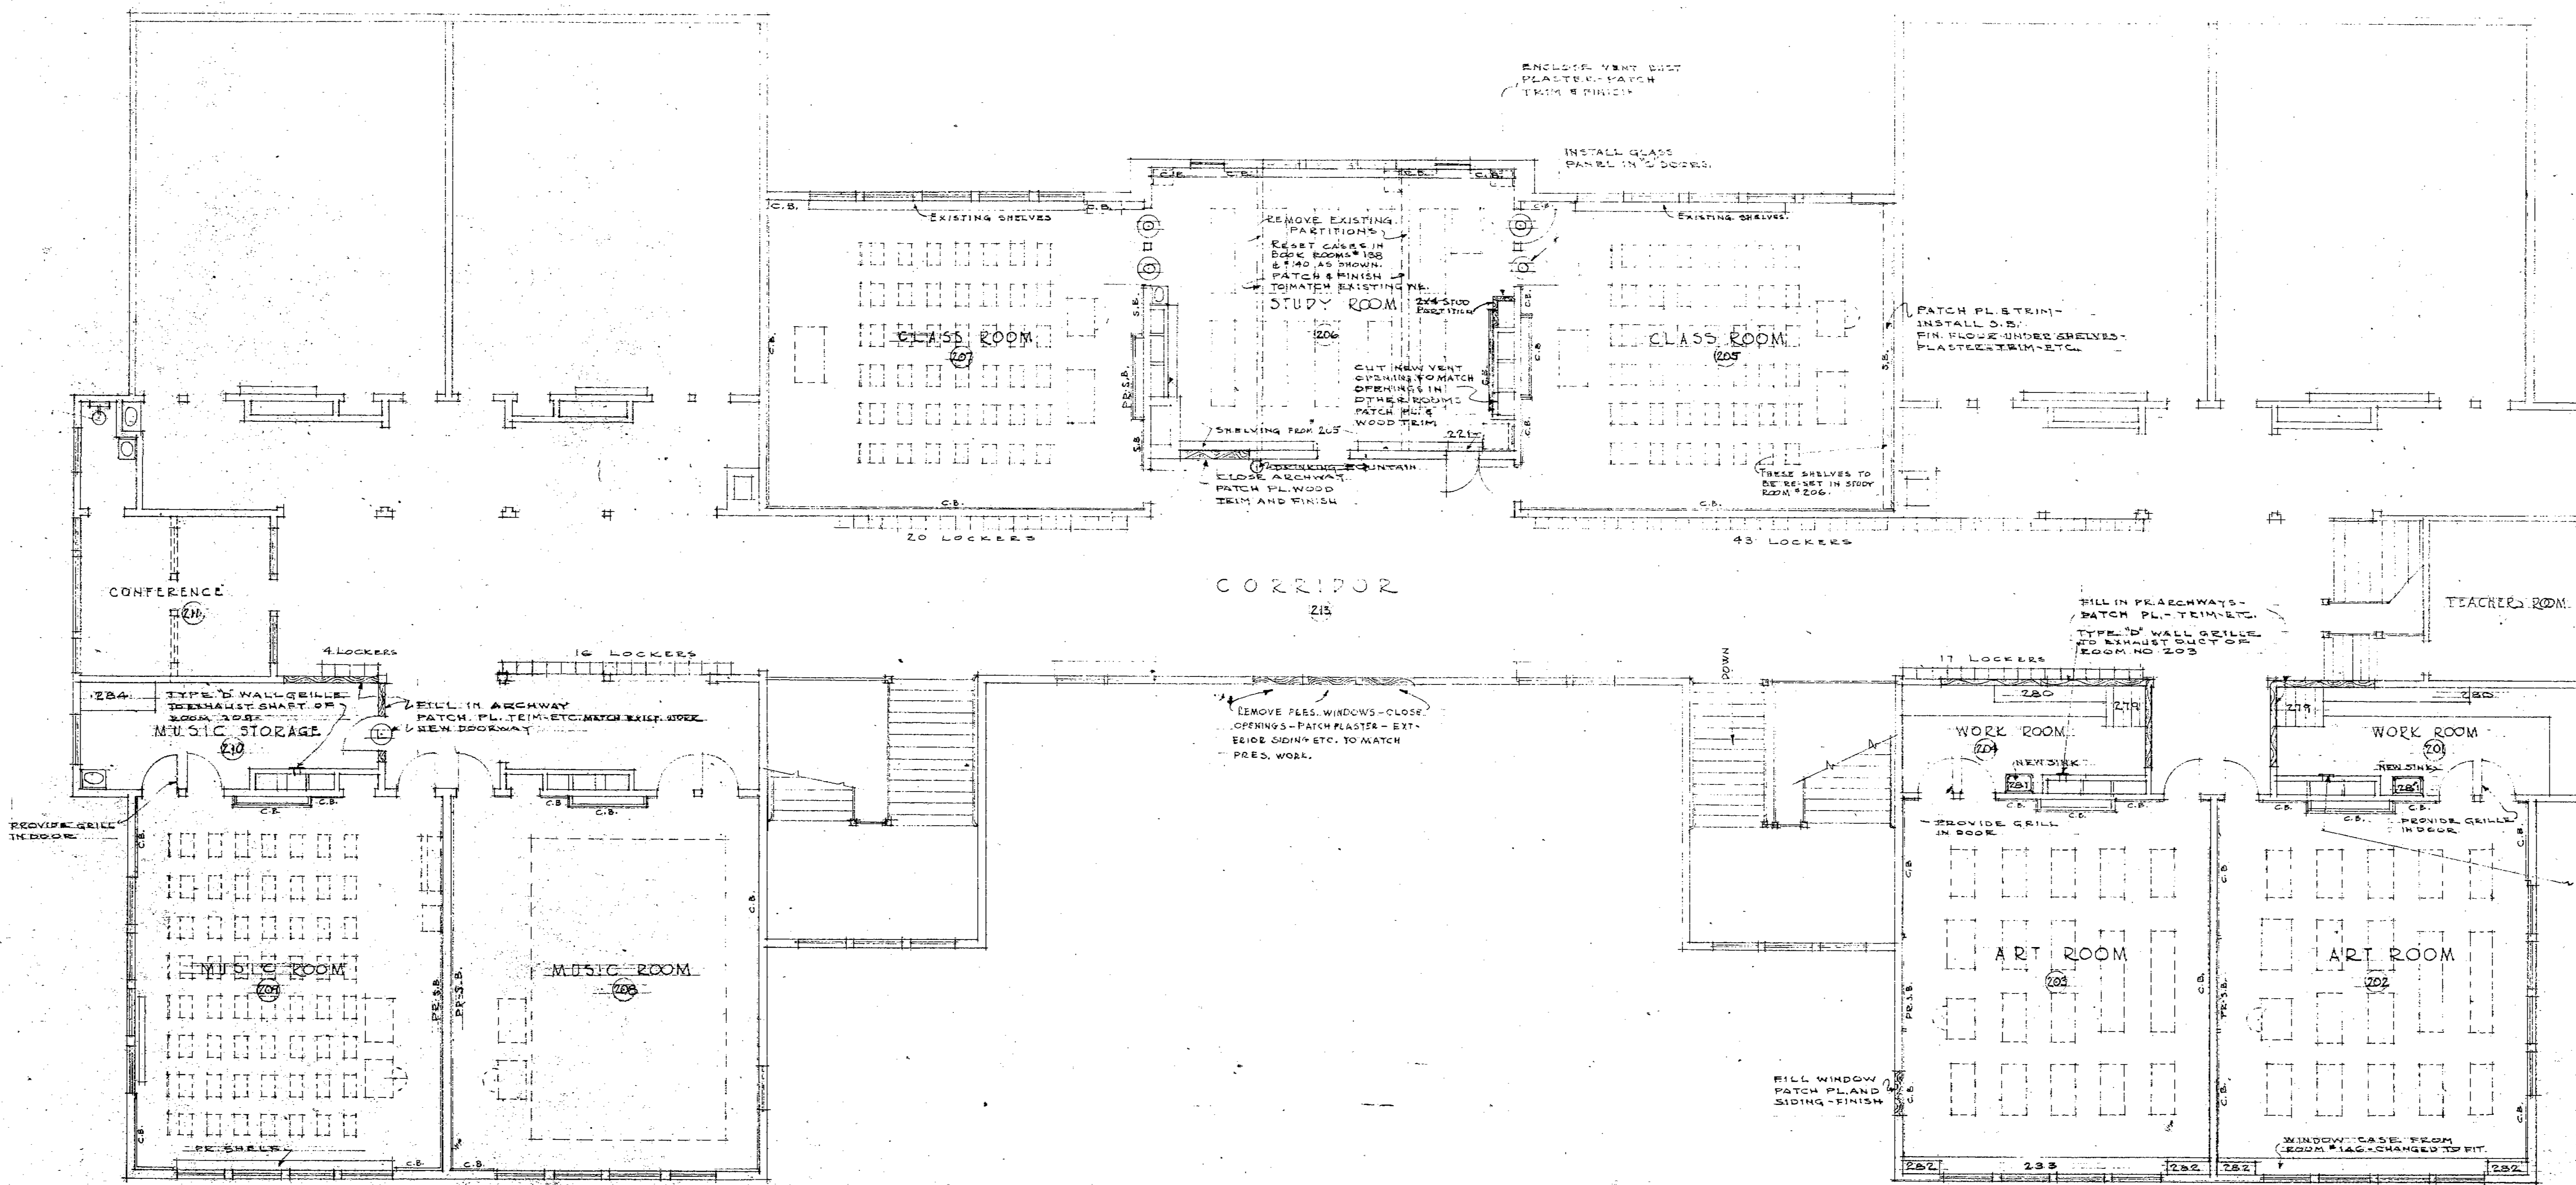






NAME OF ROOM	ROOM NO.	FLOOR	BASE	WAINSCOT	WALLS	CEILING	PAINT	FIN. ON WOOD	FIN. ON WALLS	FIN. ON CEILING	REMARKS
WORK ROOM	201	0	N-F	PB	N-F	N-F	N-F	N-F	N-F	N-F	REMOVE COAT HANG. RE STEPS - PATCH
ART ROOM	202	0	N-F	PB	N-F	N-F	N-F	N-F	N-F	N-F	PATCH WORK. REMOVE WINDOW. RE STEPS - PATCH P.
WORK ROOM	203	0	N-F	PB	N-F	N-F	N-F	N-F	N-F	N-F	REMOVE COAT HANG. RE STEPS - PATCH P.
CLASS RM.	204	0	N-F	PB	N-F	N-F	N-F	N-F	N-F	N-F	REMOVE DOOR SHG. YES AT WEST END.
STUDY RM.	205	0	N-F	PB	N-F	N-F	N-F	N-F	N-F	N-F	REMOVE RE. PLASTER. RE. WOOD STOPS. AND PATCH
CLASS RM.	206	0	N-F	PB	N-F	N-F	N-F	N-F	N-F	N-F	
MUSIC RM.	207	0	N-F	PB	N-F	N-F	N-F	N-F	N-F	N-F	
MUSIC RM.	208	0	N-F	PB	N-F	N-F	N-F	N-F	N-F	N-F	REMOVE COAT HANG. RE STEPS - PATCH P.
MUSIC RM.	209	0	N-F	PB	N-F	N-F	N-F	N-F	N-F	N-F	REMOVE COAT HANG. RE STEPS - PATCH P.
CONFERENCE	210	0	N-F	PB	N-F	N-F	N-F	N-F	N-F	N-F	REMOVE COAT HANG. RE STEPS - PATCH P.
CORRIDOR	211	0	N-F	PB	N-F	N-F	N-F	N-F	N-F	N-F	REMOVE COAT HANG. RE STEPS - PATCH P.

  NOTE:
SEE GENERAL NOTE FOR SCHEDULE ON FIRST FLOOR PLAN SHEET NO. 11. THIS NOTE SHALL APPLY TO WORK SCHEDULED ON THIS SHEET ALSO.







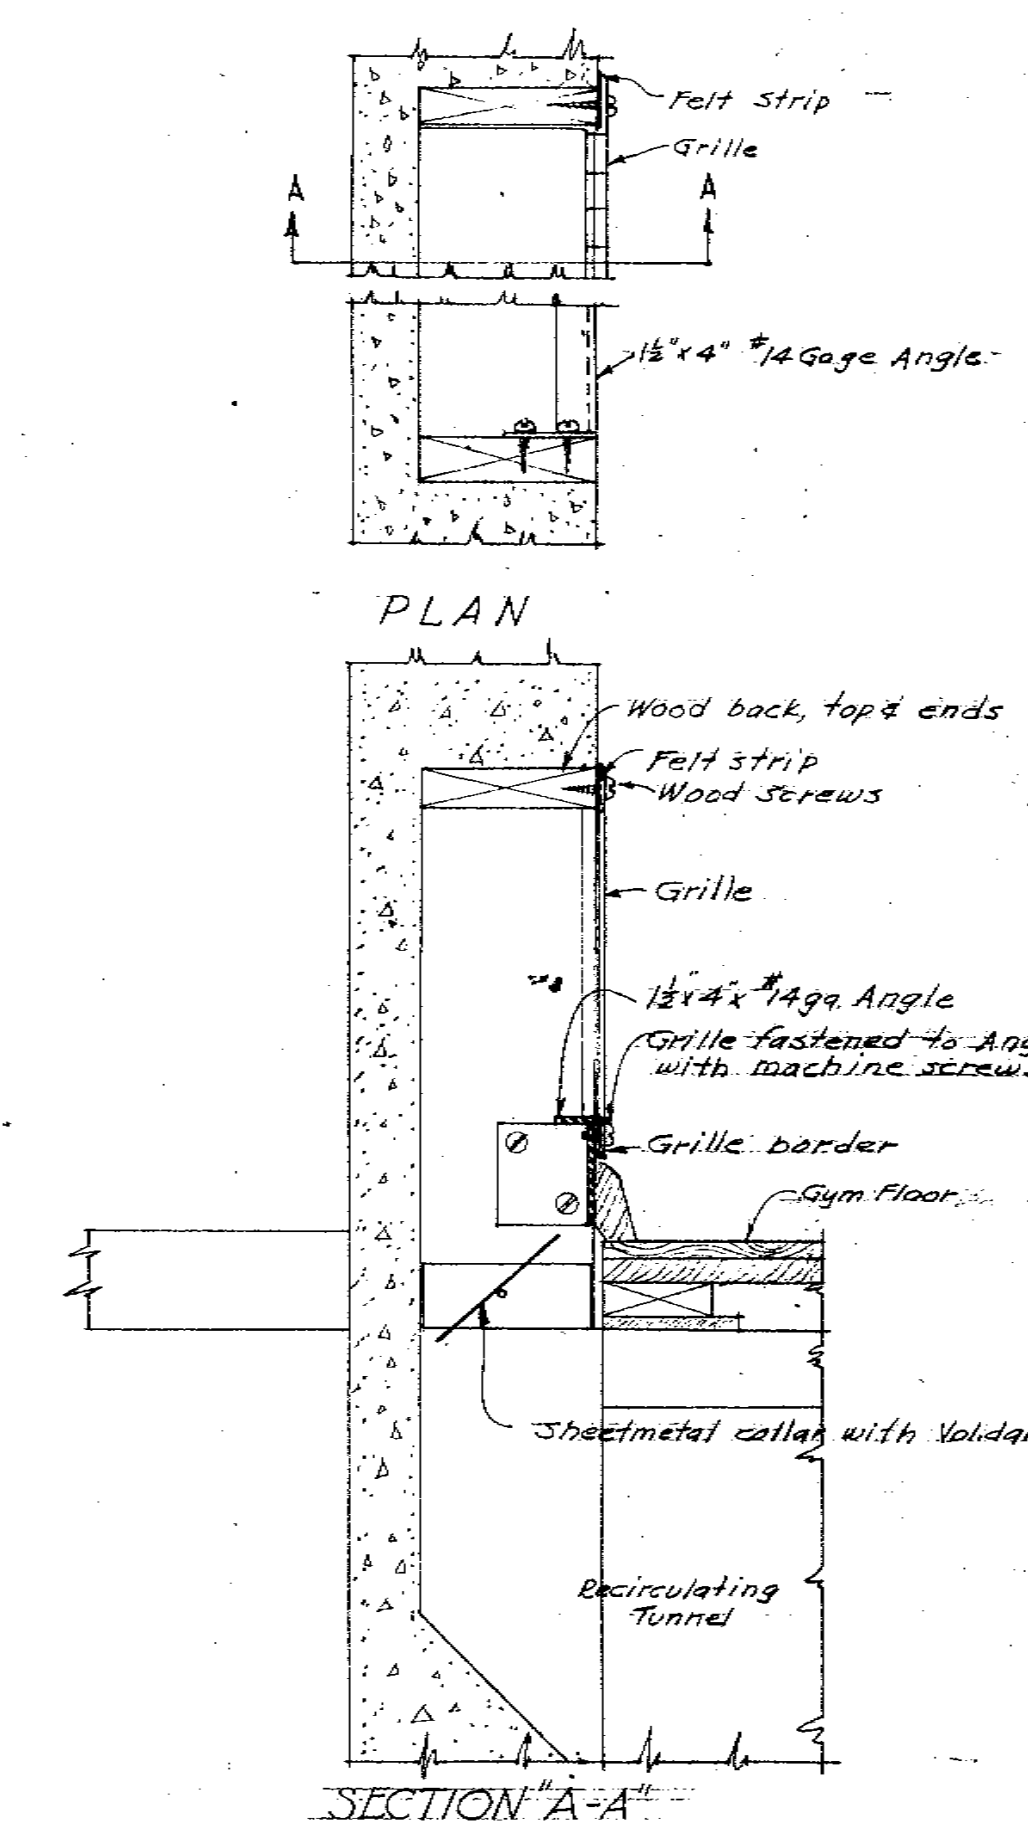
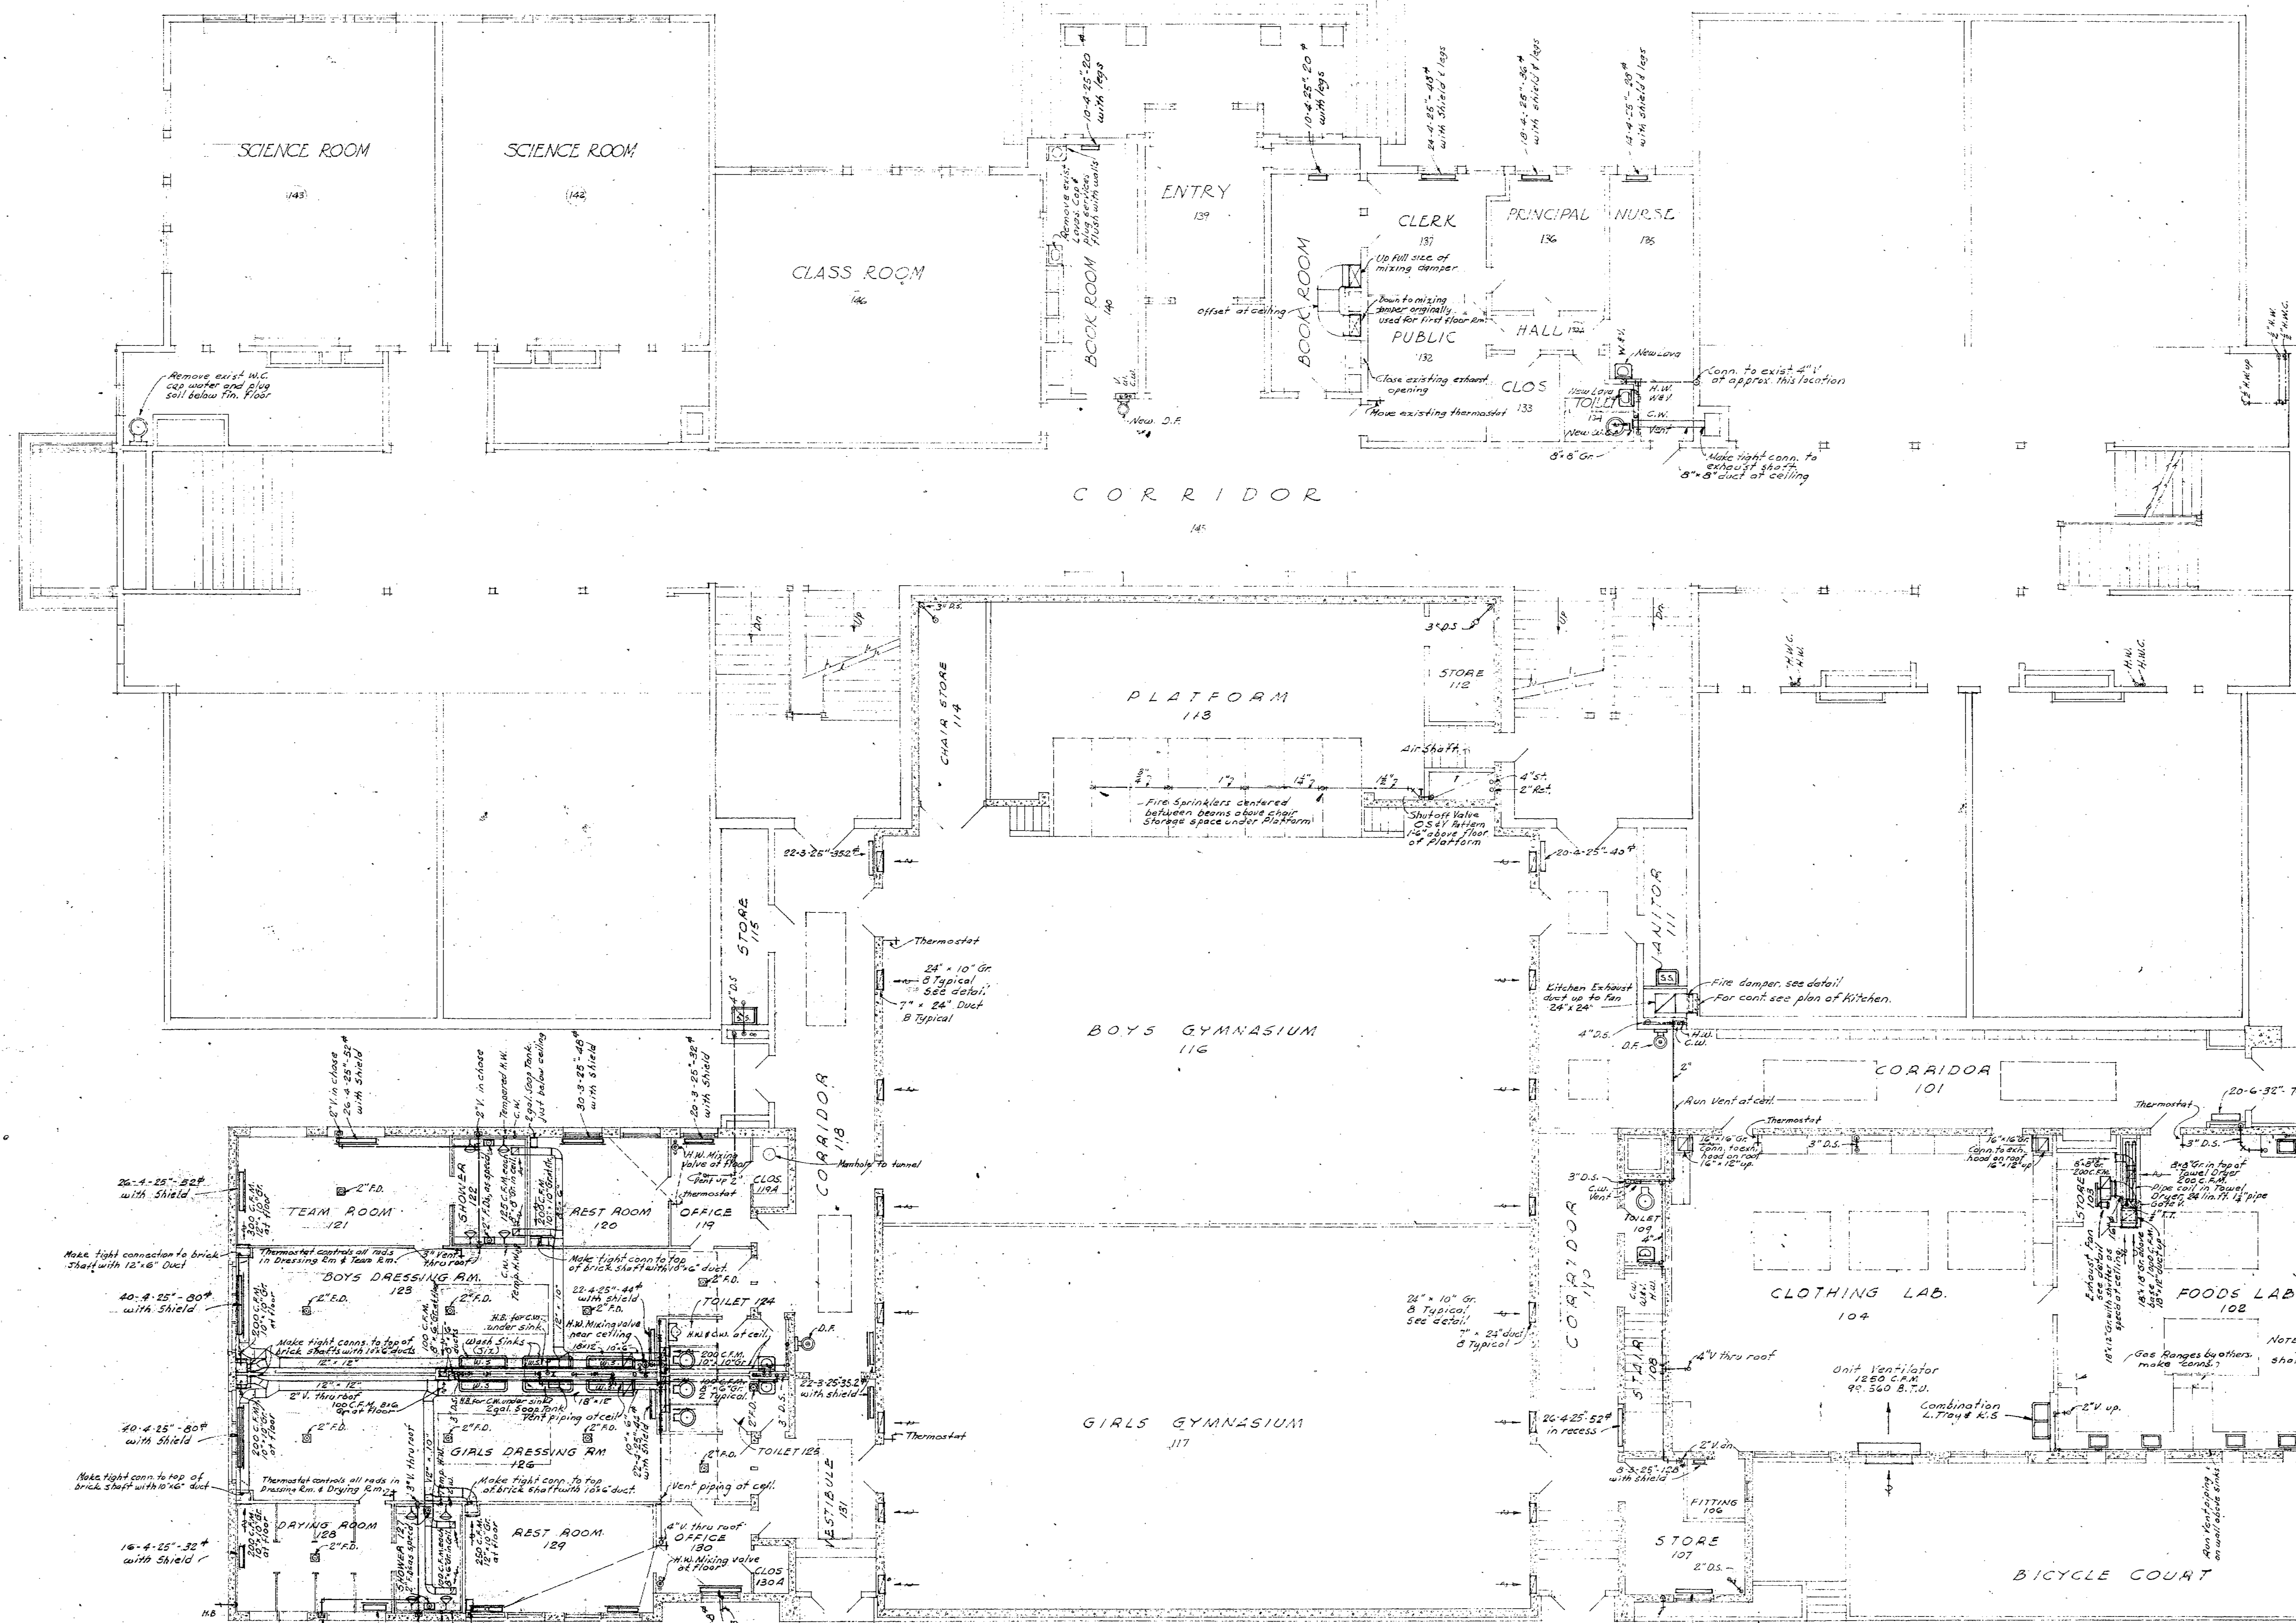



PLUMBING FIXTURE SCHEDULE					
SYMBOL PLAN	FIXTURE	WATER SOIL	VENT	COLD WATER	HOT WATER
	Water closet, floor type	4"	2"	1"	
	Urinal, wall type	2"	2"	2"	
	Lavatory	2"	2"	1/2"	1/2"
	Sink	2"	2"	1/2"	1/2"
	Slop sink	2"	2"	1/2"	1/2"
	Drinking fountain, furnish	2"	2"	1/2"	
	Shower			1/2"	1/2"
	Floor drain	As shown	As shown		
	Hose bibb				
	Gong Drinking Fountain	2"	2"	1/2"	
	Wash Sink	2"	2"	—	1/2" temp.

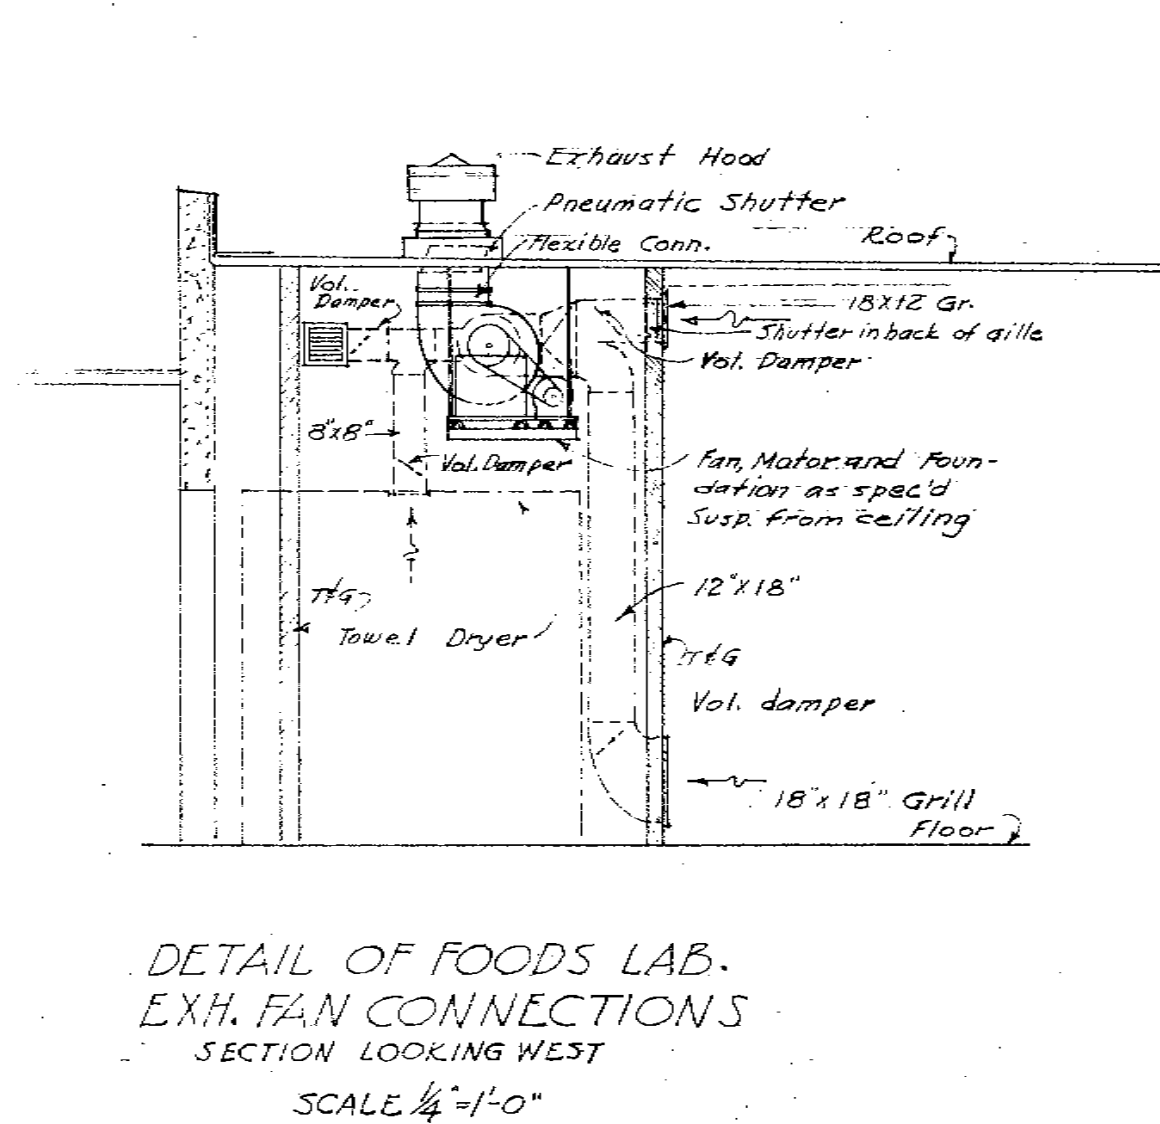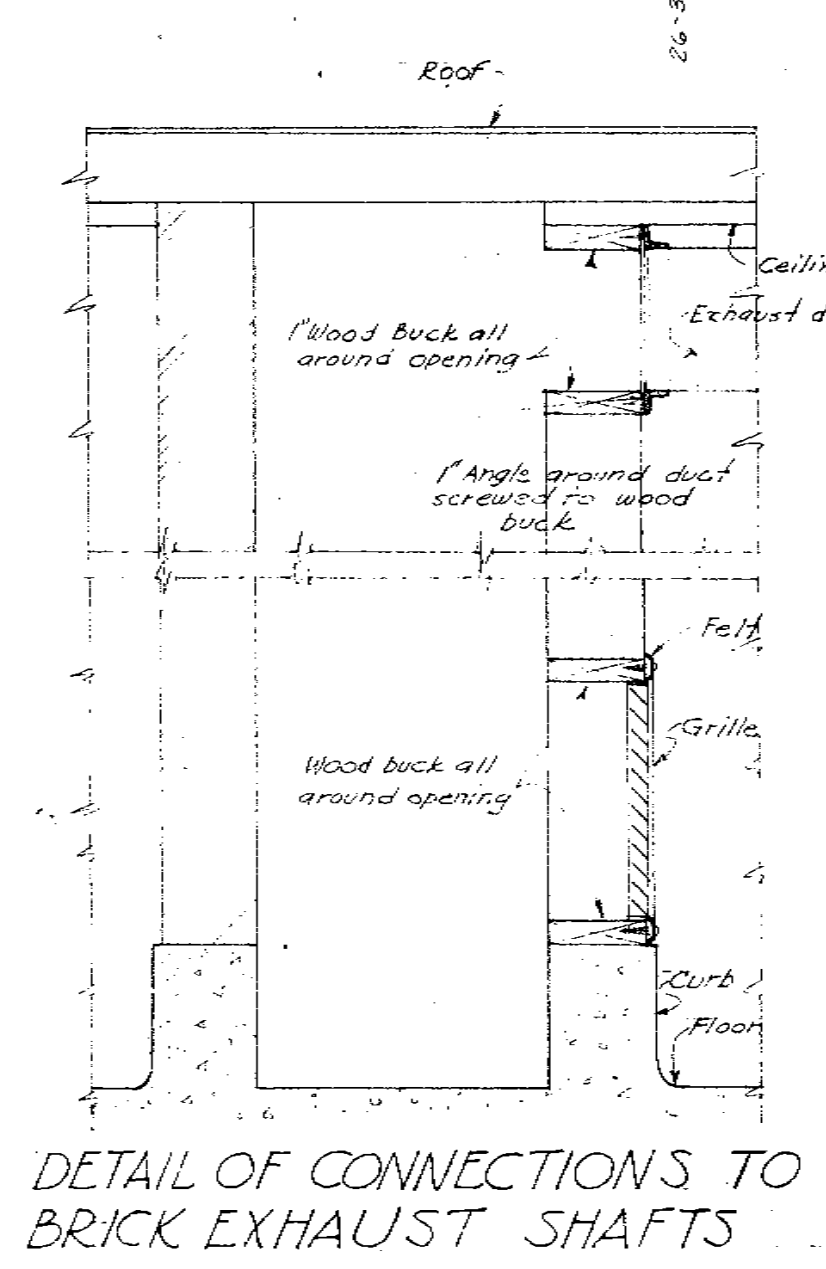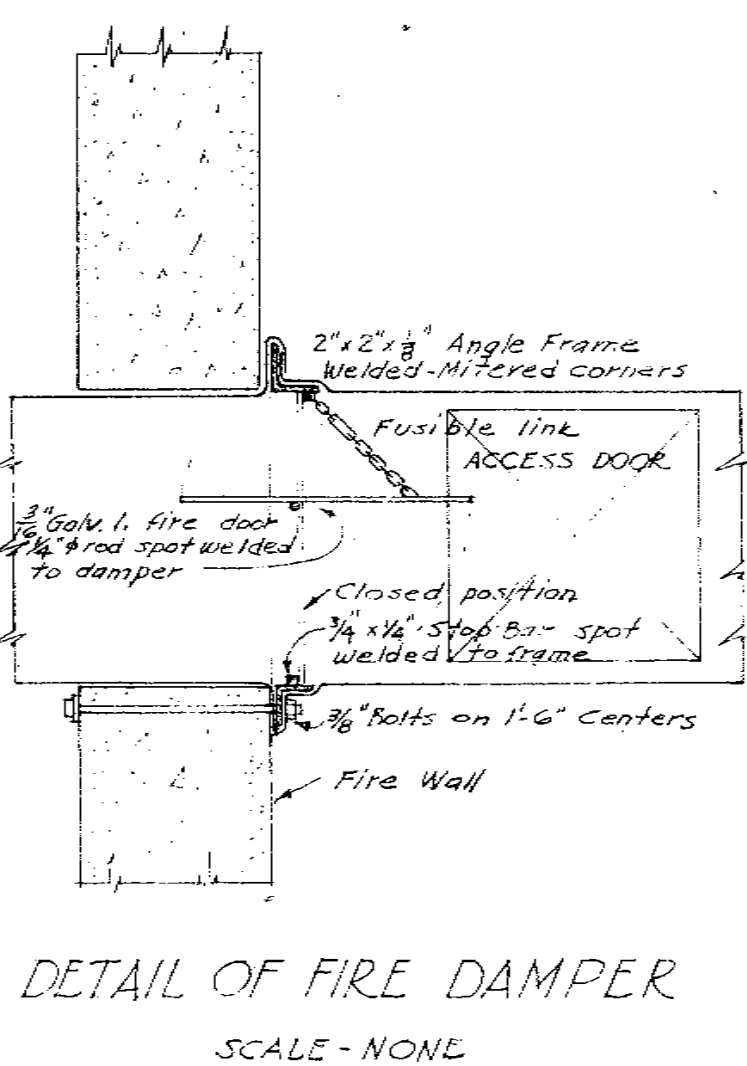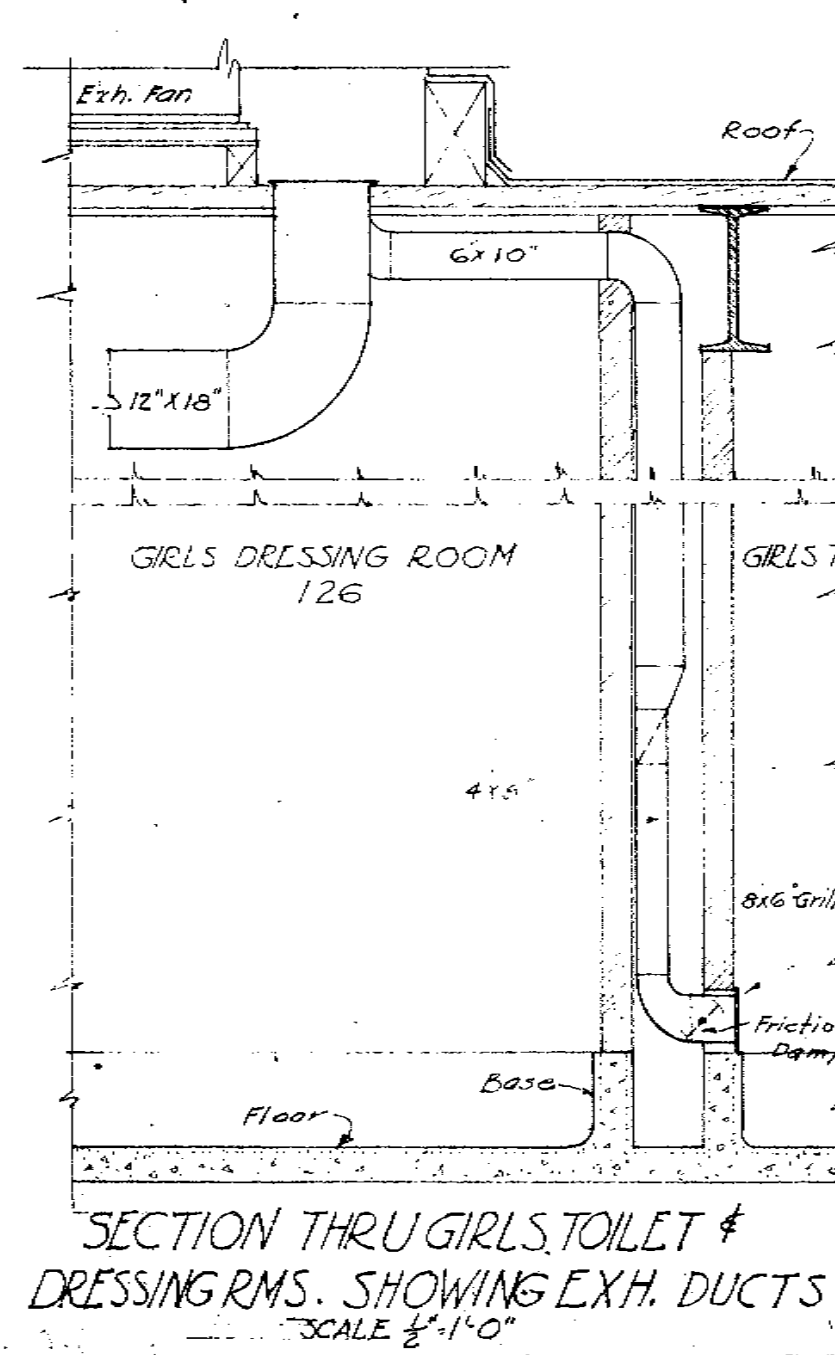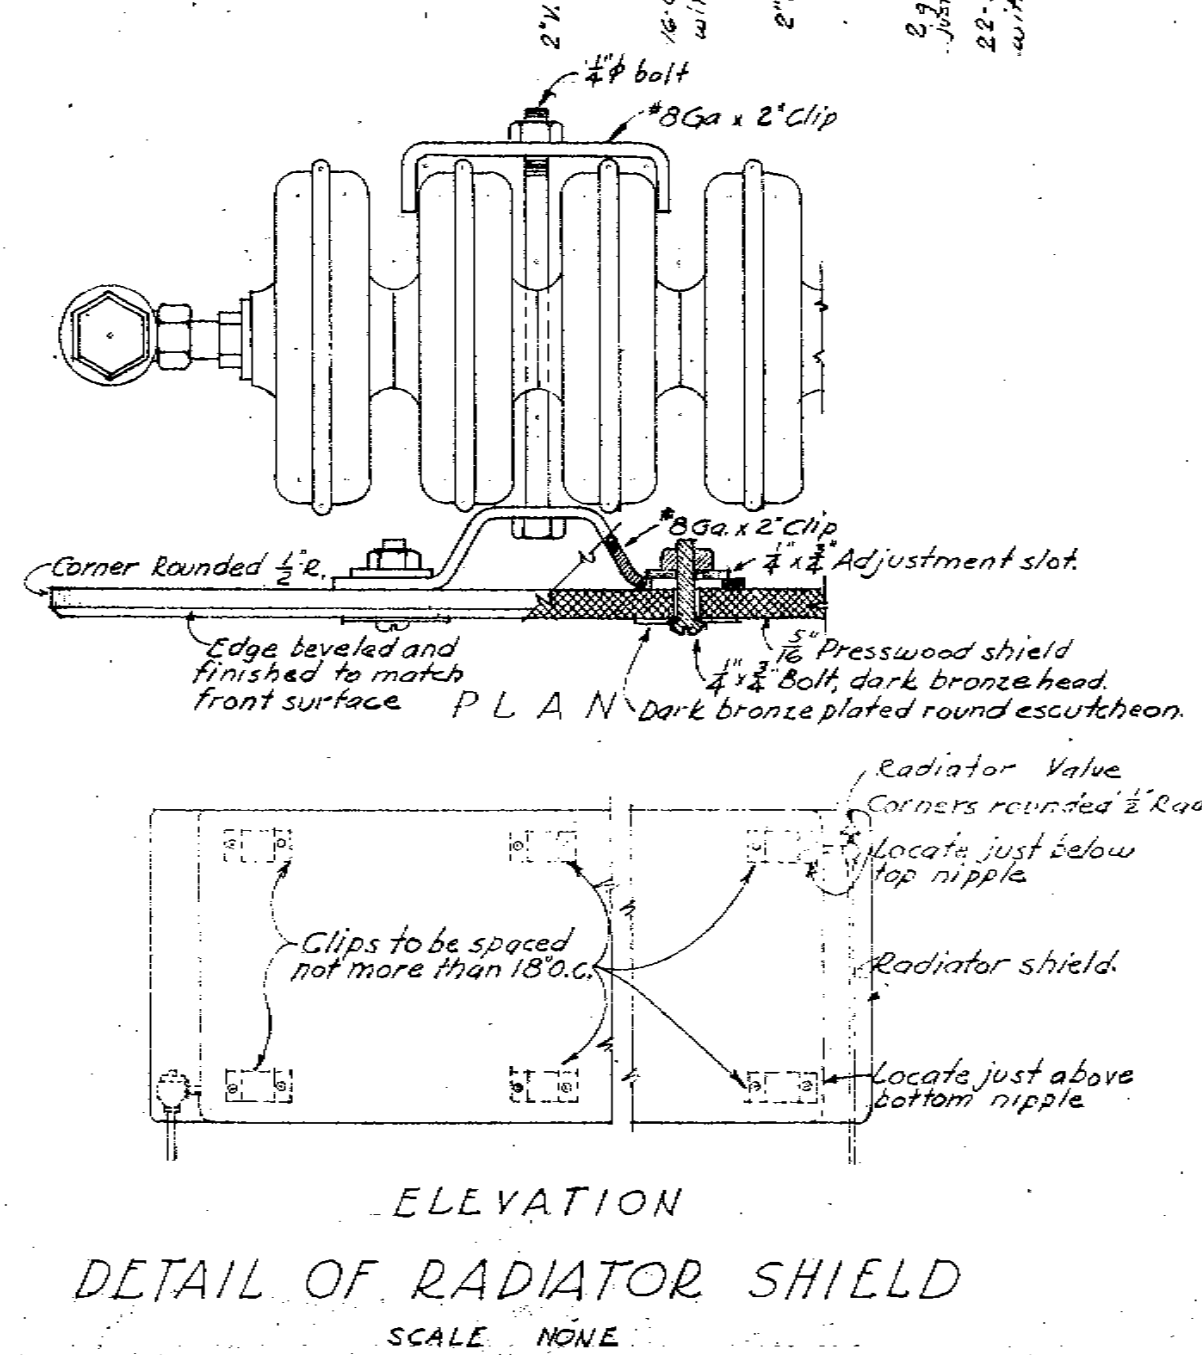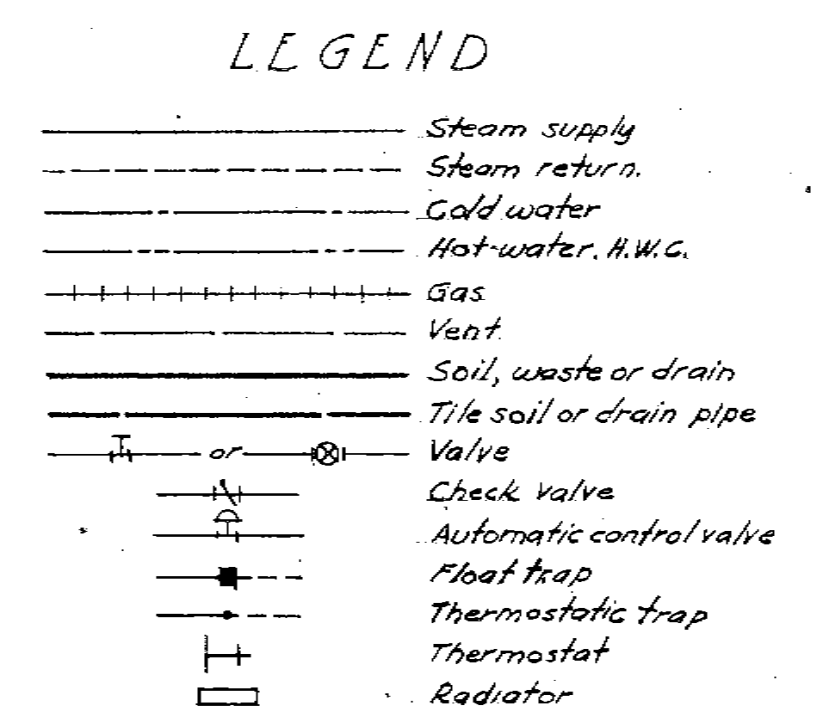

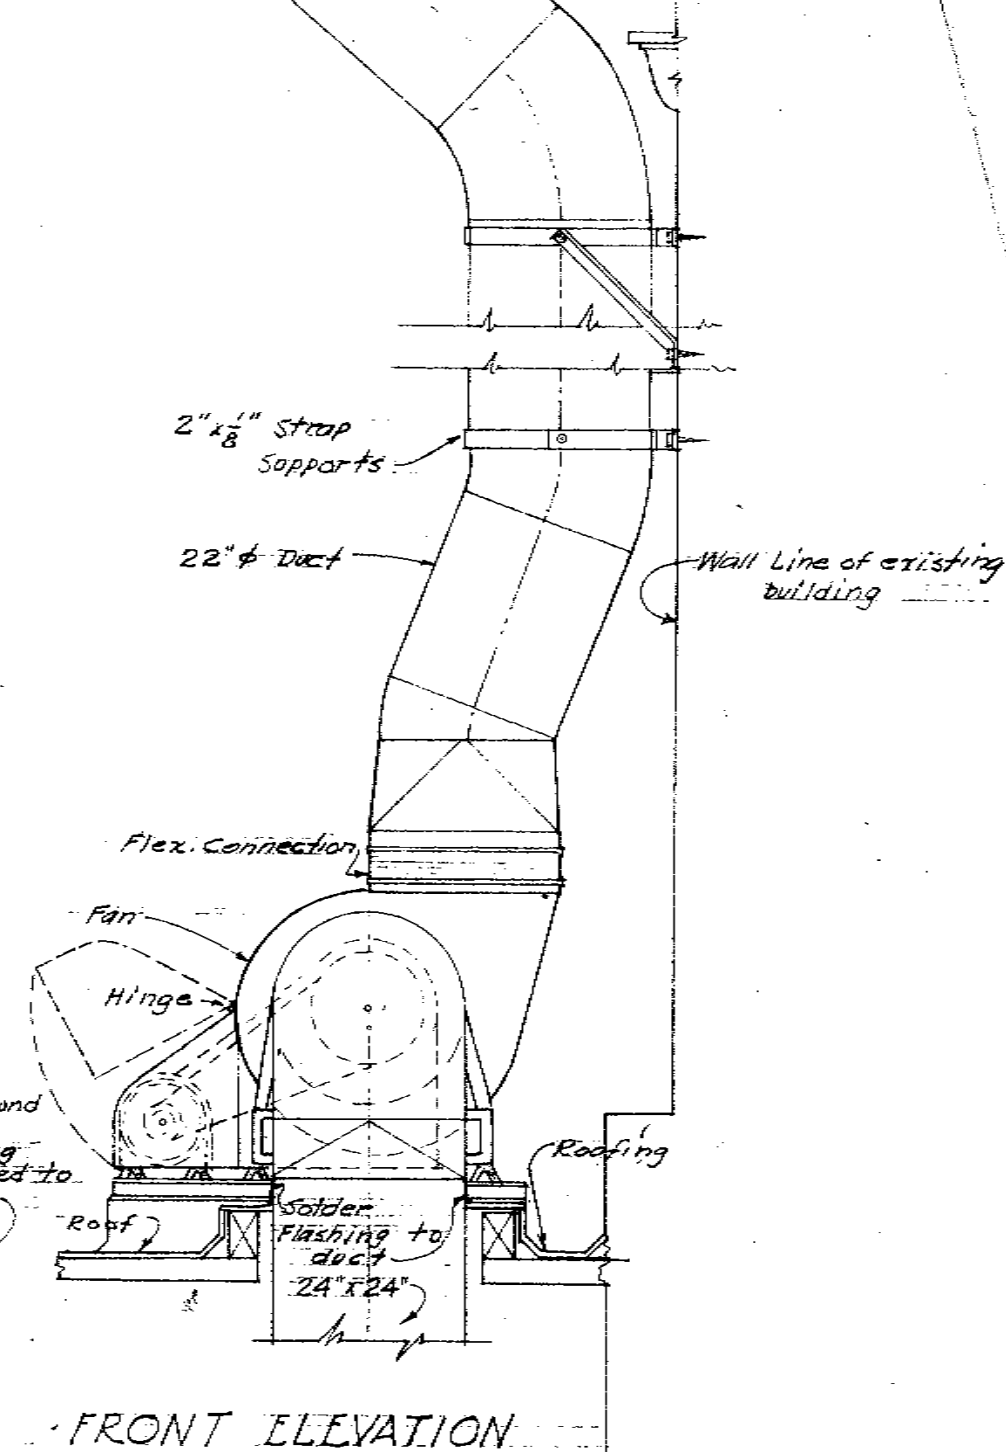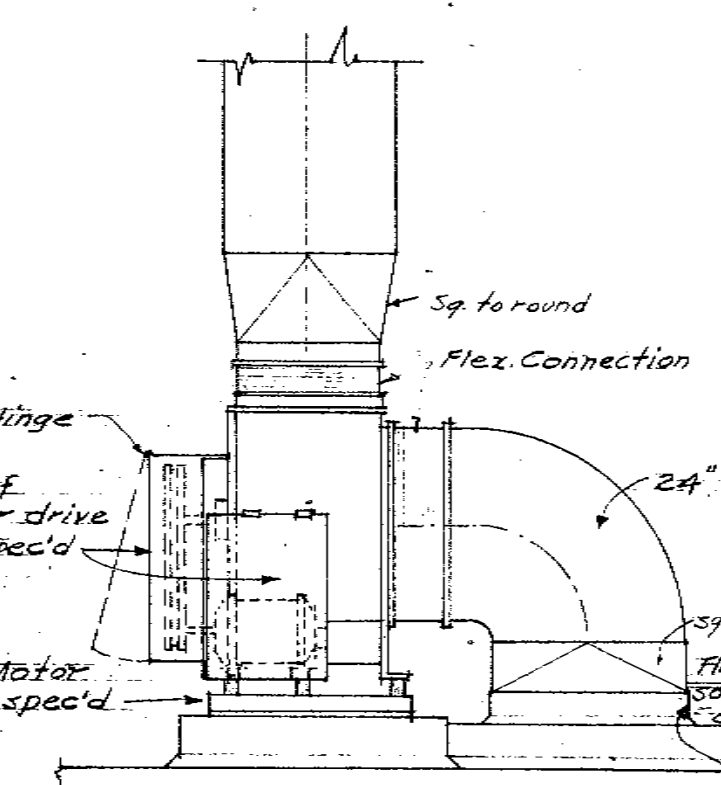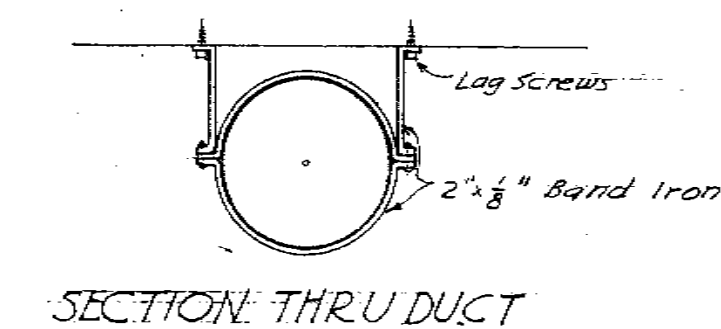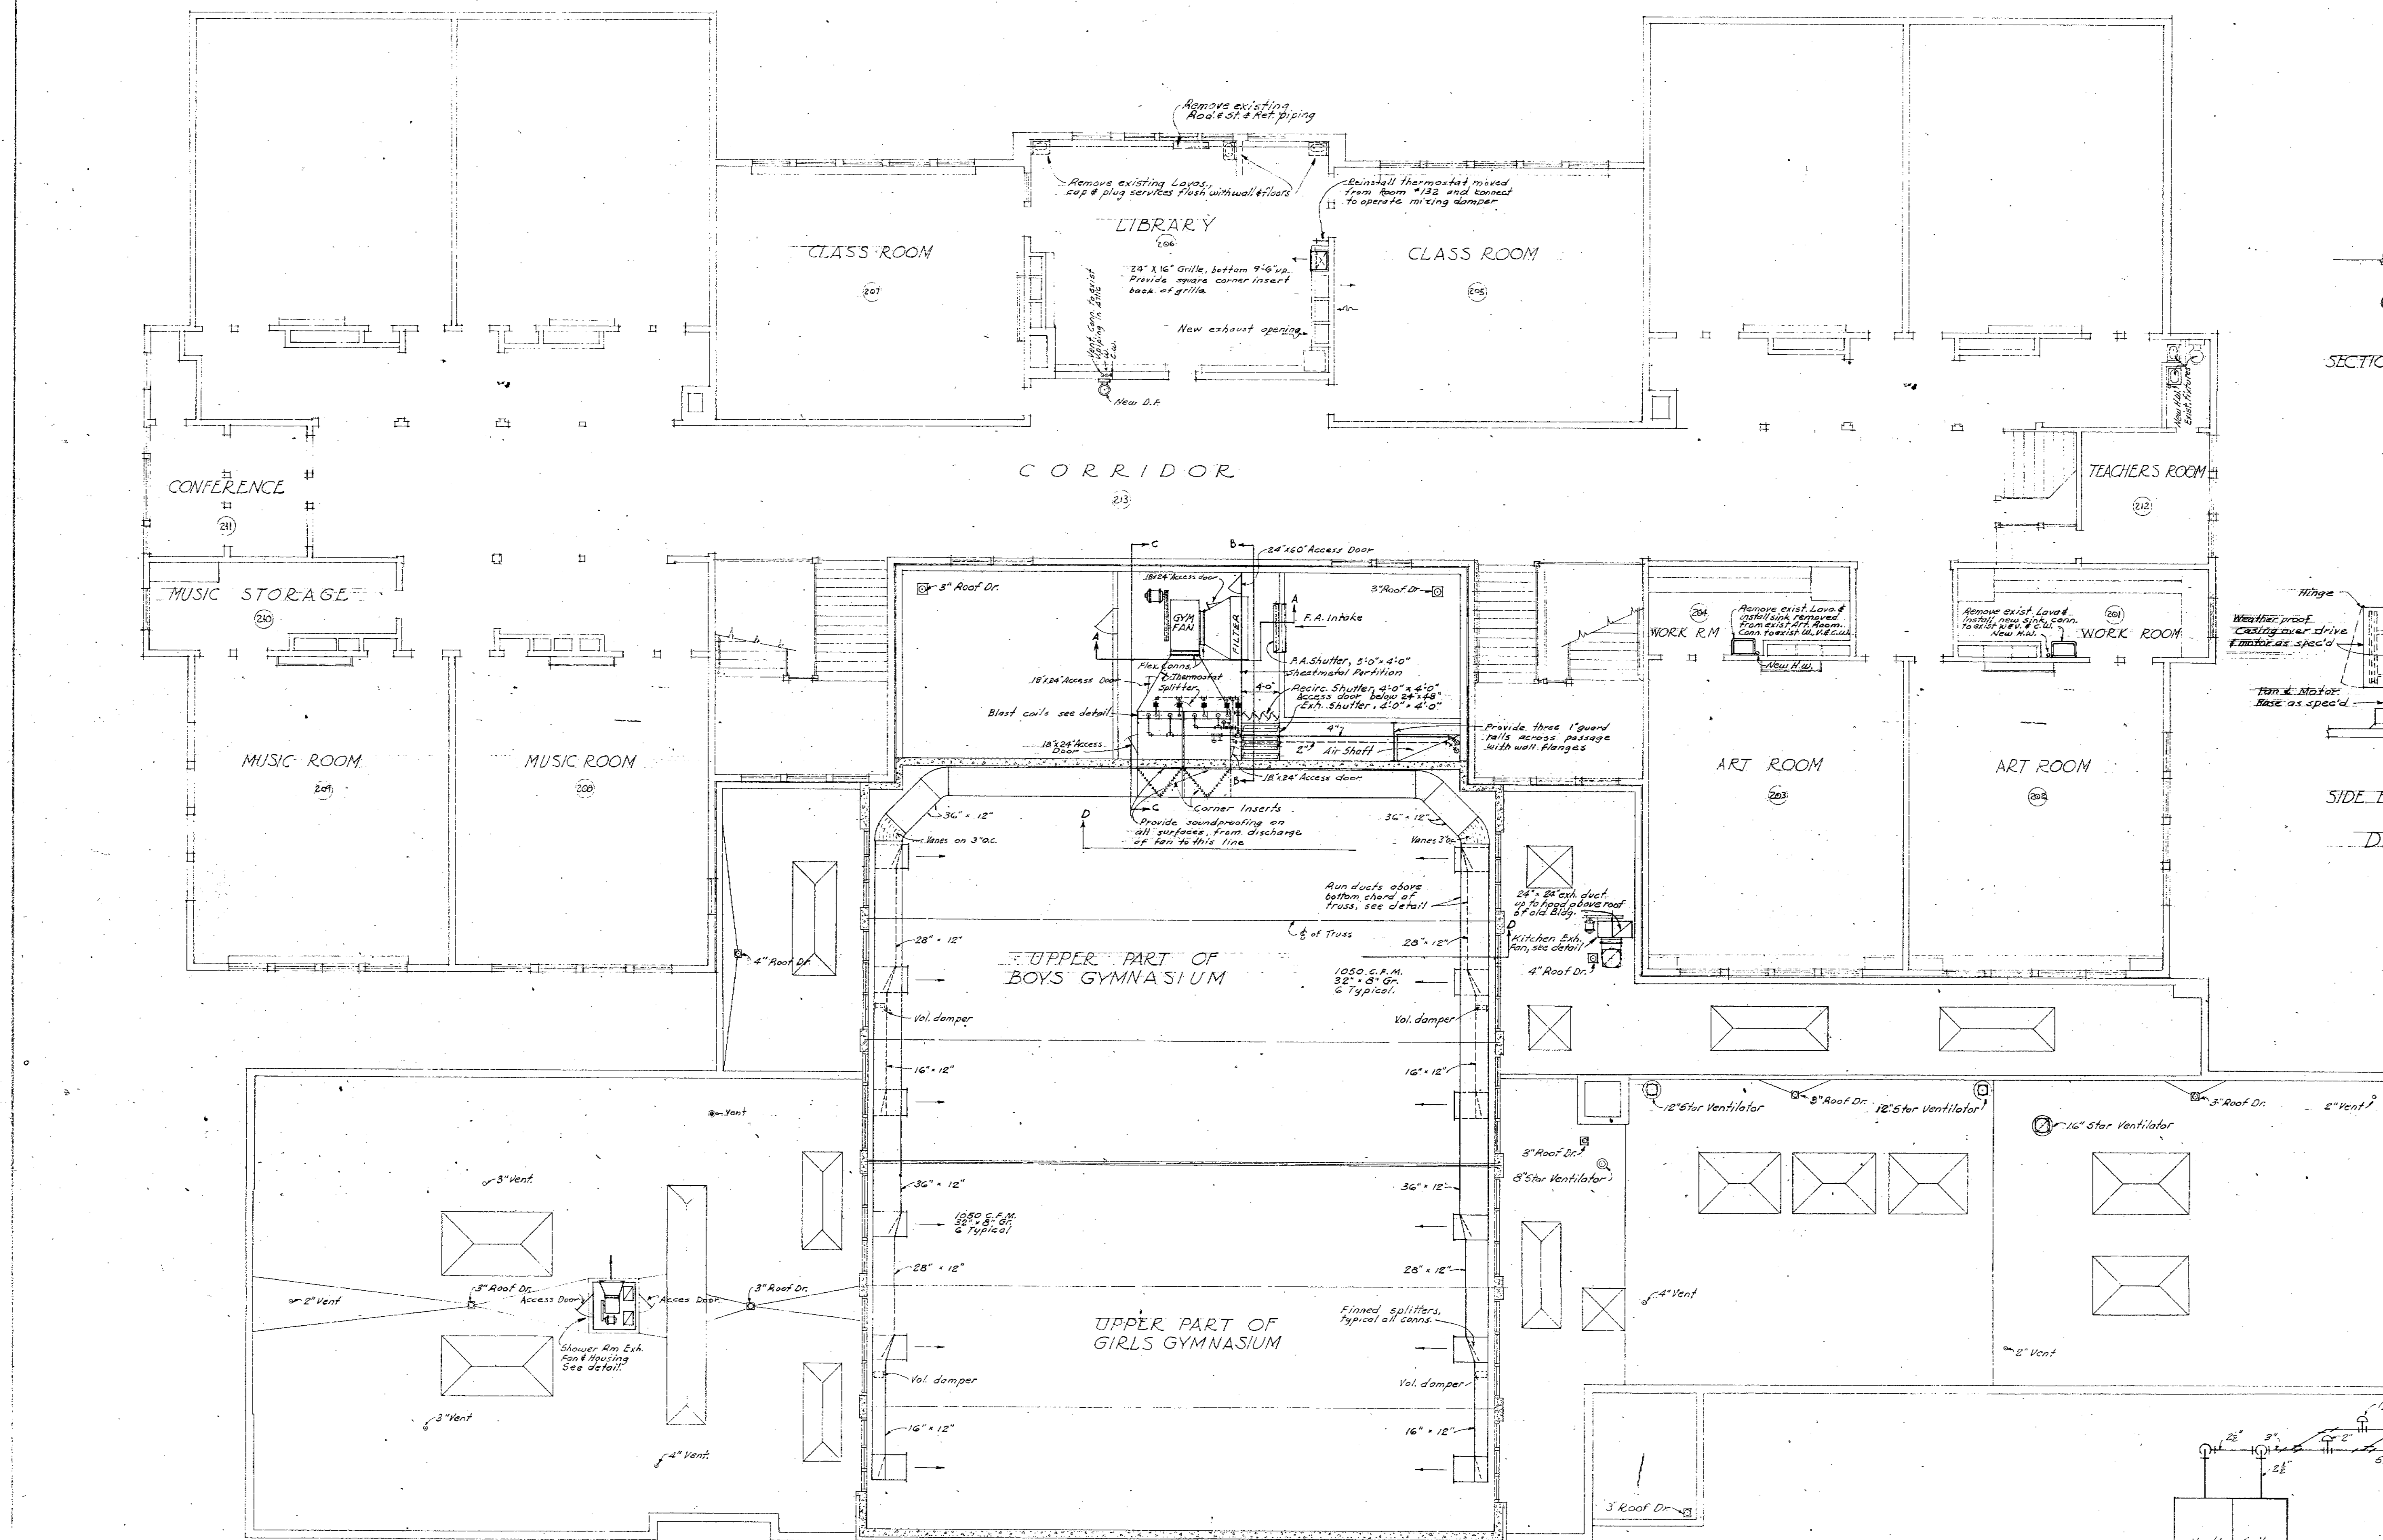

SIDE ELEVATION FRONT ELEVATION
DETAILS OF KITCHEN EXHAUST FAN
SCALE 1/2"=1'-0"

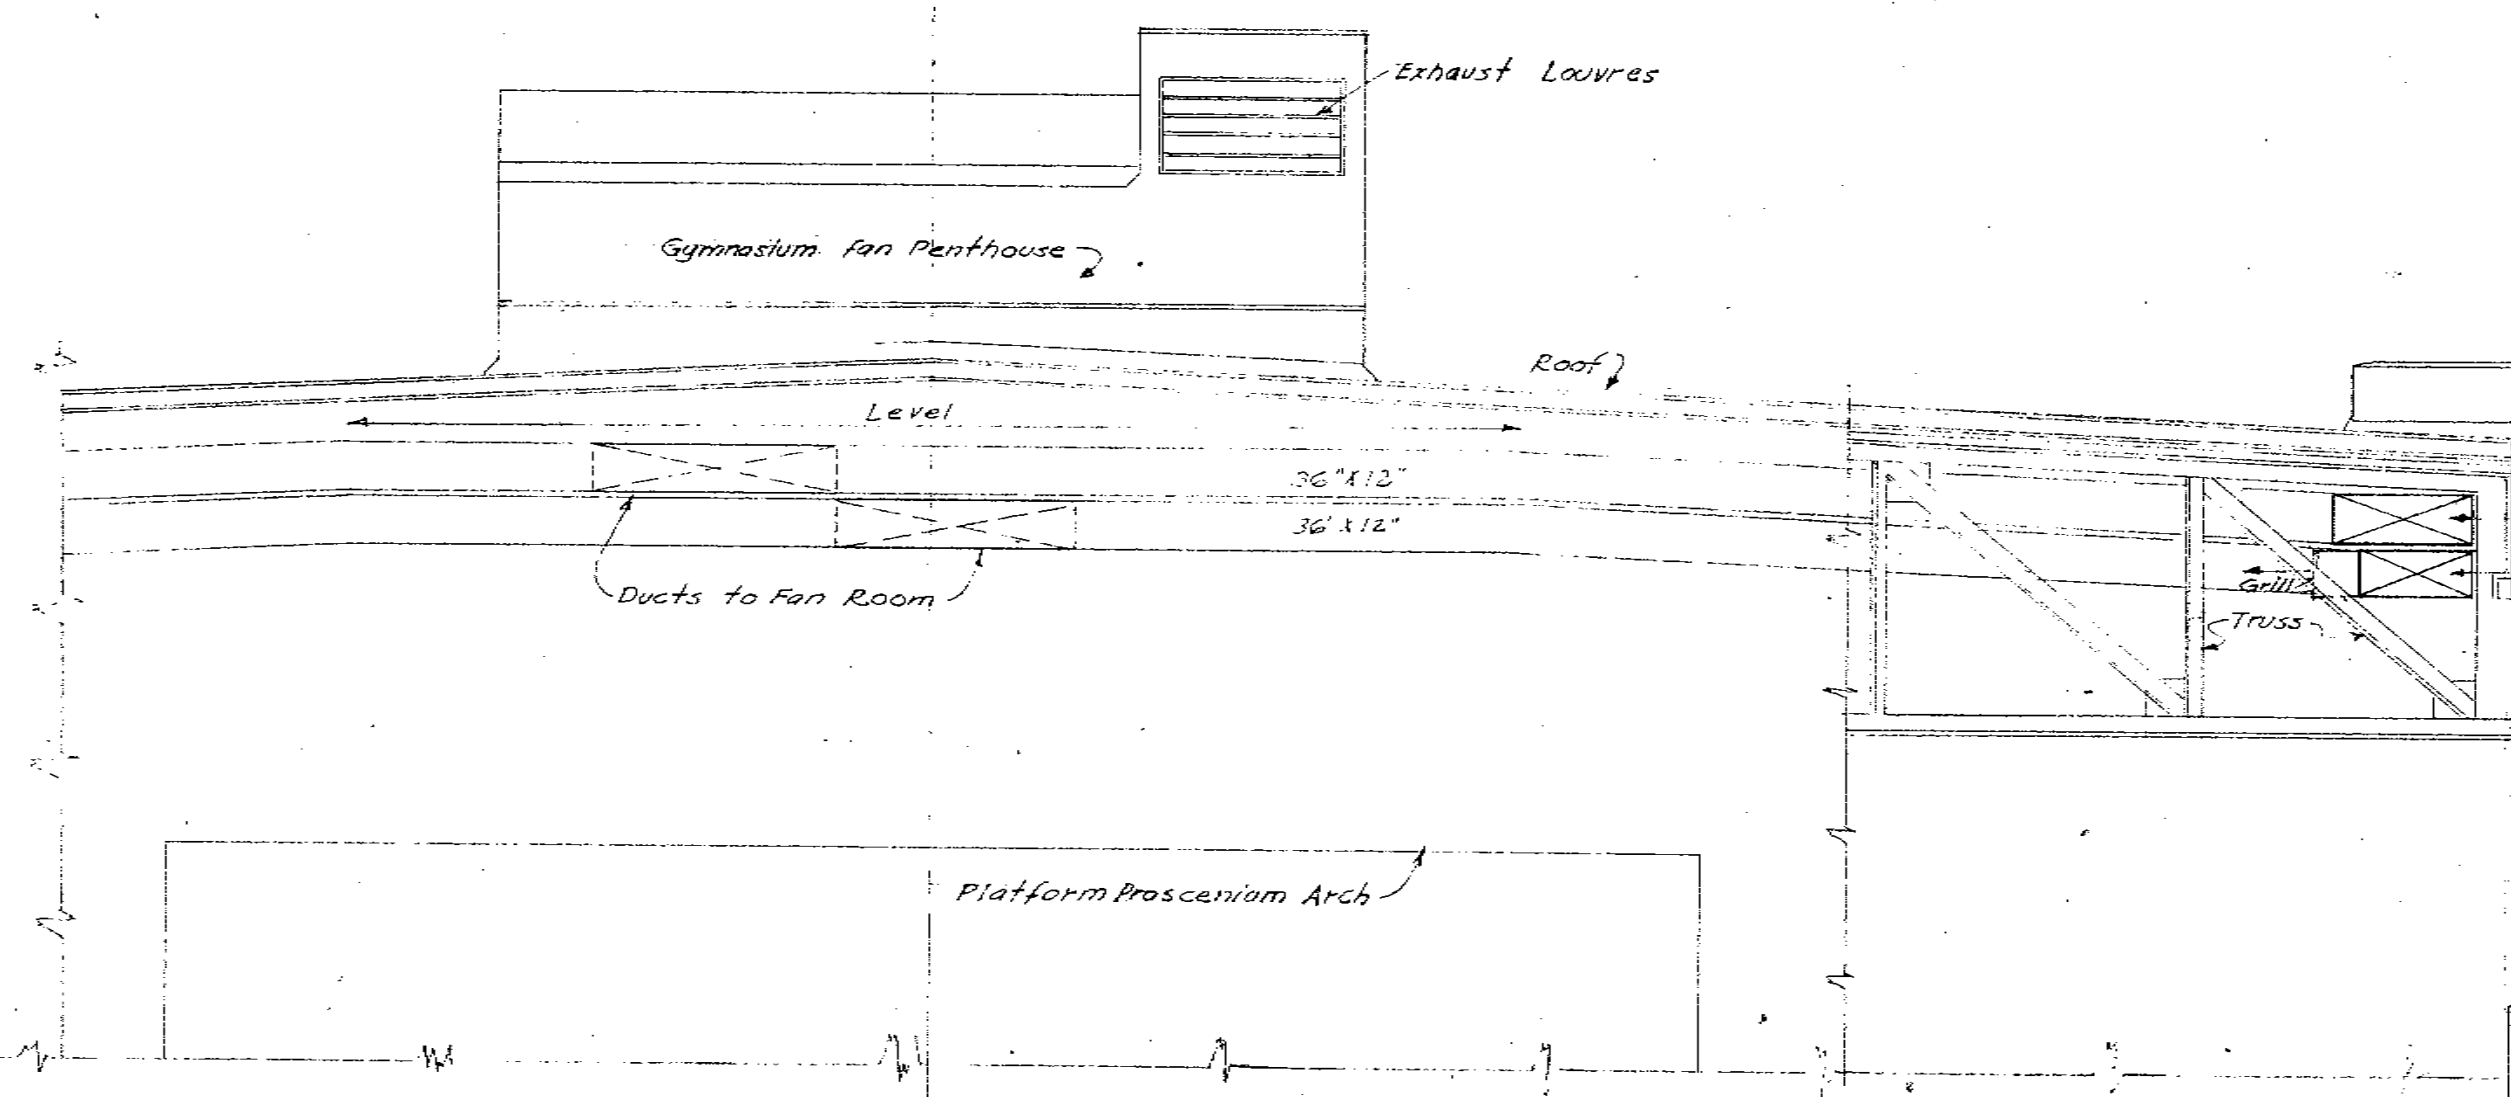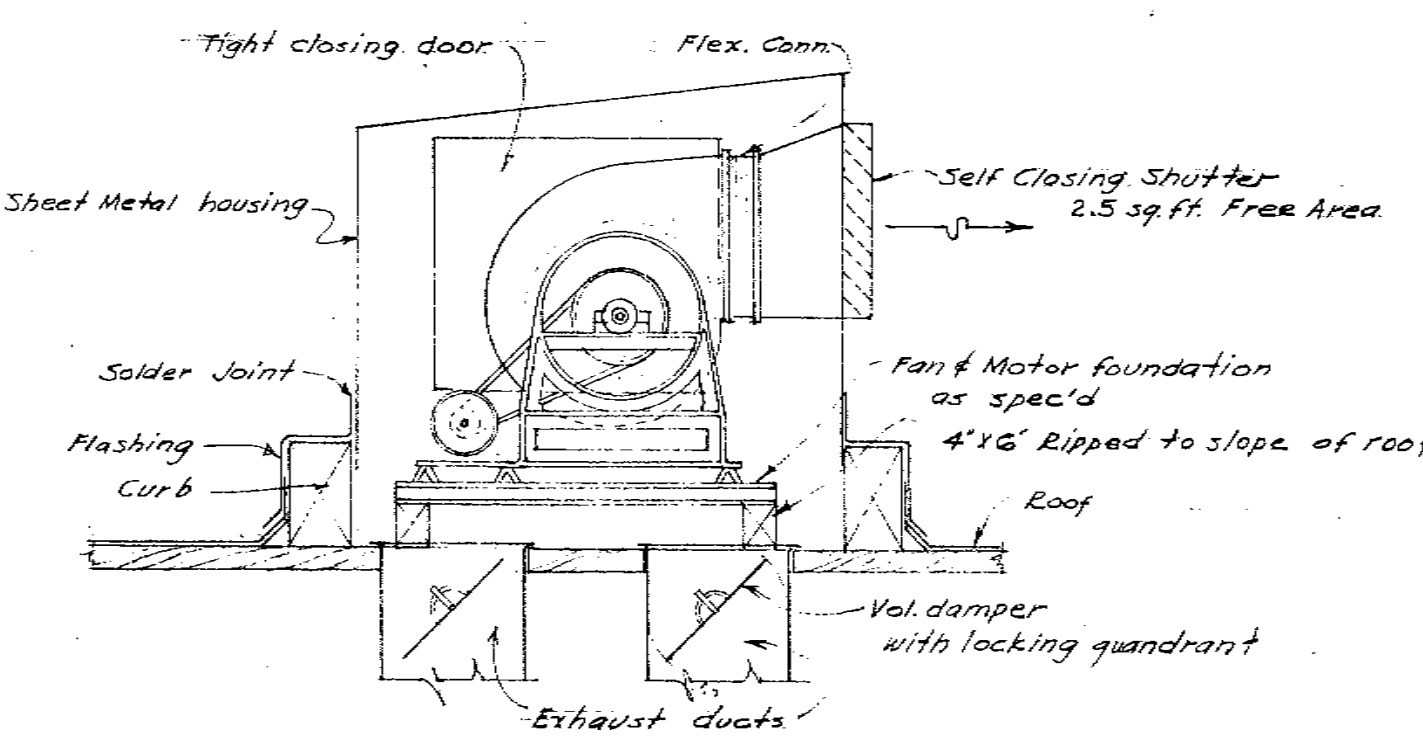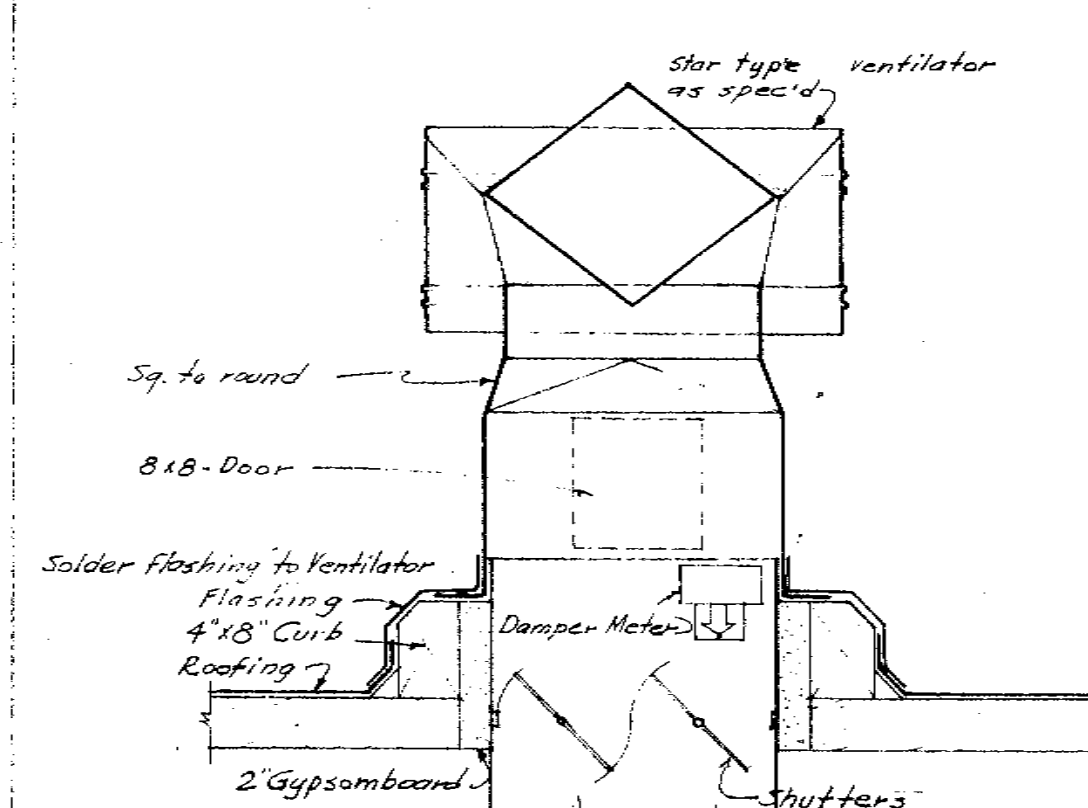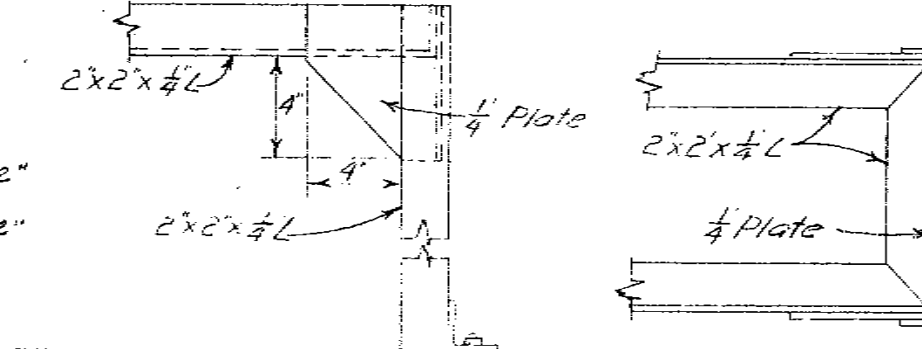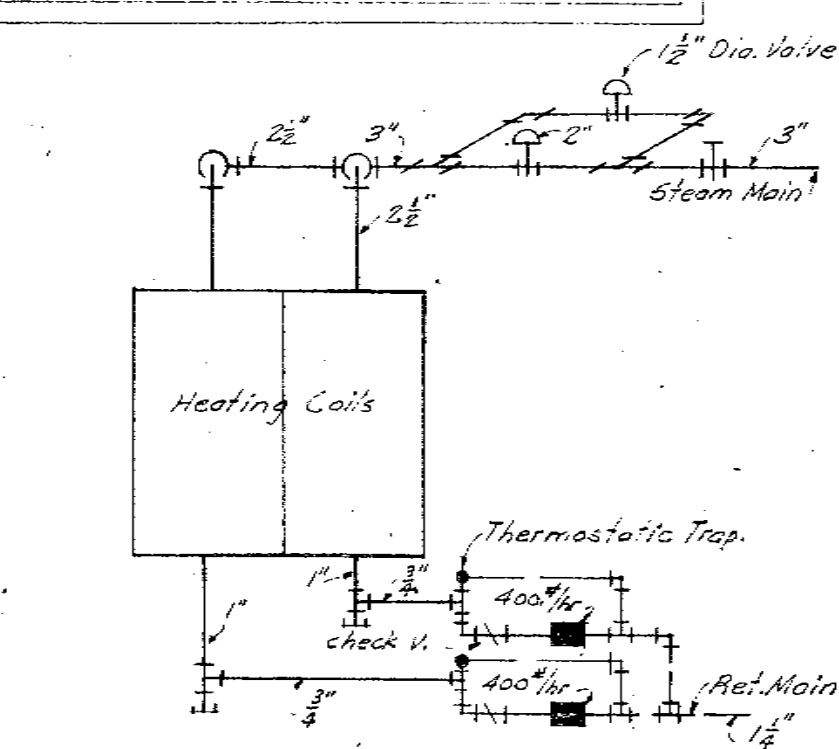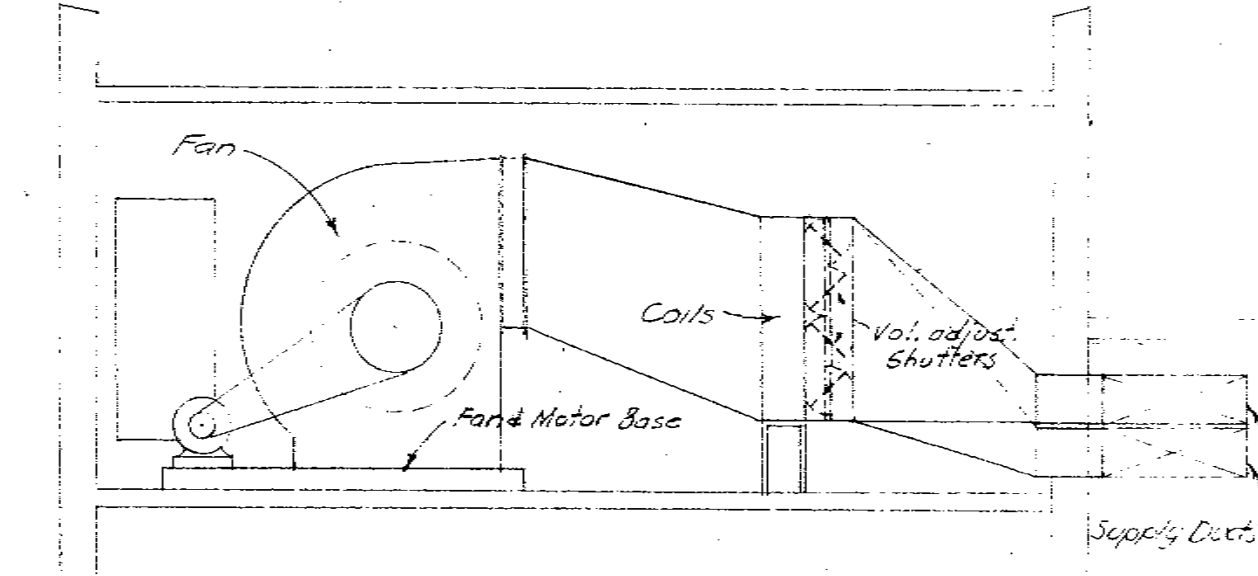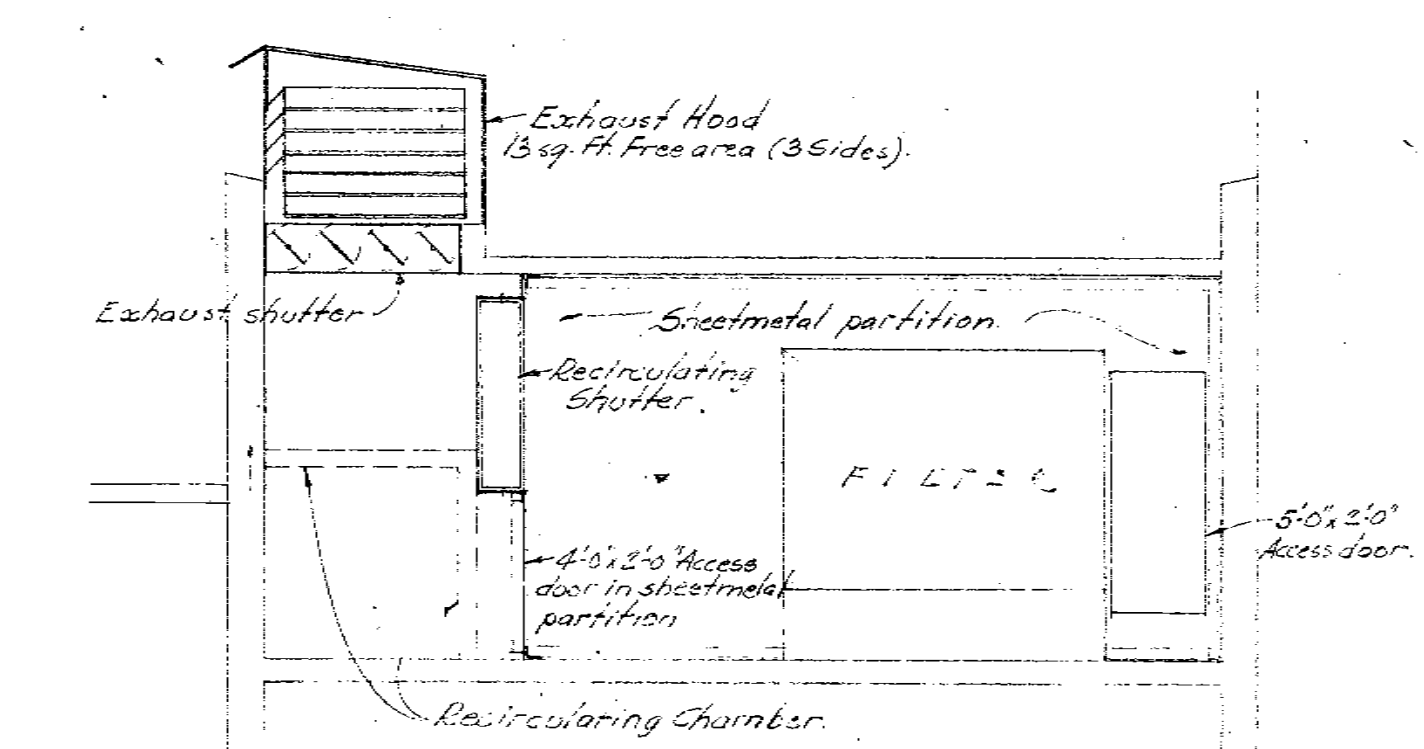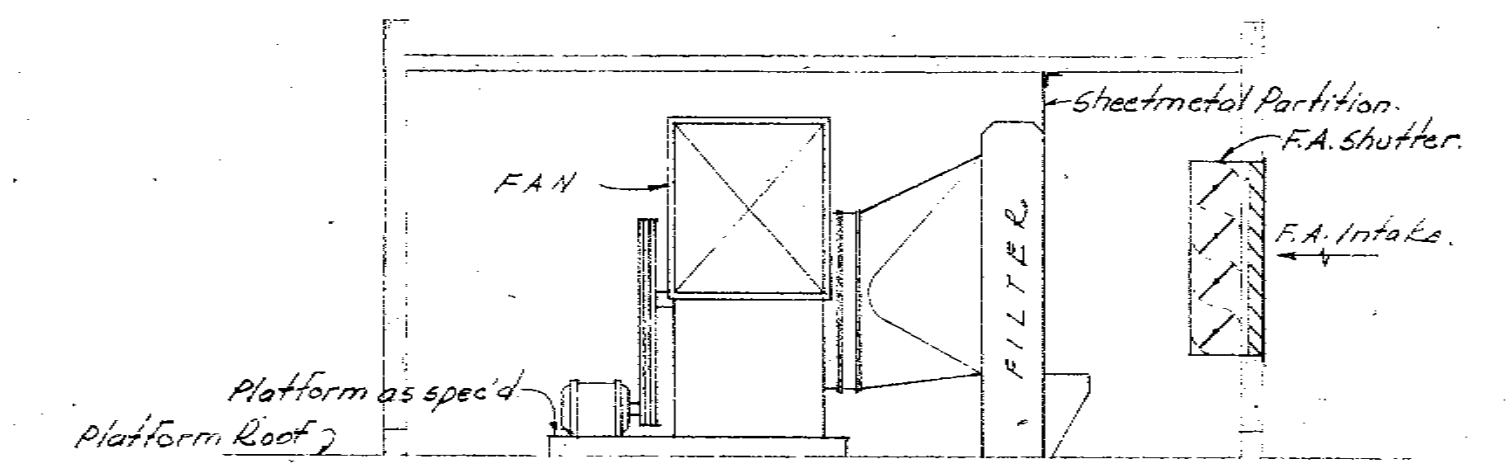

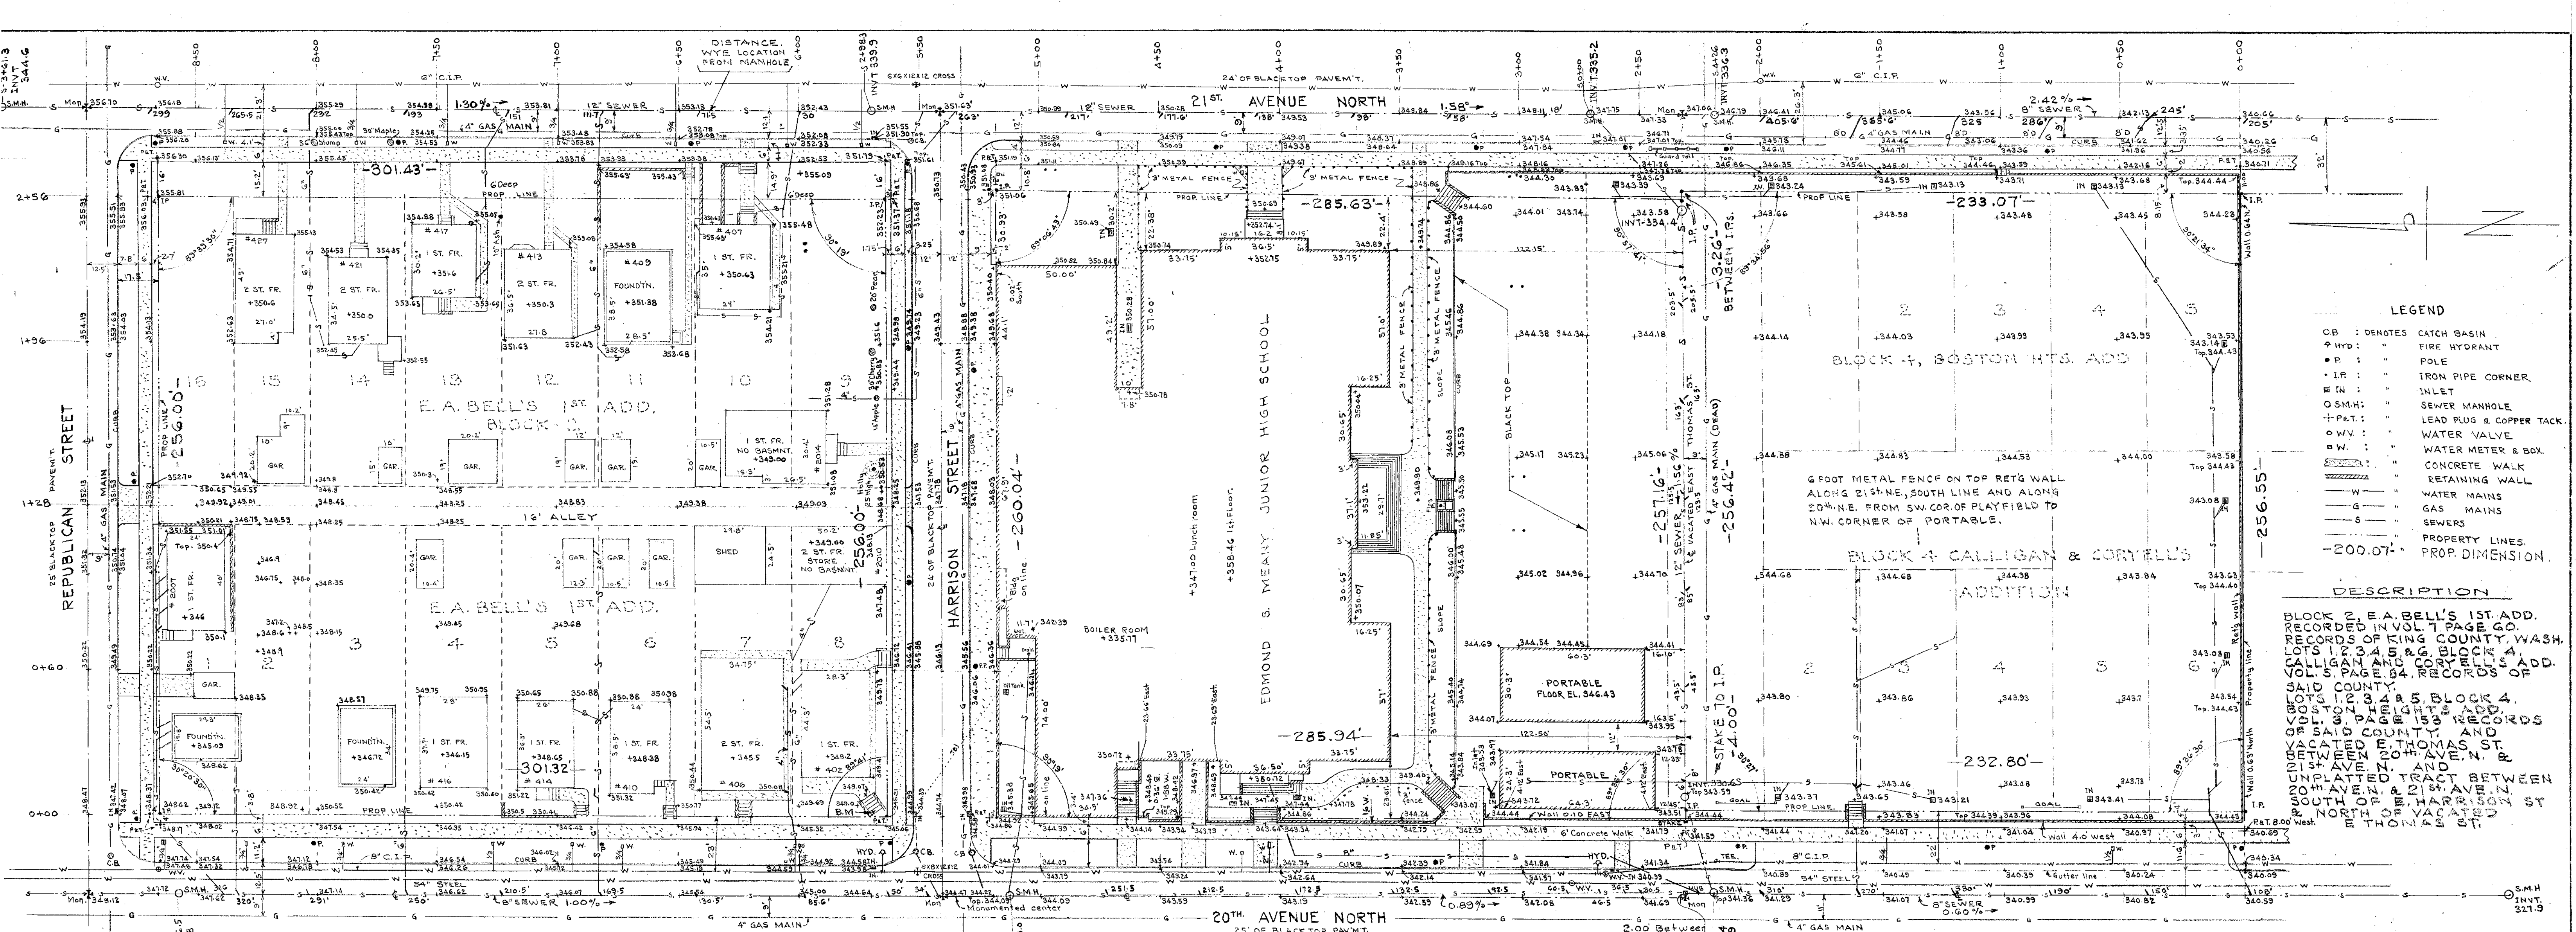


- LEGEND**
- CB : DENOTES CATCH BASIN
 - HYD : FIRE HYDRANT
 - P : POLE
 - I.P. : IRON PIPE CORNER
 - IN : INLET
 - S.M.H. : SEWER MANHOLE
 - L.P.T. : LEAD PLUG & COPPER TACK
 - W.V. : WATER VALVE
 - W.M.B. : WATER METER & BOX
 - CONCRETE WALK
 - RETAINING WALL
 - W : WATER MAINS
 - G : GAS MAINS
 - S : SEWERS
 - PROPERTY LINES
 - PROP. DIMENSION

DESCRIPTION




BLOCK 2, E.A. BELL'S 1ST ADD. RECORDED IN VOL. 7 PAGE 60. RECORDS OF KING COUNTY, WASH. LOTS 1, 2, 3, 99, 100.

NOTE:
INFORMATION ON UNDERGROUND UTILITIES, SEWER, WATER & GAS, OBTAINED FROM CITY ENGINEER'S RECORDS

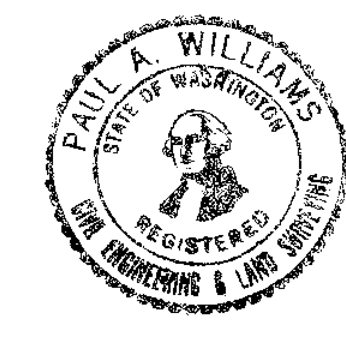

SEATTLE PUBLIC SCHOOLS
SURVEY & TOPOGRAPHY
EDMOND S. MEANY
JUNIOR HIGH SCHOOL

DATE: 10-8-53
REVISION: 1
DRAWN BY: A.W.H.
CHECKED BY: A.W.H.
LAND SURVEYOR
312 COLUMBIA ST.
SEATTLE 2, WASH.
SE. 5934

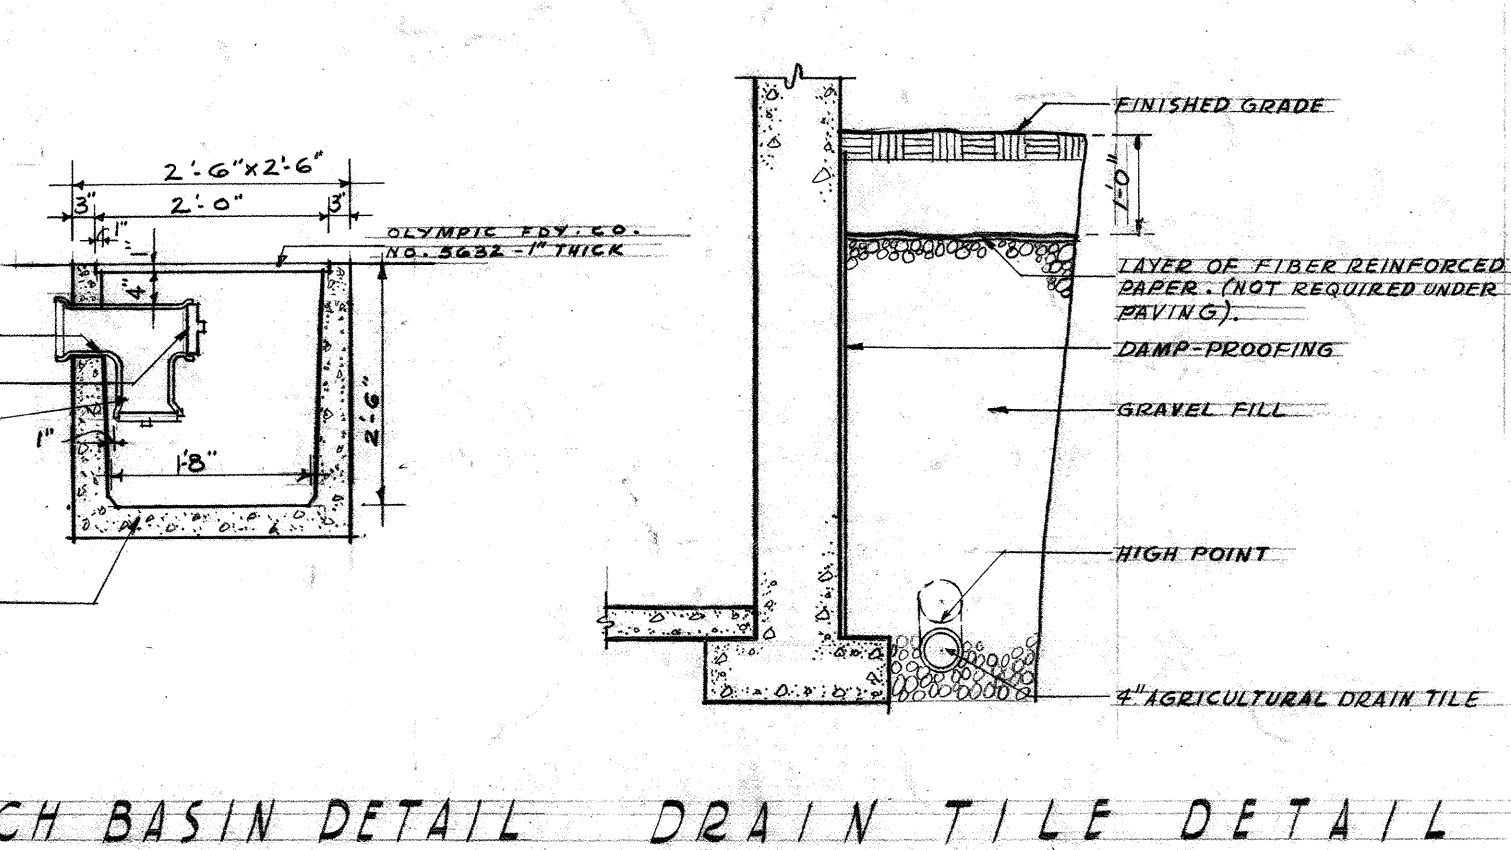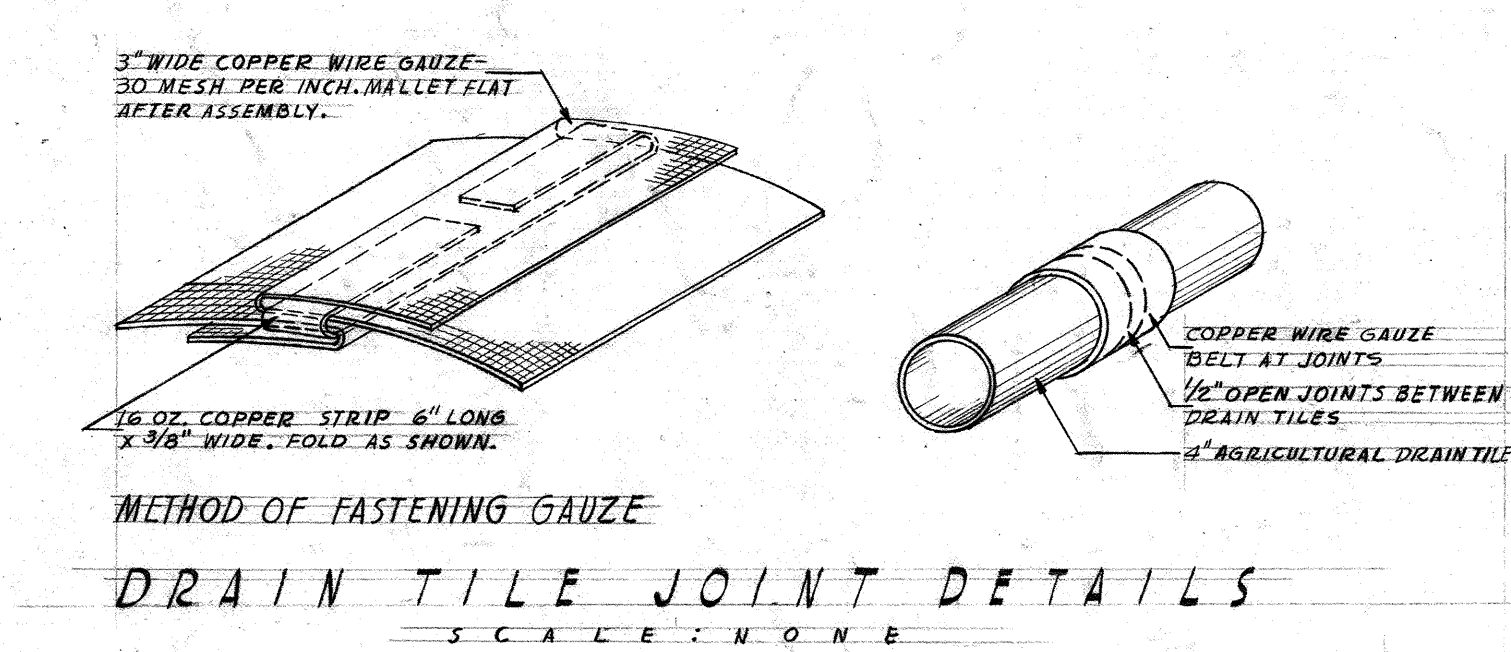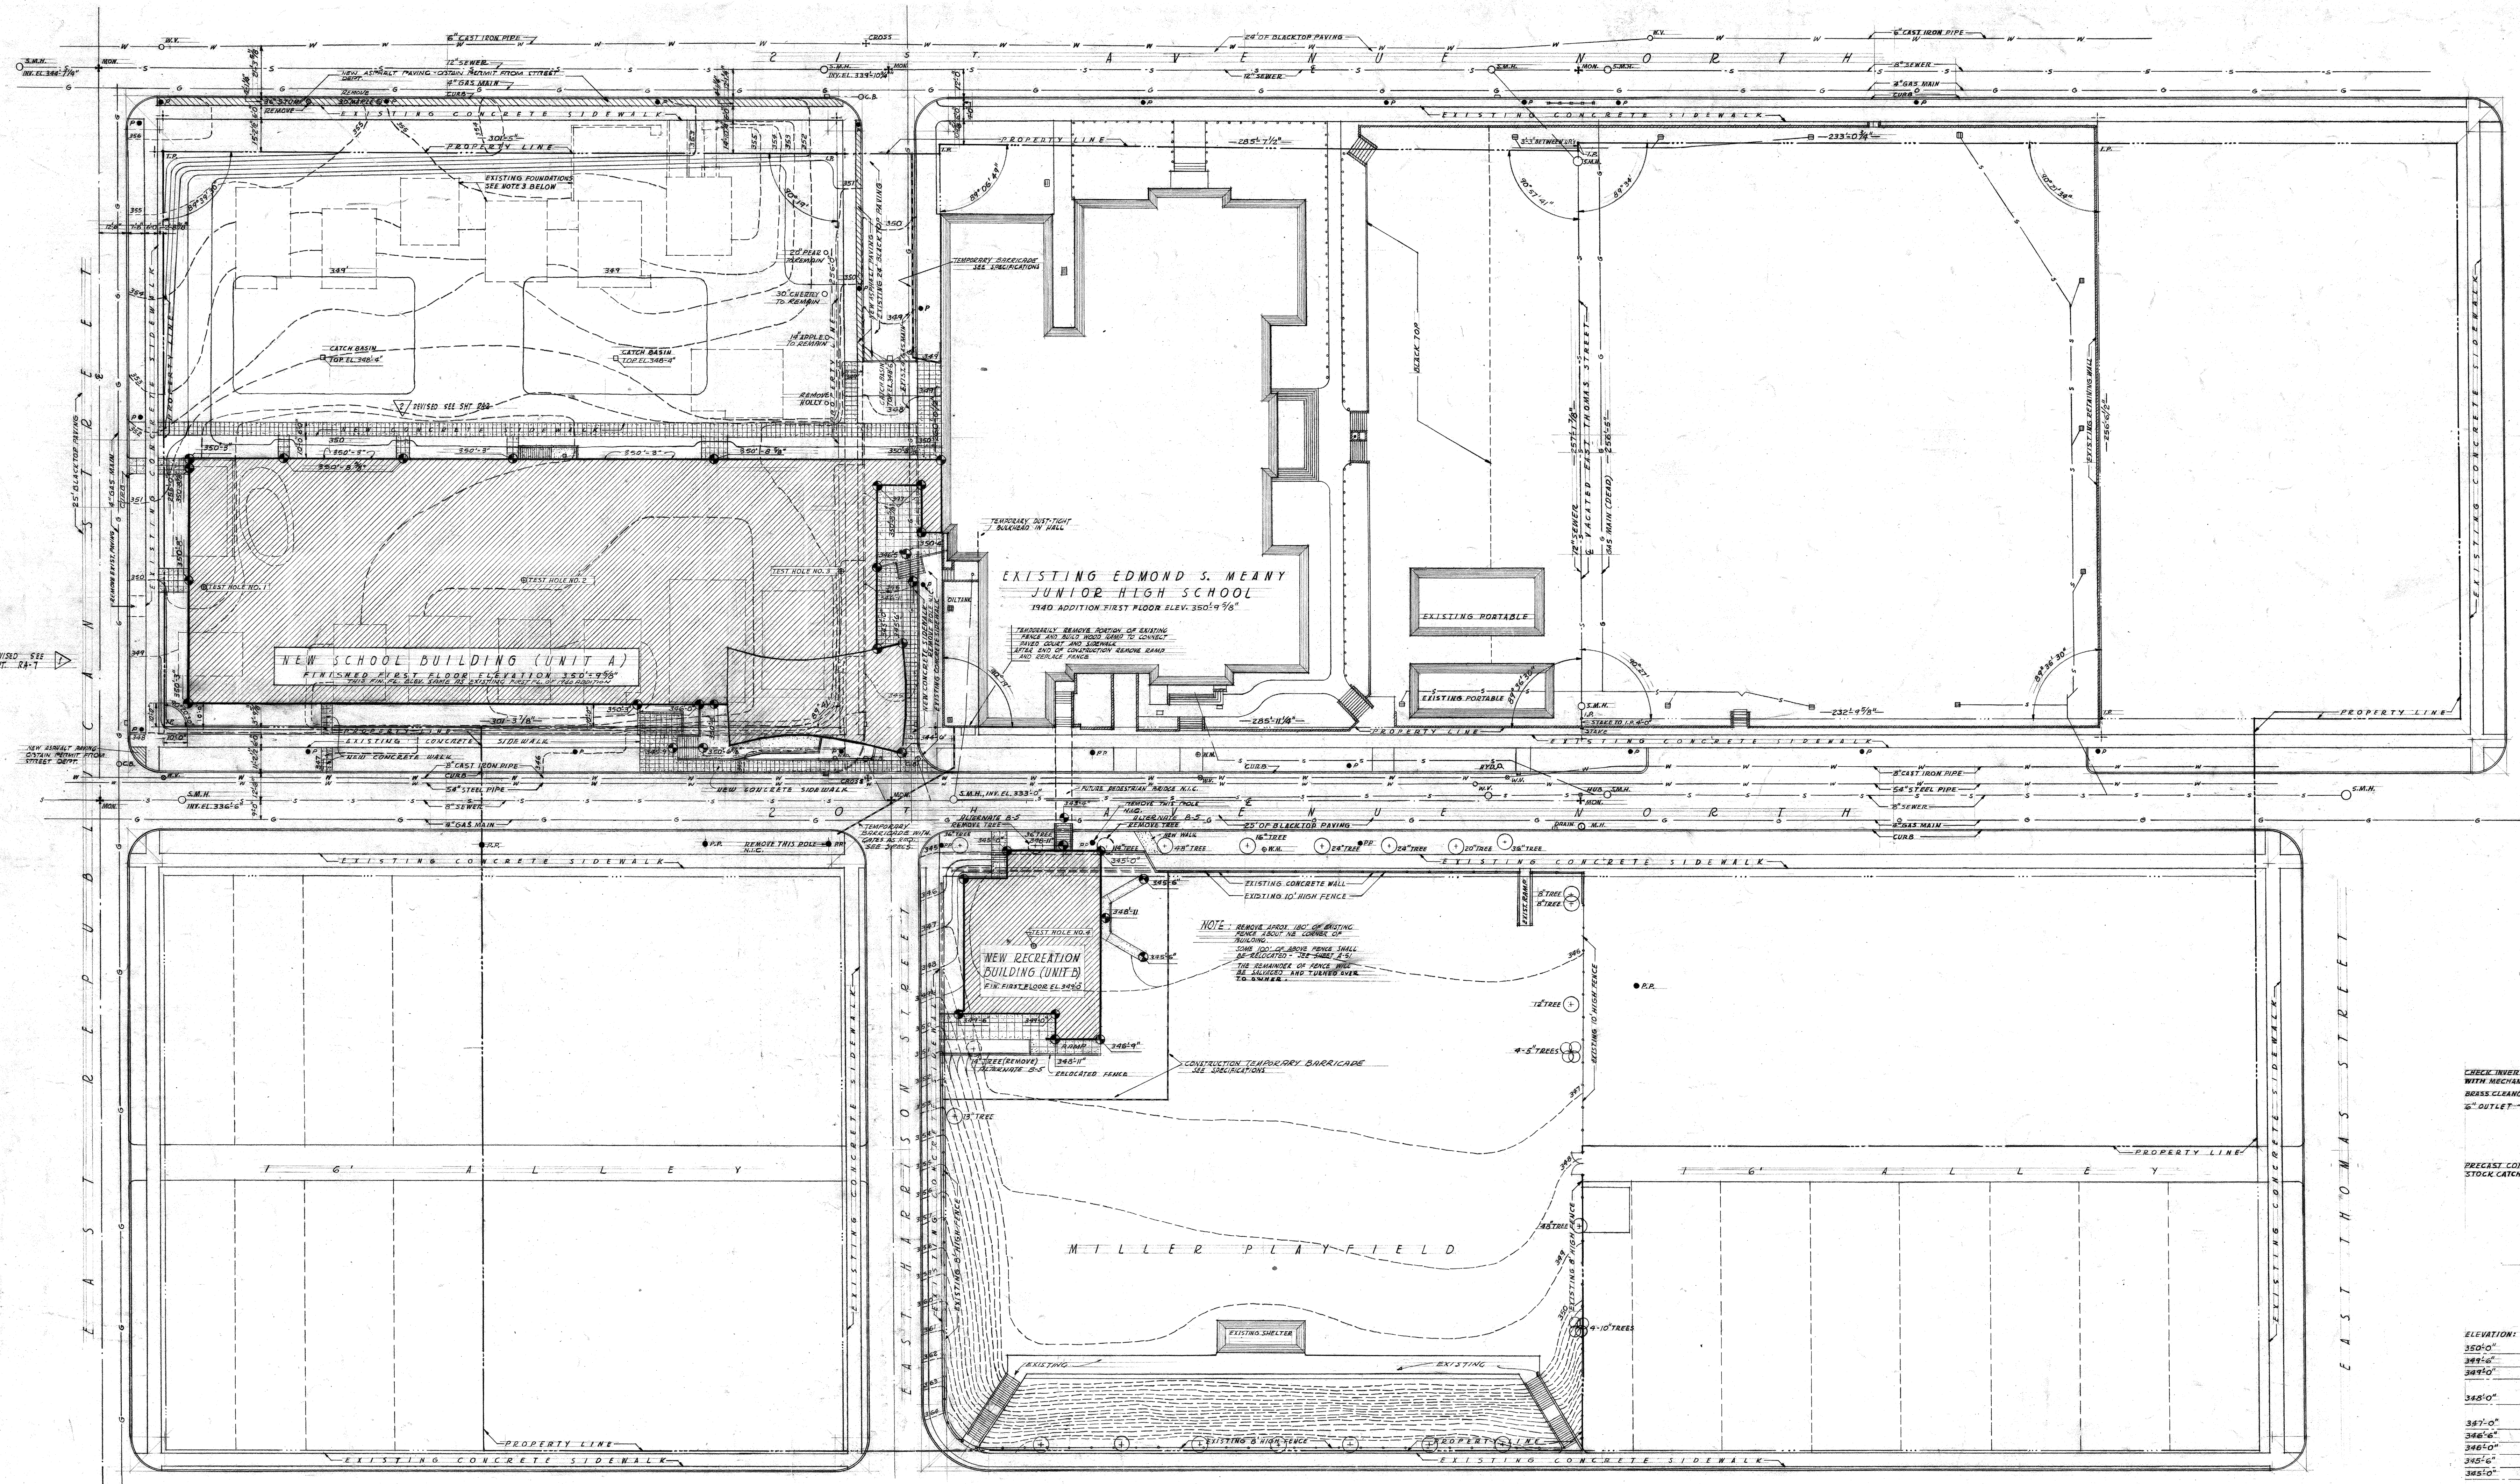

NOTES:
1. TOP SOIL IS LANDSCAPED BY OWNER.
2. GRADE TO WITHIN 4\"/>

TEST HOLE DATA

ELEVATION	NO. 1	NO. 2	NO. 3	NO. 4
3500'	SANDY, BLACK TOP SOIL	SANDY, BLACK TOP SOIL	SANDY, BLACK TOP SOIL	SANDY, BLACK TOP SOIL
3495'	FINE SILTY SANDY SOIL	FINE SILTY SANDY SOIL	FINE SILTY SANDY SOIL	FINE SILTY SANDY SOIL
3490'	FINE SILTY SANDY SOIL	FINE SILTY SANDY SOIL	FINE SILTY SANDY SOIL	FINE SILTY SANDY SOIL
3485'	FINE SILTY SANDY SOIL	FINE SILTY SANDY SOIL	FINE SILTY SANDY SOIL	FINE SILTY SANDY SOIL
3480'	FINE SILTY SANDY SOIL	FINE SILTY SANDY SOIL	FINE SILTY SANDY SOIL	FINE SILTY SANDY SOIL
3475'	FINE SILTY SANDY SOIL	FINE SILTY SANDY SOIL	FINE SILTY SANDY SOIL	FINE SILTY SANDY SOIL
3470'	FINE SILTY SANDY SOIL	FINE SILTY SANDY SOIL	FINE SILTY SANDY SOIL	FINE SILTY SANDY SOIL
3465'	FINE SILTY SANDY SOIL	FINE SILTY SANDY SOIL	FINE SILTY SANDY SOIL	FINE SILTY SANDY SOIL
3460'	FINE SILTY SANDY SOIL	FINE SILTY SANDY SOIL	FINE SILTY SANDY SOIL	FINE SILTY SANDY SOIL
3455'	FINE SILTY SANDY SOIL	FINE SILTY SANDY SOIL	FINE SILTY SANDY SOIL	FINE SILTY SANDY SOIL
3450'	FINE SILTY SANDY SOIL	FINE SILTY SANDY SOIL	FINE SILTY SANDY SOIL	FINE SILTY SANDY SOIL
3445'	FINE SILTY SANDY SOIL	FINE SILTY SANDY SOIL	FINE SILTY SANDY SOIL	FINE SILTY SANDY SOIL
3440'	FINE SILTY SANDY SOIL	FINE SILTY SANDY SOIL	FINE SILTY SANDY SOIL	FINE SILTY SANDY SOIL
3435'	FINE SILTY SANDY SOIL	FINE SILTY SANDY SOIL	FINE SILTY SANDY SOIL	FINE SILTY SANDY SOIL
3430'	FINE SILTY SANDY SOIL	FINE SILTY SANDY SOIL	FINE SILTY SANDY SOIL	FINE SILTY SANDY SOIL
3425'	FINE SILTY SANDY SOIL	FINE SILTY SANDY SOIL	FINE SILTY SANDY SOIL	FINE SILTY SANDY SOIL
3420'	FINE SILTY SANDY SOIL	FINE SILTY SANDY SOIL	FINE SILTY SANDY SOIL	FINE SILTY SANDY SOIL
3415'	FINE SILTY SANDY SOIL	FINE SILTY SANDY SOIL	FINE SILTY SANDY SOIL	FINE SILTY SANDY SOIL
3410'	FINE SILTY SANDY SOIL	FINE SILTY SANDY SOIL	FINE SILTY SANDY SOIL	FINE SILTY SANDY SOIL
3405'	FINE SILTY SANDY SOIL	FINE SILTY SANDY SOIL	FINE SILTY SANDY SOIL	FINE SILTY SANDY SOIL
3400'	FINE SILTY SANDY SOIL	FINE SILTY SANDY SOIL	FINE SILTY SANDY SOIL	FINE SILTY SANDY SOIL
3395'	FINE SILTY SANDY SOIL	FINE SILTY SANDY SOIL	FINE SILTY SANDY SOIL	FINE SILTY SANDY SOIL
3390'	FINE SILTY SANDY SOIL	FINE SILTY SANDY SOIL	FINE SILTY SANDY SOIL	FINE SILTY SANDY SOIL
3385'	FINE SILTY SANDY SOIL	FINE SILTY SANDY SOIL	FINE SILTY SANDY SOIL	FINE SILTY SANDY SOIL
3380'	FINE SILTY SANDY SOIL	FINE SILTY SANDY SOIL	FINE SILTY SANDY SOIL	FINE SILTY SANDY SOIL
3375'	FINE SILTY SANDY SOIL	FINE SILTY SANDY SOIL	FINE SILTY SANDY SOIL	FINE SILTY SANDY SOIL
3370'	FINE SILTY SANDY SOIL	FINE SILTY SANDY SOIL	FINE SILTY SANDY SOIL	FINE SILTY SANDY SOIL
3365'	FINE SILTY SANDY SOIL	FINE SILTY SANDY SOIL	FINE SILTY SANDY SOIL	FINE SILTY SANDY SOIL
3360'	FINE SILTY SANDY SOIL	FINE SILTY SANDY SOIL	FINE SILTY SANDY SOIL	FINE SILTY SANDY SOIL
3355'	FINE SILTY SANDY SOIL	FINE SILTY SANDY SOIL	FINE SILTY SANDY SOIL	FINE SILTY SANDY SOIL
3350'	FINE SILTY SANDY SOIL	FINE SILTY SANDY SOIL	FINE SILTY SANDY SOIL	FINE SILTY SANDY SOIL
3345'	FINE SILTY SANDY SOIL	FINE SILTY SANDY SOIL	FINE SILTY SANDY SOIL	FINE SILTY SANDY SOIL
3340'	FINE SILTY SANDY SOIL	FINE SILTY SANDY SOIL	FINE SILTY SANDY SOIL	FINE SILTY SANDY SOIL
3335'	FINE SILTY SANDY SOIL	FINE SILTY SANDY SOIL	FINE SILTY SANDY SOIL	FINE SILTY SANDY SOIL
3330'	FINE SILTY SANDY SOIL	FINE SILTY SANDY SOIL	FINE SILTY SANDY SOIL	FINE SILTY SANDY SOIL
3325'	FINE SILTY SANDY SOIL	FINE SILTY SANDY SOIL	FINE SILTY SANDY SOIL	FINE SILTY SANDY SOIL
3320'	FINE SILTY SANDY SOIL	FINE SILTY SANDY SOIL	FINE SILTY SANDY SOIL	FINE SILTY SANDY SOIL
3315'	FINE SILTY SANDY SOIL	FINE SILTY SANDY SOIL	FINE SILTY SANDY SOIL	FINE SILTY SANDY SOIL
3310'	FINE SILTY SANDY SOIL	FINE SILTY SANDY SOIL	FINE SILTY SANDY SOIL	FINE SILTY SANDY SOIL
3305'	FINE SILTY SANDY SOIL	FINE SILTY SANDY SOIL	FINE SILTY SANDY SOIL	FINE SILTY SANDY SOIL
3300'	FINE SILTY SANDY SOIL	FINE SILTY SANDY SOIL	FINE SILTY SANDY SOIL	FINE SILTY SANDY SOIL

INDEX TO DRAWINGS

ARCHITECTURAL	UNIT
A 1 PLOT PLAN	A & B
A 2 SURVEY	A
A 3 FOUNDATION & BASEMENT PLAN	A
A 4 DOOR SCHEDULE	A & B
A 5 ROOM FINISH SCHEDULE	A
A 6 FIRST FLOOR PLAN	A
A 7 ROOF PLAN AND DETAILS	A
A 8 ELEVATIONS AND SECTIONS	A
A 9 NORTH ELEVATION DETAILS AND SECTIONS	A
A 10 TYPICAL CLASSROOM DETAILS AND SECTIONS	A
A 11 ENTRANCE DETAILS	A
A 12 TOILET ROOM DETAILS & CORRIDOR SECTION	A
A 13 SCIENCE ROOM DETAILS	A
A 14 ART ROOM DETAILS	A
A 15 DRAFTING ROOM DETAILS	A
A 16 WOOD SHOP DETAILS	A
A 17 METAL SHOP AND CRAFTS SHOP DETAILS	A
A 18 BAND AND CHORUS ROOMS AND MUSIC CLASSROOM PLAN AND SECTIONS	A
A 19 CLOTHING LABORATORY AND GENERAL PURPOSE ROOM DETAILS	A
A 20 LIBRARY DETAILS	A

ARCHITECTURAL

A 50 ROOM FINISH AND DOOR SCHEDULES	B
A 51 PLANS, ELEVATIONS AND SECTIONS	B
A 52 EXTERIOR AND INTERIOR DETAILS	B

STRUCTURAL

S 1 FOUNDATION PLAN	A
S 2 FIRST FLOOR FRAMING PLAN	A
S 3 ROOF FRAMING PLAN	A
S 4 ELEVATIONS	A
S 5 NOTES AND DETAILS	A & B

MECHANICAL

M 1 PLOT PLAN AND BOILER ROOM DETAILS	A & B
M 2 FOUNDATION PLAN	A
M 3 FIRST FLOOR PLAN	A
M 50 PLANS AND DETAILS	B

ELECTRICAL

E 1 FIRST FLOOR PLAN UNDERFLOOR	A
E 2 FIRST FLOOR PLAN OVERHEAD	A

SYMBOLS


ACOUSTIC TILE	GLASS LATH, PLASTER BOARD
BRICK	INSULATION
FIRE BRICK	METAL (ELEVATION)
CEMENT ASBESTOS	METAL (SECTION)
CERAMIC TILE, HOLLOW CLAY TILE, GLAZED BRICK	PLASTER
CONCRETE (SECTION)	STUCCO
CONCRETE BLOCK	WOOD (SECTION)
CORRUGATED METAL	WOOD STUD WALL
EARTH	EXISTING STRUCTURE
GRAVEL	EXISTING UNIT A
COLUMN GRID NUMBER	DRAINING FOUNTAIN
DOOR NUMBER	ELECTRIC PANEL
EXISTING GRADE LINE	FIRE EXTINGUISHER RECESS
FINISHED GRADE LINE	LAVATORY
FINISHED GRADE	SERVICE SINK
FLOOR DRAIN	TELEPHONE
ROOM DRAIN	URINAL
ROOM YOUNDER	WATER CLOSET
SECTION A-A	
SECTION 2-2 SHEET A-3	

GENERAL NOTES
1. ROOM FINISH SCHEDULE AND DOOR SCHEDULE. SHOW MATERIALS AND FINISHES. WHICH SHALL BE PROVIDED BY THE ARCHITECT. THE MATERIALS AND FINISHES SHALL BE AS SHOWN IN THESE SCHEDULES. THE WORKMANSHIP SHALL BE PROVIDED AND SPECIFICATIONS FOR SAME SHALL BE PROVIDED BY THE ARCHITECT AT CONSTRUCTION.
2. SURVEYORS OR PLANNERS ARE TO BE RESPONSIBLE FOR THE LOCATION OF THE BUILDING. THE ARCHITECT SHALL BE RESPONSIBLE FOR THE LOCATION OF THE BUILDING. THE ARCHITECT SHALL BE RESPONSIBLE FOR THE LOCATION OF THE BUILDING.
3. CONSULT MECHANICAL & ELECTRICAL PLANS FOR LOCATIONS OF DUCTS, CONDUITS, PIPING, CABINETS, ETC. WHERE DUCTS, PIPES, OR WELLS ARE SHOWN WITH AUTOMATIC CLOSING FIRE STOPPERS.
4. CONTRACTOR SHALL VERIFY ALL GRADE DIMENSIONS AND EXISTING DIMENSIONS ON JOB.
5. ROOM NUMBERS SHOWN ON DRAWINGS ARE FOR CONSTRUCTION PURPOSES ONLY. CONTRACTOR SHALL CONSULT WITH OWNER FOR NUMBERS & NAMES TO BE PLANTED ON JOBS OR EXTERIORS AS REQUIRED.
6. ROOMS WHICH HAVE EARTH FILL DEMOLISHED WALLS SHALL HAVE SUCH WALLS DAMP-PROOFED ON EARTH SIDE.
7. SEE STRUCTURAL, MECHANICAL & ELECTRICAL DRAWINGS FOR ADDITIONAL NOTES & SYMBOLS.
8. ALL EXISTING CONCRETE OR ARCHITECTURAL CONCRETE SHALL HAVE 1% SLOPE UNLESS NOTED OTHERWISE.
9. CONTRACTOR SHALL VERIFY ALL ROOM DIMENSIONS FOR EQUIPMENT PURCHASE AND INSTALLED BY HIMSELF OR OTHER CONTRACTORS.
10. CONTRACTOR SHALL VERIFY DIMENSIONS OF ALL DUCT & ACCESS DRAWINGS FROM SLABS, WALLS, ETC. WITH MECHANICAL DRAWINGS.
11. ALL WORK SHALL COMPLY WITH APPLICABLE CODES & ORDINANCES.

PLOT PLAN UNITS A & B

EDMOND MEANY JUNIOR HIGH - RECREATION PROJECT
SEATTLE PUBLIC SCHOOL DISTRICT No. 1
SEATTLE DEPARTMENT OF PARKS
20th AVENUE NORTH AT EAST REPUBLICAN STREET - SEATTLE, WASHINGTON
DATE: 6-27-54
JOHN W. MALONEY
ARCHITECT
194 CENTRAL BUILDING 1117 LARSON BLVD.
SEATTLE, WASHINGTON

139-0048
139-0048

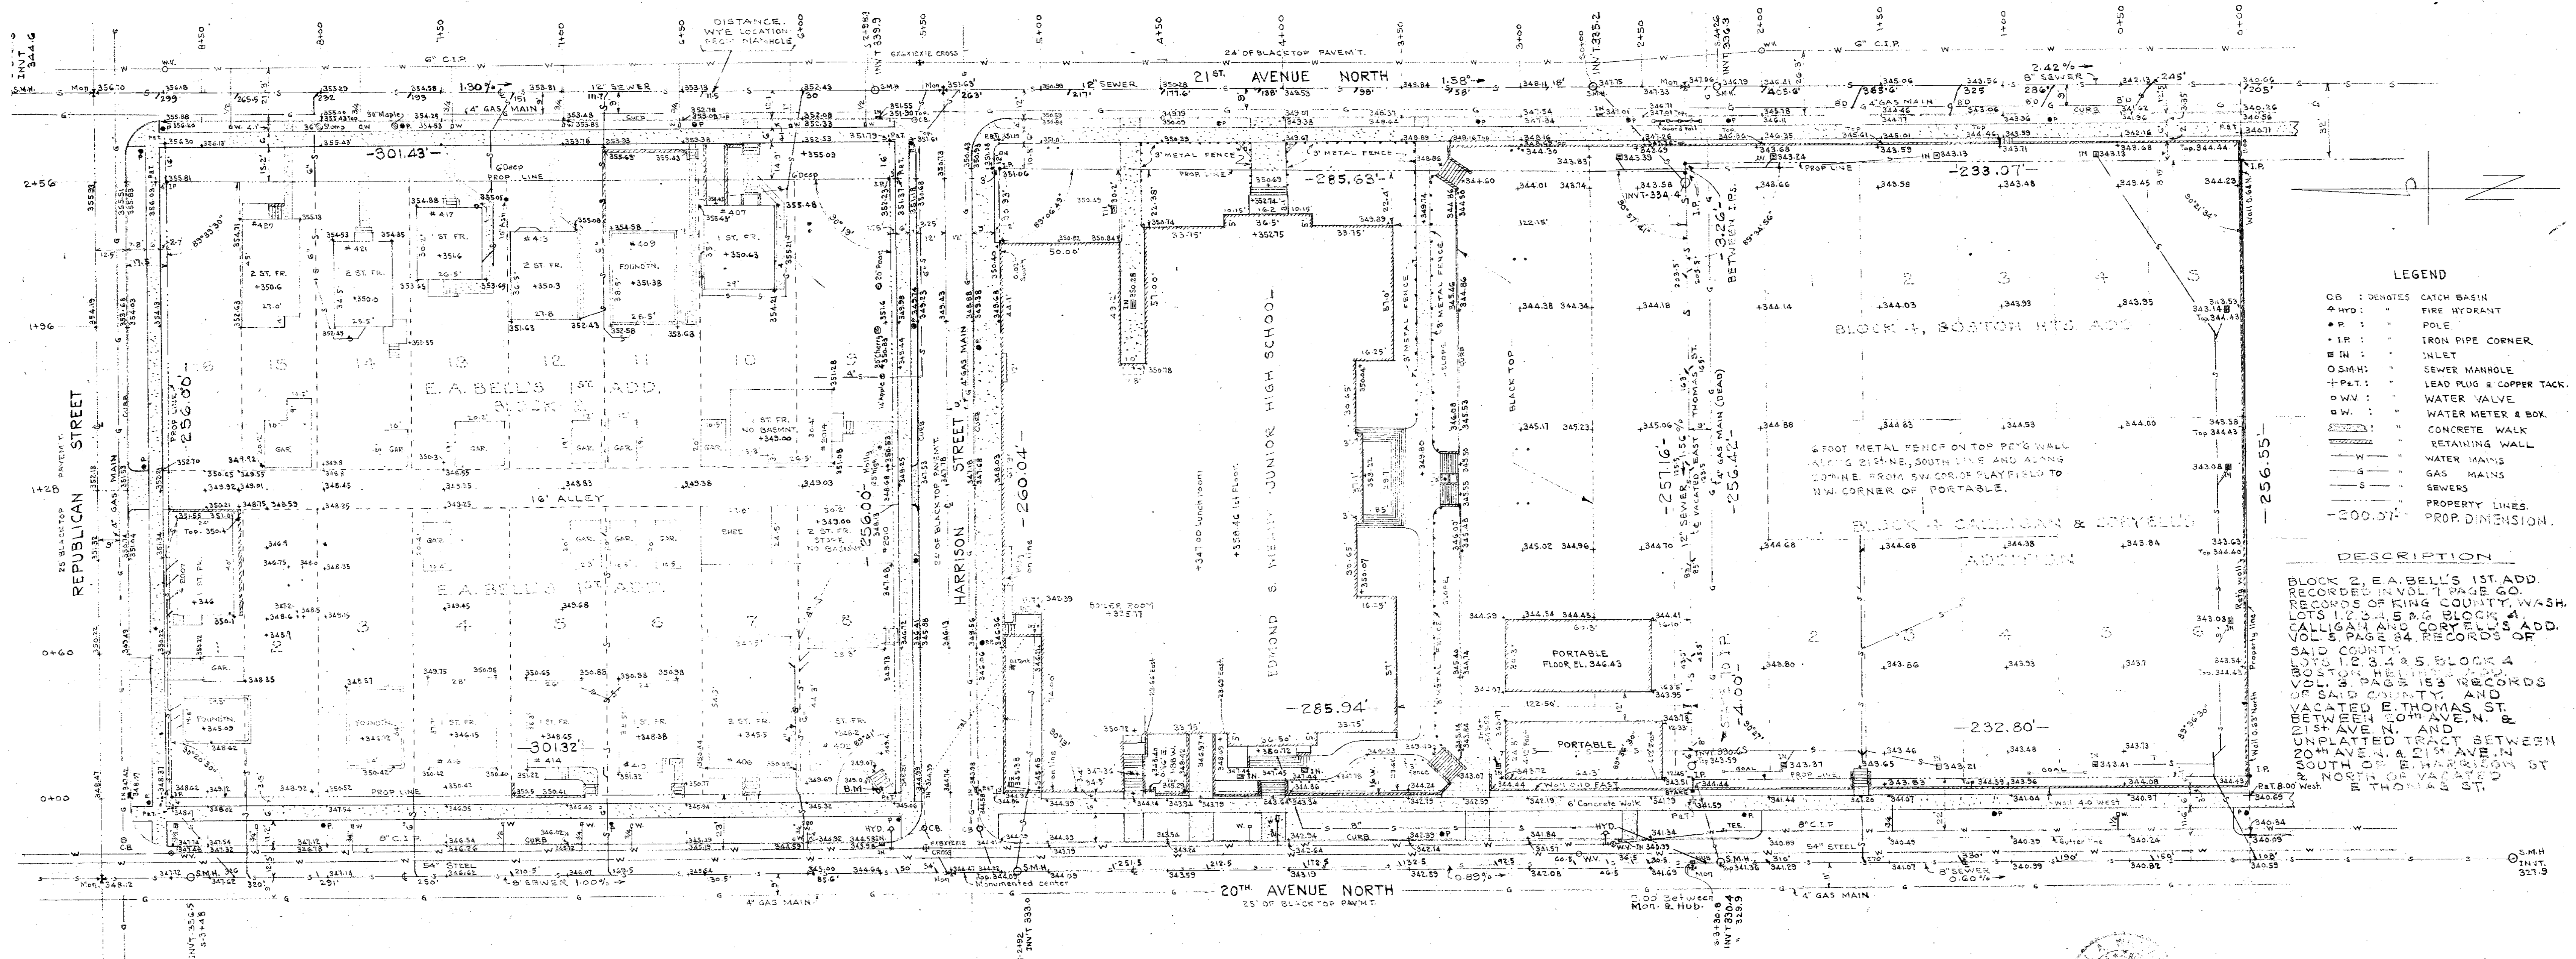


- LEGEND**
- GB : DENOTES CATCH BASIN
 - HYD : FIRE HYDRANT
 - P : POLE
 - IR : IRON PIPE CORNER
 - IN : INLET
 - SMH : SEWER MANHOLE
 - P&T : LEAD PUG & COPPER TACK
 - WV : WATER VALVE
 - WM : WATER METER & BOX
 - GW : CONCRETE WALK
 - RET : RETAINING WALL
 - W : WATER MAINS
 - G : GAS MAINS
 - S : SEWERS
 - : PROPERTY LINES
 - - - : PROP. DIMENSION

DESCRIPTION

BLOCK 2, E.A. BELL'S 1ST ADD. RECORDED IN VOL. 1 PAGE 60. RECORDS OF KING COUNTY, WASH. LOTS 1, 2, 3, 999, 1000.

NOTE:
INFORMATION ON UNDERGROUND UTILITIES, SEWER, WATER & GAS, OBTAINED FROM CITY ENGINEERS RECORDS.

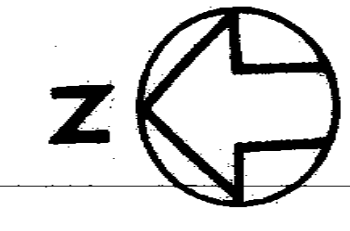




AMERICAN ENGINEERING CO.
522 COLUMBIA ST.
SEATTLE 4, WASH. 56534

CITY S.M. ELEV. 348.52
X ON NORTH END CONC. STEP
EW. CORNER R. REPUBLICAN & 20TH ST.


CITY S.M. ELEV. 345.72
X ON WEST END OF 1ST STEP
NORTHEAST CORNER
HARRISON ST. & 20TH AVE. N.
HOUSE NO. 406

SURVEY UNIT A

EDMOND MEANY JUNIOR HIGH - RECREATION PROJECT
FOR THE
SEATTLE PUBLIC SCHOOL DISTRICT No. 1
AND THE
SEATTLE DEPARTMENT OF PARKS
20TH AVENUE NORTH AT EAST REPUBLICAN STREET - SEATTLE, WASHINGTON
DATE 6-27-54
DRAWN BY JOHN W. MALONEY
CHECKED BY
ARCHITECT
754 CENTRAL BUILDING 1117 LARSON BLDG.
SEATTLE WASHINGTON YAKIMA
A2
139-2047

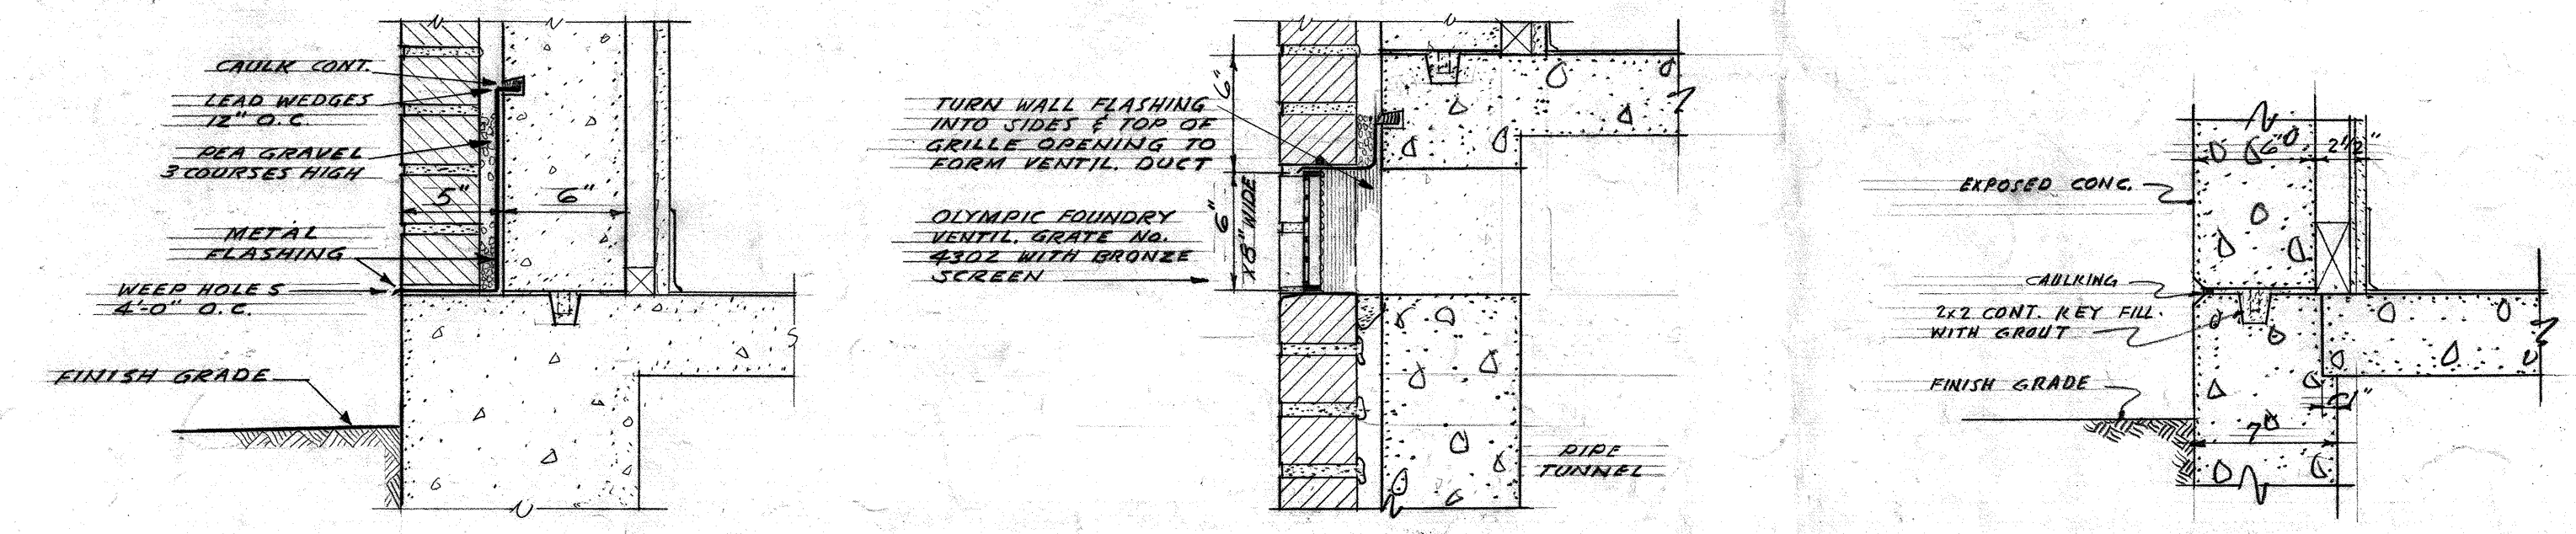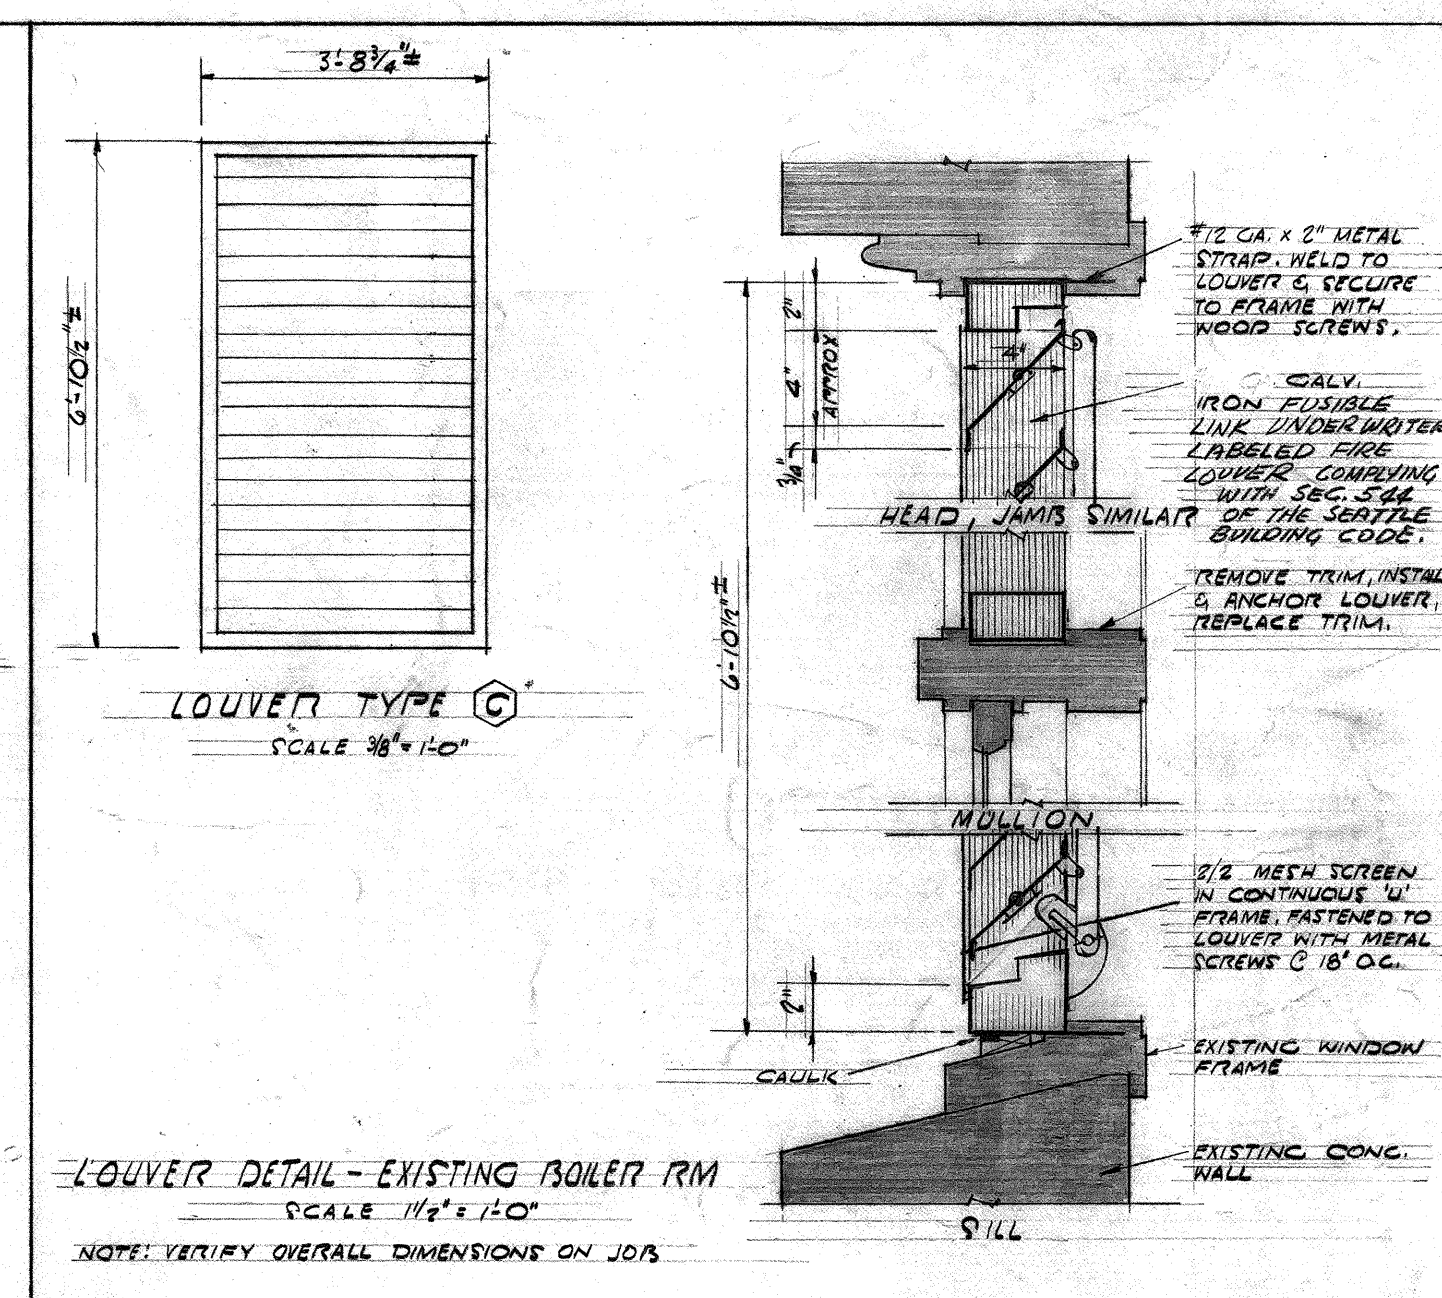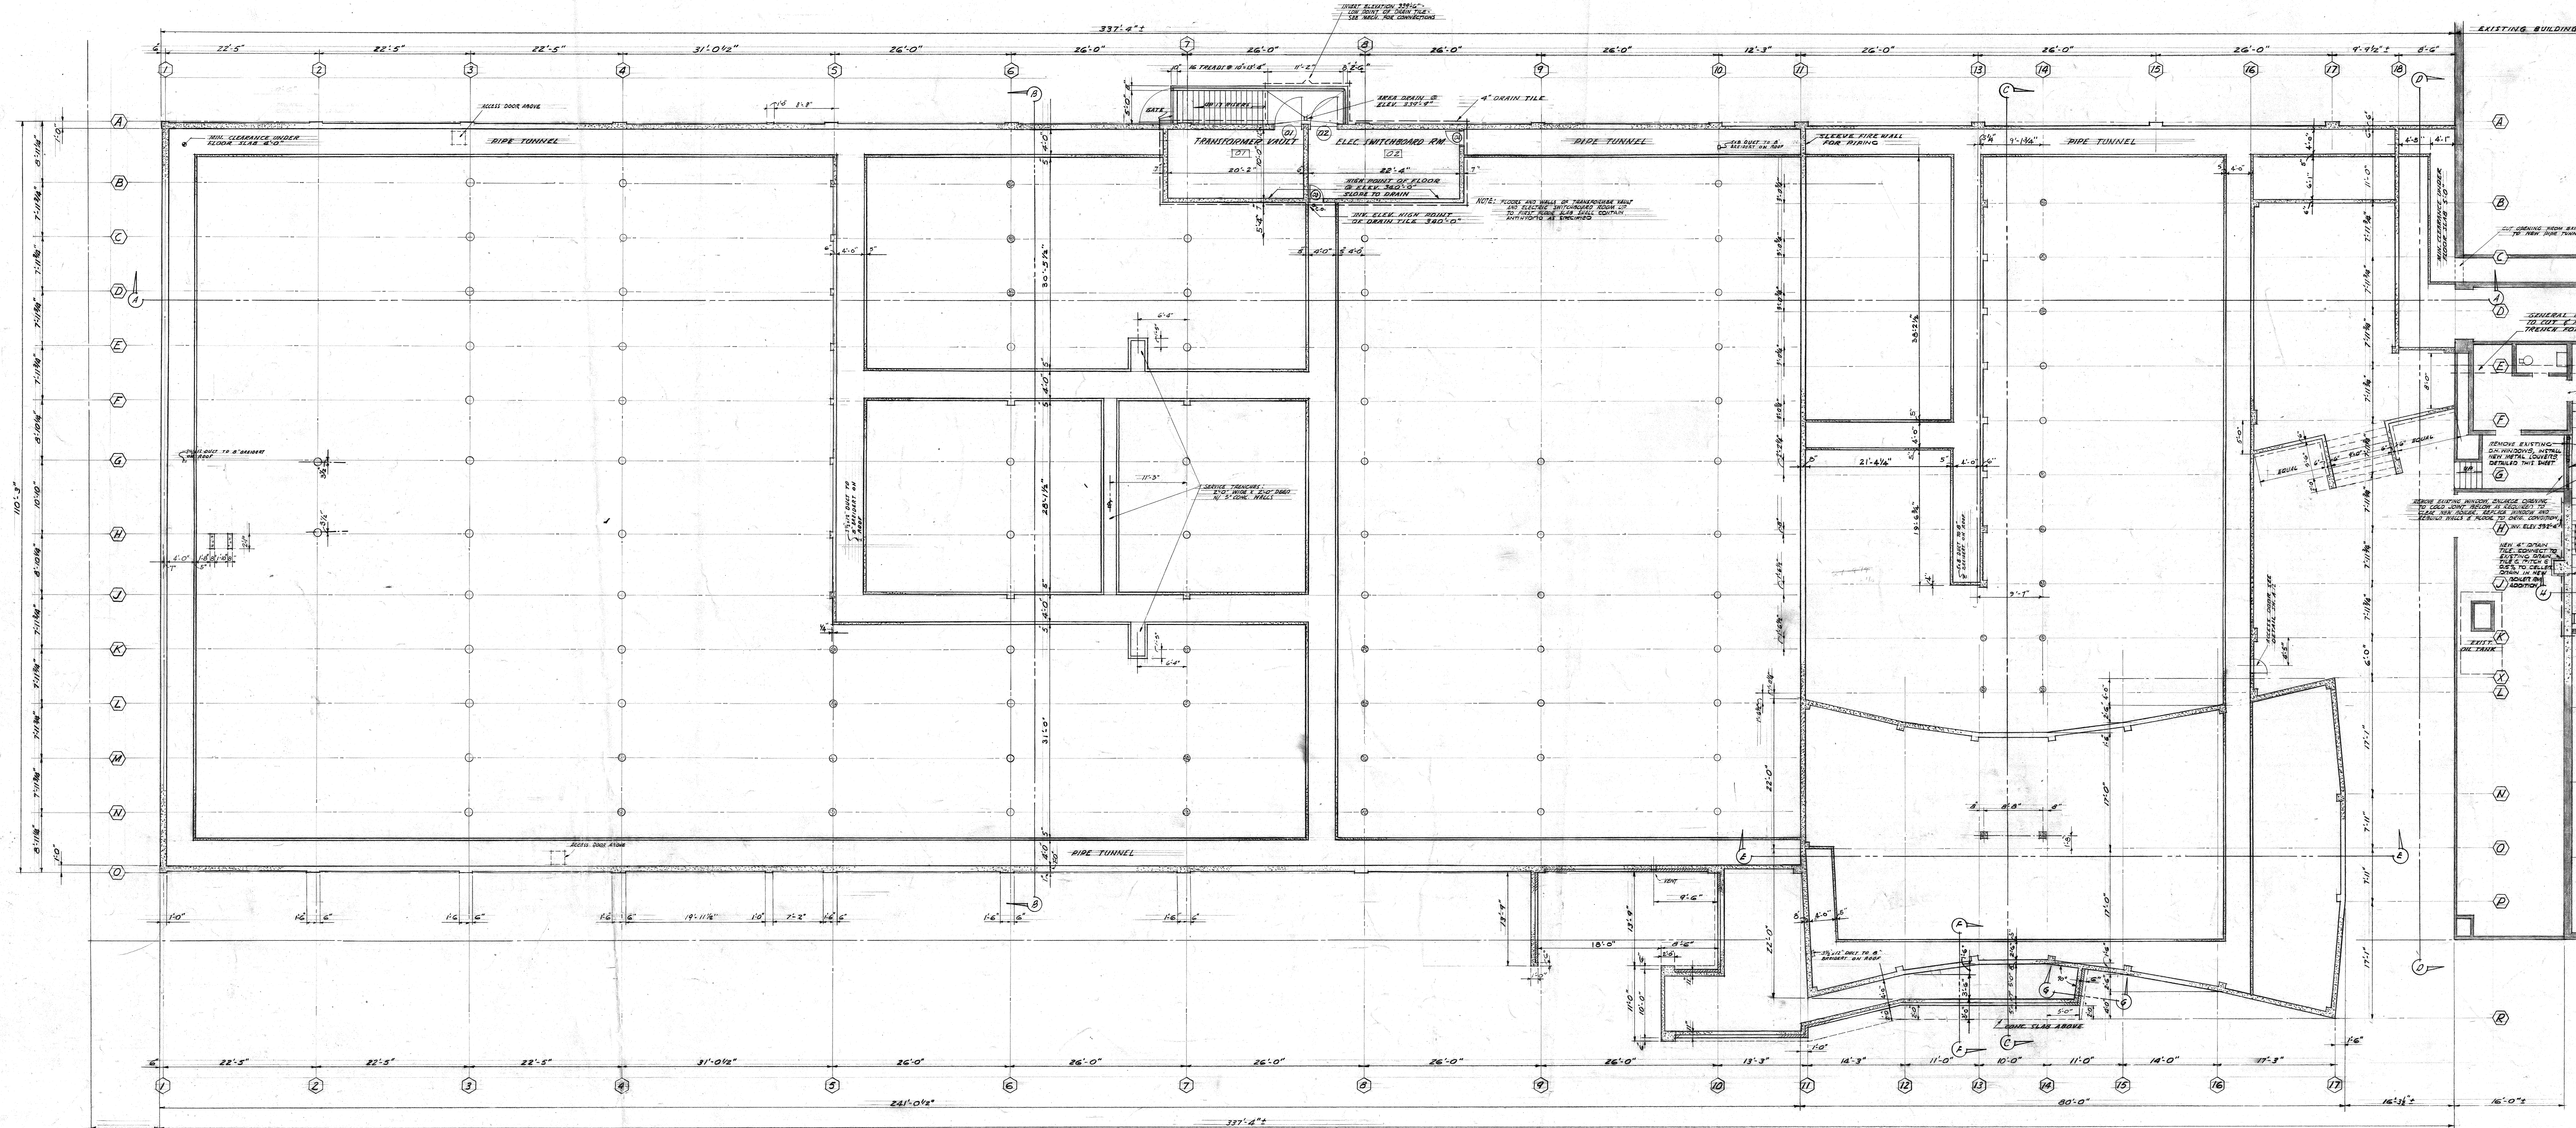

FOUNDATION & BASEMENT PLAN
 SCALE 1/4" = 1'-0"
 (SEE STRUCTURAL DRAWINGS FOR COMPLETE INFORMATION)

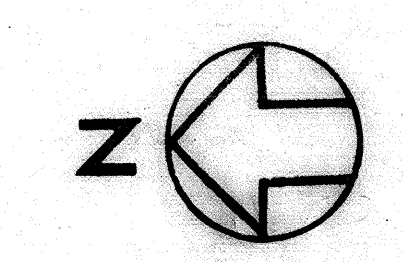

NOTES:
 1. FOR WORK IN CONNECTION WITH NEW BOILER ROOM ADDITION, SEE SHEETS A-12, A-13, A-14, & A-15.
 2. REVISOR TO AS-BUILT SHOWN. DRAWN: SERVICES. CHECKED: MAY 15, 1967.

FOUNDATION & BASEMENT PLAN-UNIT A

EDMOND MEANY JUNIOR HIGH - RECREATION PROJECT
 FOR THE
 SEATTLE PUBLIC SCHOOL DISTRICT No. 1
 SEATTLE DEPARTMENT OF PARKS
 20th AVENUE NORTH AND 1ST AVENUE SOUTH - SEATTLE, WASHINGTON

DATE: 6-21-66
 DRAWN: JOHN W. MALONEY
 CHECKED: A. I. A.
 A3 ARCHITECT
 724 CENTRAL BUILDING 1117 LARSON BLDG.
 SEATTLE WASHINGTON YAKIMA

139.0046